

APPROVED AS TO IMPACT ON STATE FACILITIES AND CONFORMANCE WITH APPLICABLE STATE STANDARDS AND PRACTICES AND THAT TECHNICAL OVERSIGHT WAS PERFORMED.

DATE SIGNED 9-3-2020

LICENSE Exp DATE 6-30-2022

REGISTRATION No. C72005

CALTRANS DESIGN OVERSIGHT APPROVAL SCOTT W. MANN, PE

CONSULTANT DESIGN ENGINEER AARON S. BRUSATORI

INDEX OF PLANS


SHEET No.	DESCRIPTION
1	TITLE AND LOCATION
2-4	TYPICAL CROSS SECTIONS
5	PROJECT CONTROL
6-7	LAYOUTS
8	PROFILE AND SUPERELEVATION DIAGRAM
9-11	CONSTRUCTION DETAILS
12-13	WATER POLLUTION CONTROL PLANS
14-16	EROSION CONTROL PLANS, QUANTITIES, AND LEGEND
17-18	CONTOUR GRADING
19-24	DRAINAGE PLANS, PROFILES, DETAILS, AND QUANTITIES
25	CONSTRUCTION AREA SIGN PLAN
26-27	TRAFFIC HANDLING PLANS AND QUANTITIES
28-32	PAVEMENT DELINEATION AND SIGNS, SIGN DETAILS, AND QUANTITIES
33	SUMMARY OF QUANTITIES
34	INDEX OF ELECTRICAL SYSTEMS, PLANS, NOTES, LEGEND, AND ABBREVIATIONS
35	RAMP METERING SYSTEM
36-37	MODIFYING LIGHTING SYSTEMS
38-39	MODIFYING SIGNAL AND LIGHTING SYSTEMS
40-44	ELECTRICAL SYSTEMS DETAILS
45	ELECTRICAL SYSTEMS QUANTITIES

STATE OF CALIFORNIA
DEPARTMENT OF TRANSPORTATION

PROJECT PLANS FOR CONSTRUCTION ON
STATE HIGHWAY
IN EL DORADO COUNTY
IN PLACERVILLE
FROM 0.6MI EAST OF
THE PLACERVILLE DRIVE OVERCROSSING
TO 0.2MI EAST OF THE
RAY LAWYER DRIVE OVERCROSSING

TO BE SUPPLEMENTED BY STANDARD PLANS DATED 2018

WESTERN PLACERVILLE INTERCHANGES PROJECT
PHASE 2.2

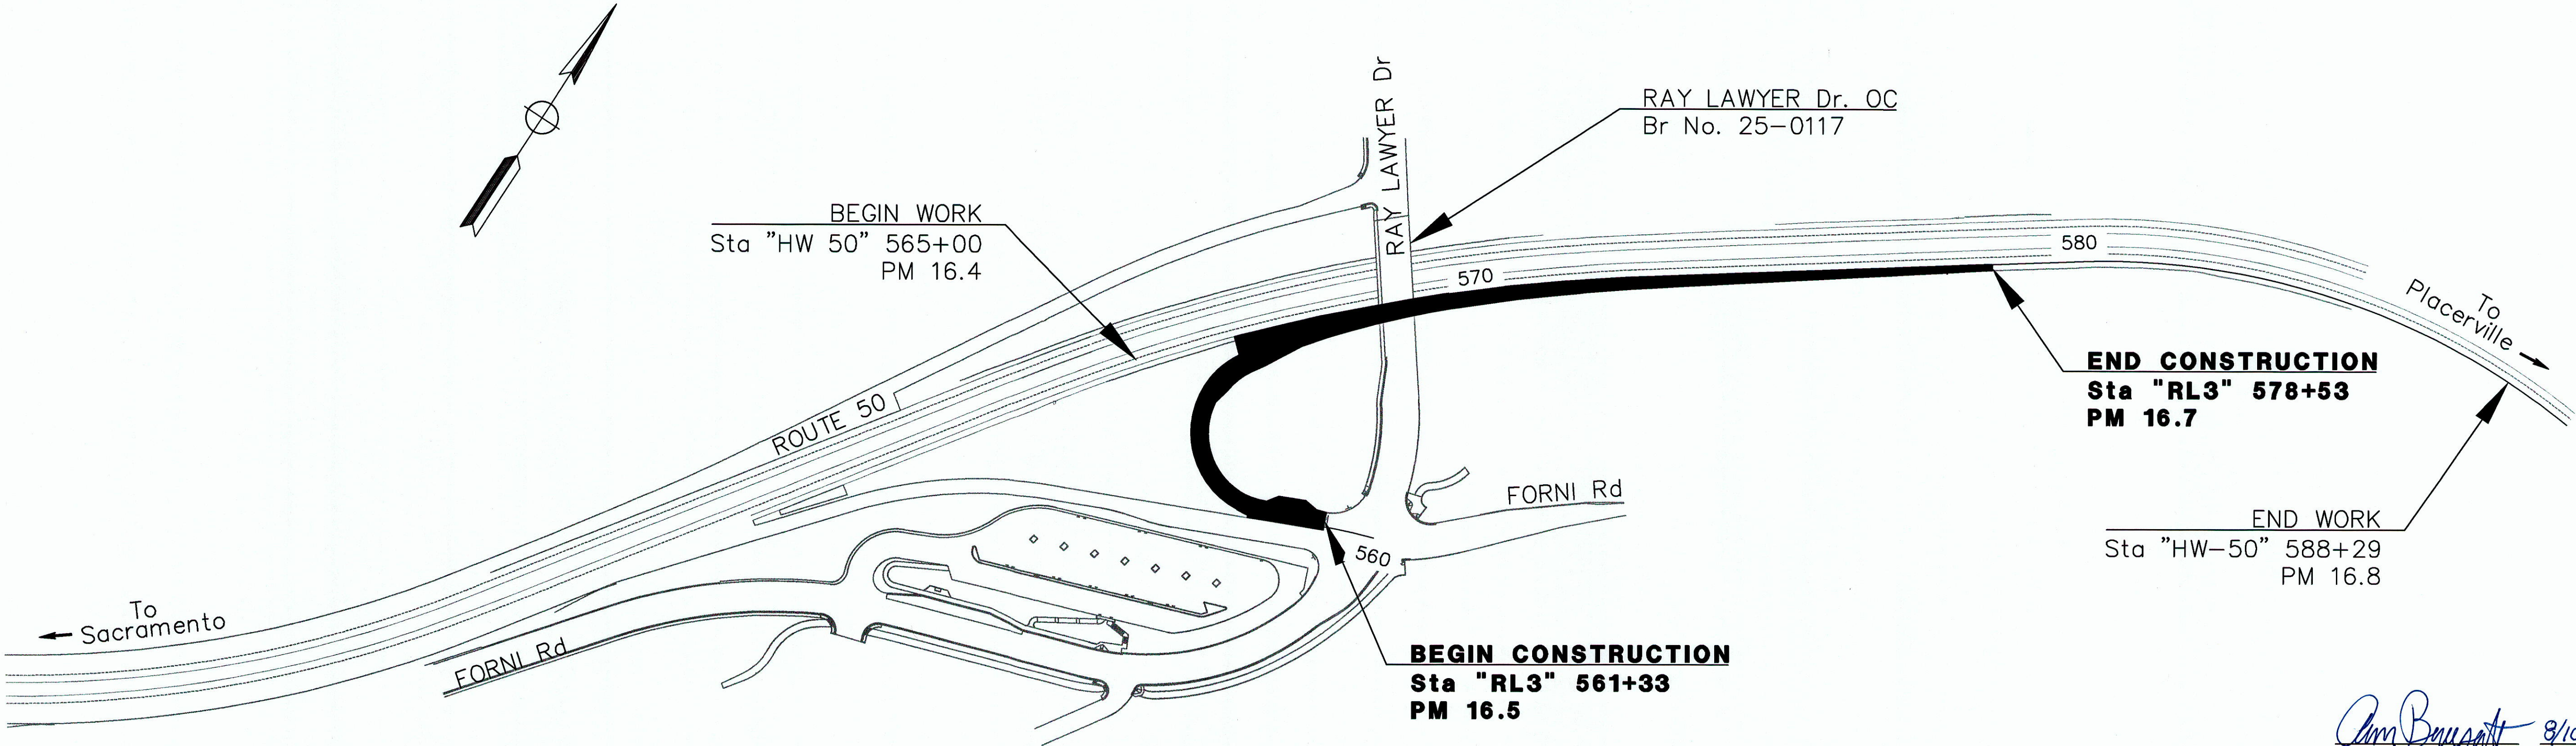

Aaron Brusatori 8/10/20
AARON S. BRUSATORI
PROJECT ENGINEER
REGISTERED CIVIL ENGINEER
No. 64384
Exp. 6/30/21
AUGUST 31, 2020
PLANS APPROVAL DATE

APPROVED BY:

Rebecca Neves 8/10/20
REBECCA NEVES
CITY ENGINEER
CITY OF PLACERVILLE

THE CONTRACTOR SHALL POSSESS THE CLASS (OR CLASSES)
OF LICENSE AS SPECIFIED IN THE "NOTICE TO BIDDERS."

NO SCALE

CONTRACT No. 03-37282

STATE OF CALIFORNIA - DEPARTMENT OF TRANSPORTATION

Caltrans

CONSULTANT FUNCTIONAL SUPERVISOR

VERONICA GARCIA-MCGREW

REVISOR

AARON S. BRUSATORI

CHECKED BY





AARON BRUSATORI, PE

NOTE:

1. DIMENSIONS OF THE PAVEMENT STRUCTURES (STRUCTURAL SECTIONS) ARE SUBJECT TO TOLERANCES SPECIFIED IN THE STANDARD SPECIFICATIONS.
2. SUPERELEVATIONS ARE SHOWN ON PROFILE AND SUPERELEVATION DIAGRAMS.
3. LOCATION AND TYPES OF DIKES AND MIDWEST GUARDRAIL SYSTEMS ARE SHOWN ON LAYOUTS.
4. FOR CURB DETAILS, SEE STANDARD PLANS.

DESIGN DESIGNATION			
ADT	3,400	D	100%
AADT	3,400	T	2%
DHV	520	V	mph
ESAL	114,320	Tl ₂₀	8.0

PAVEMENT CLIMATE REGION
LOW MOUNTAIN

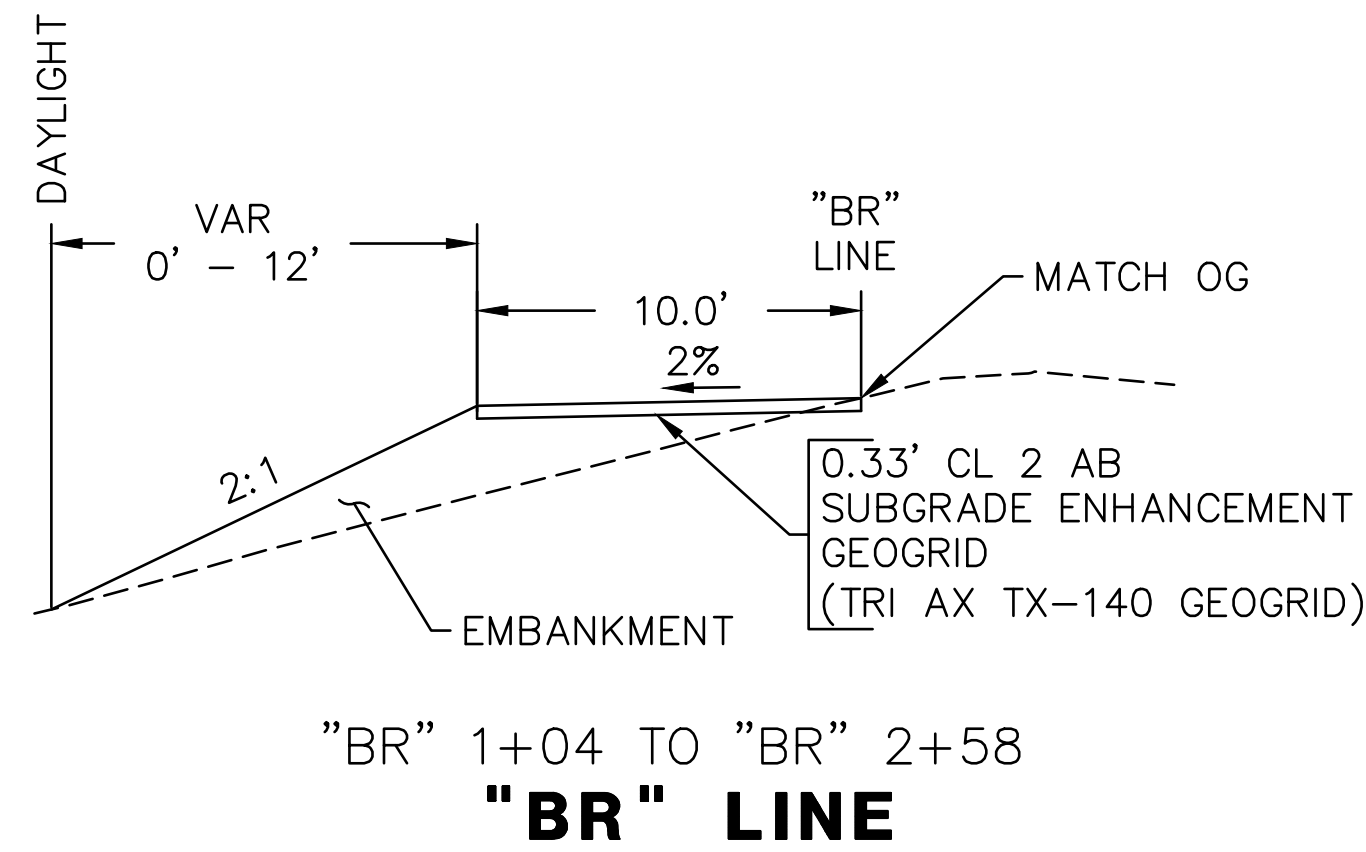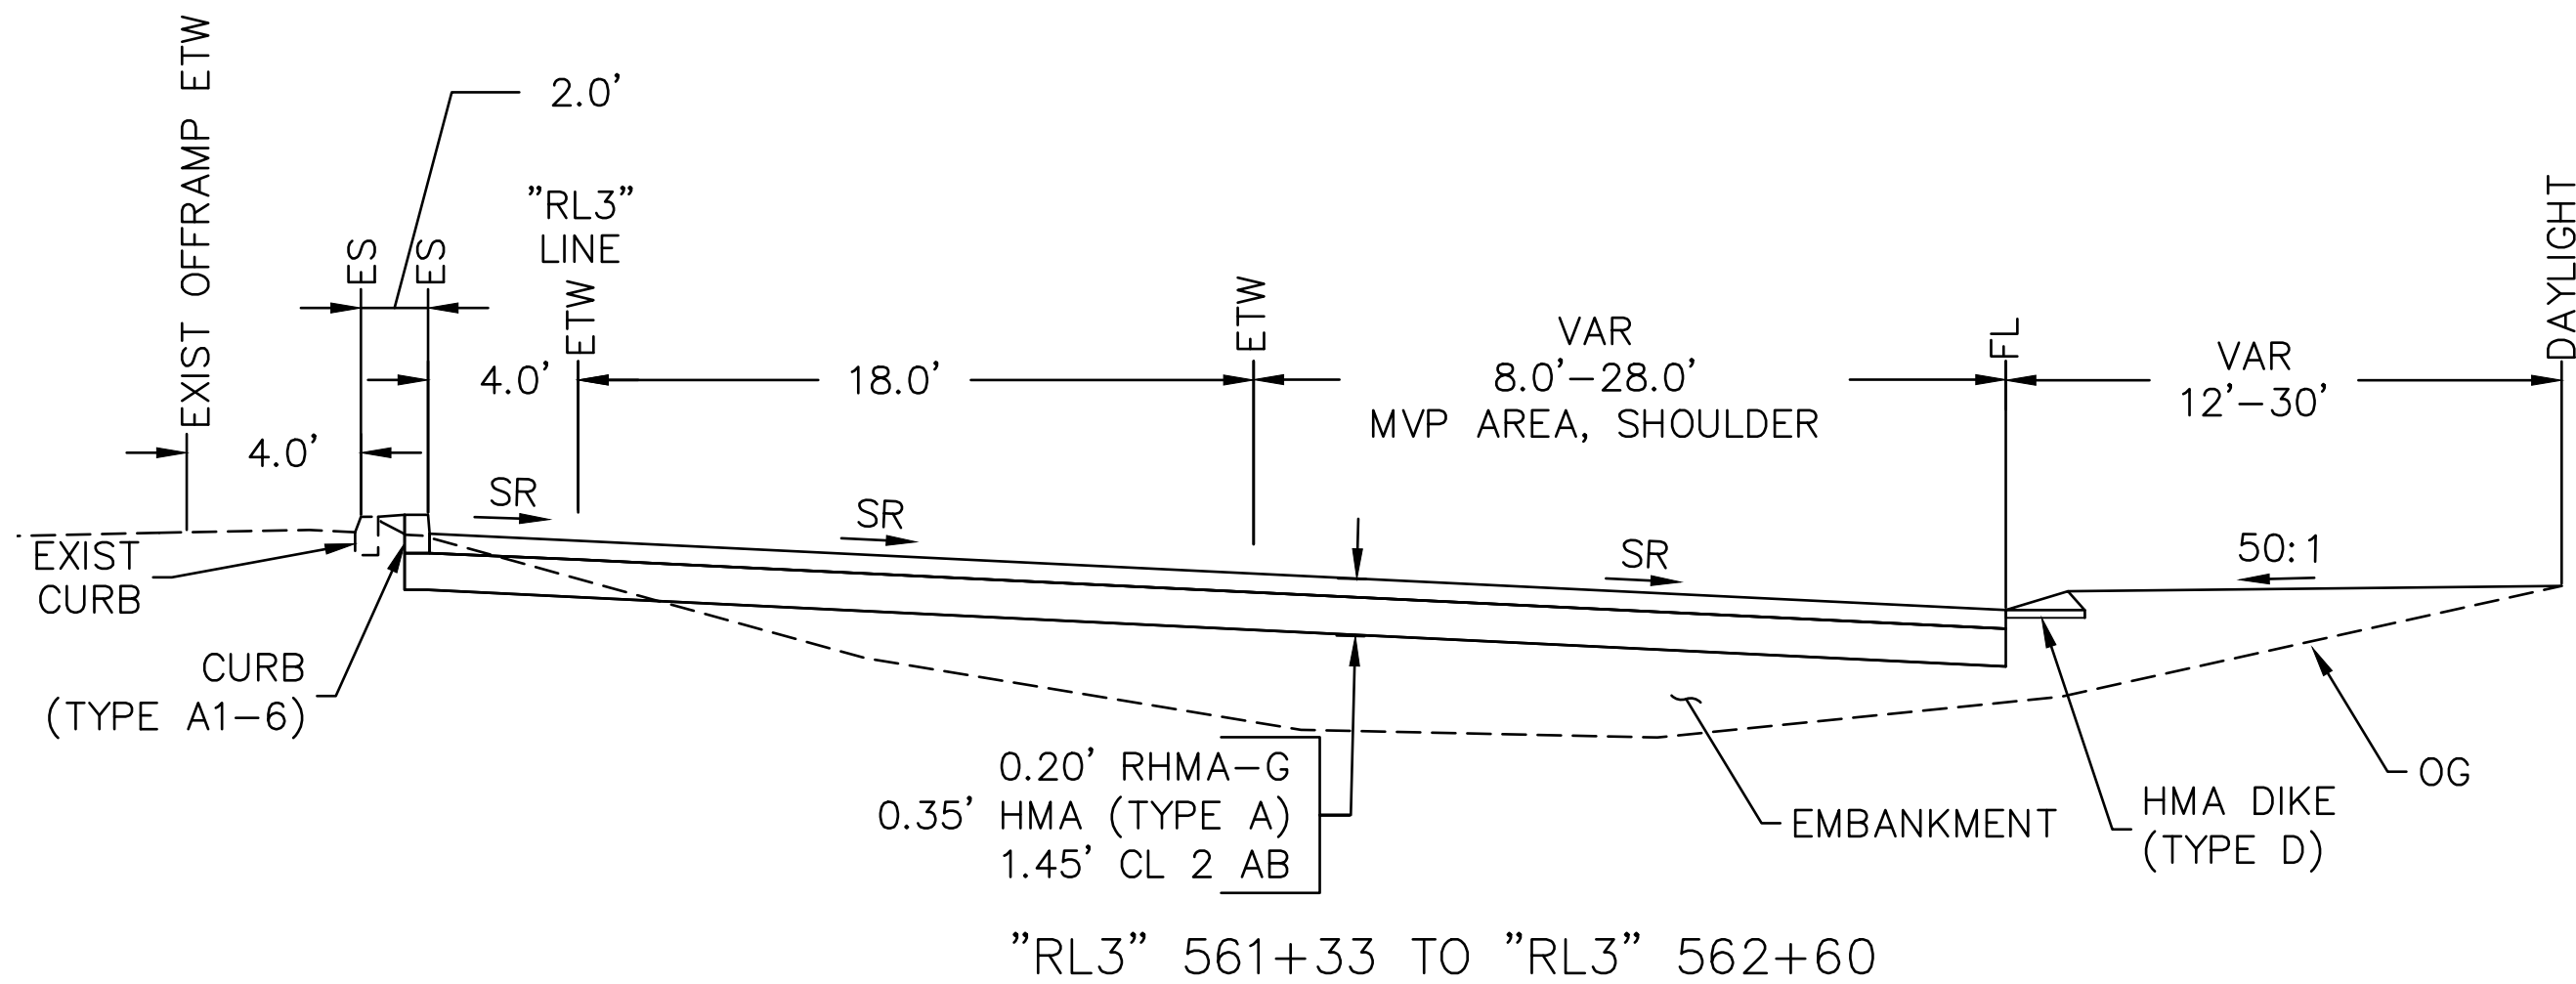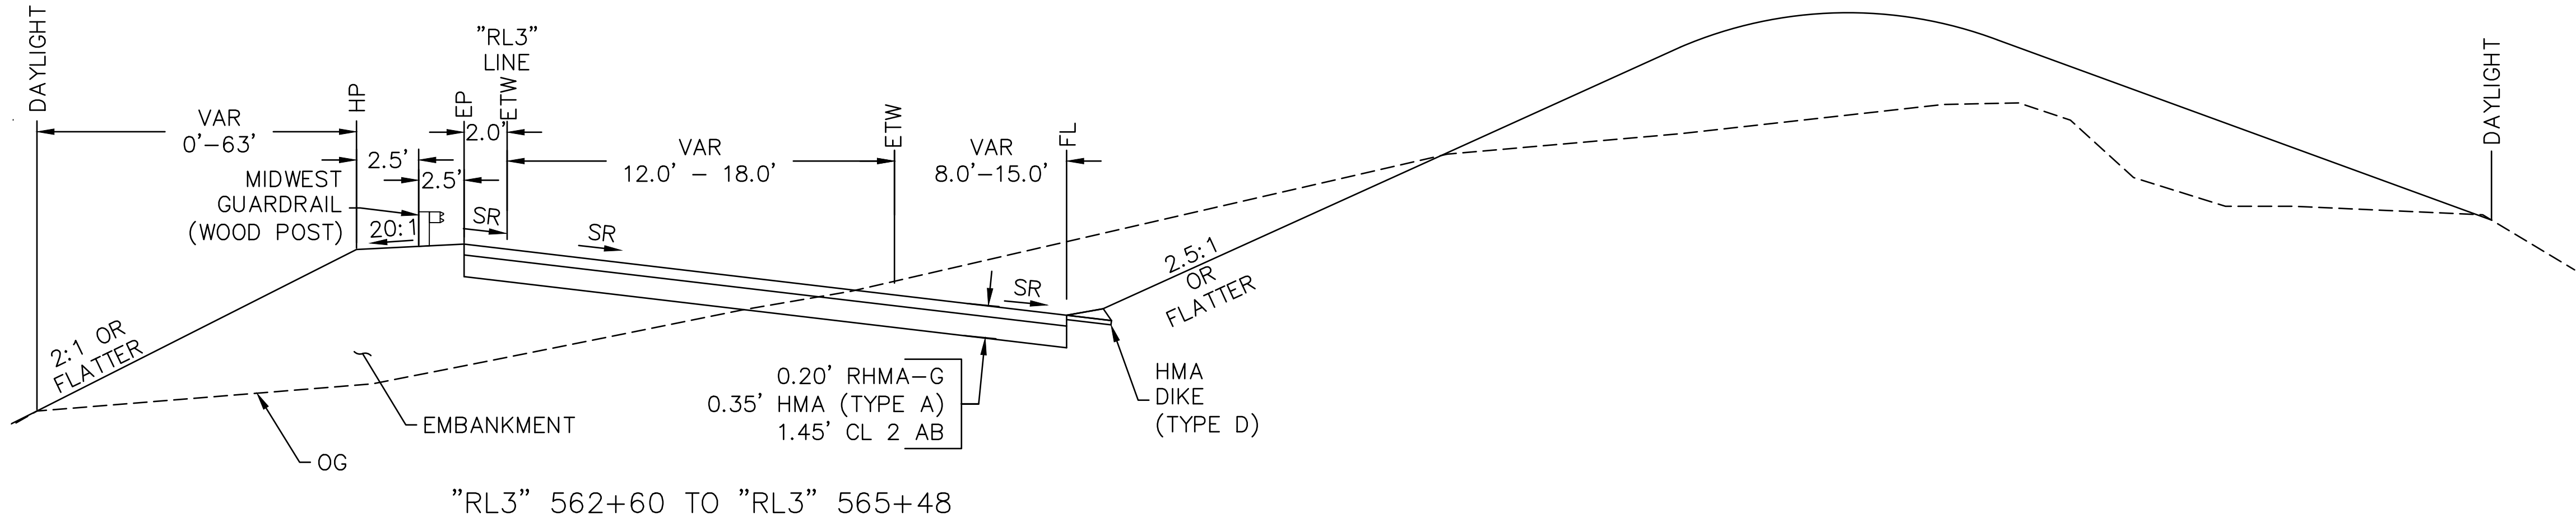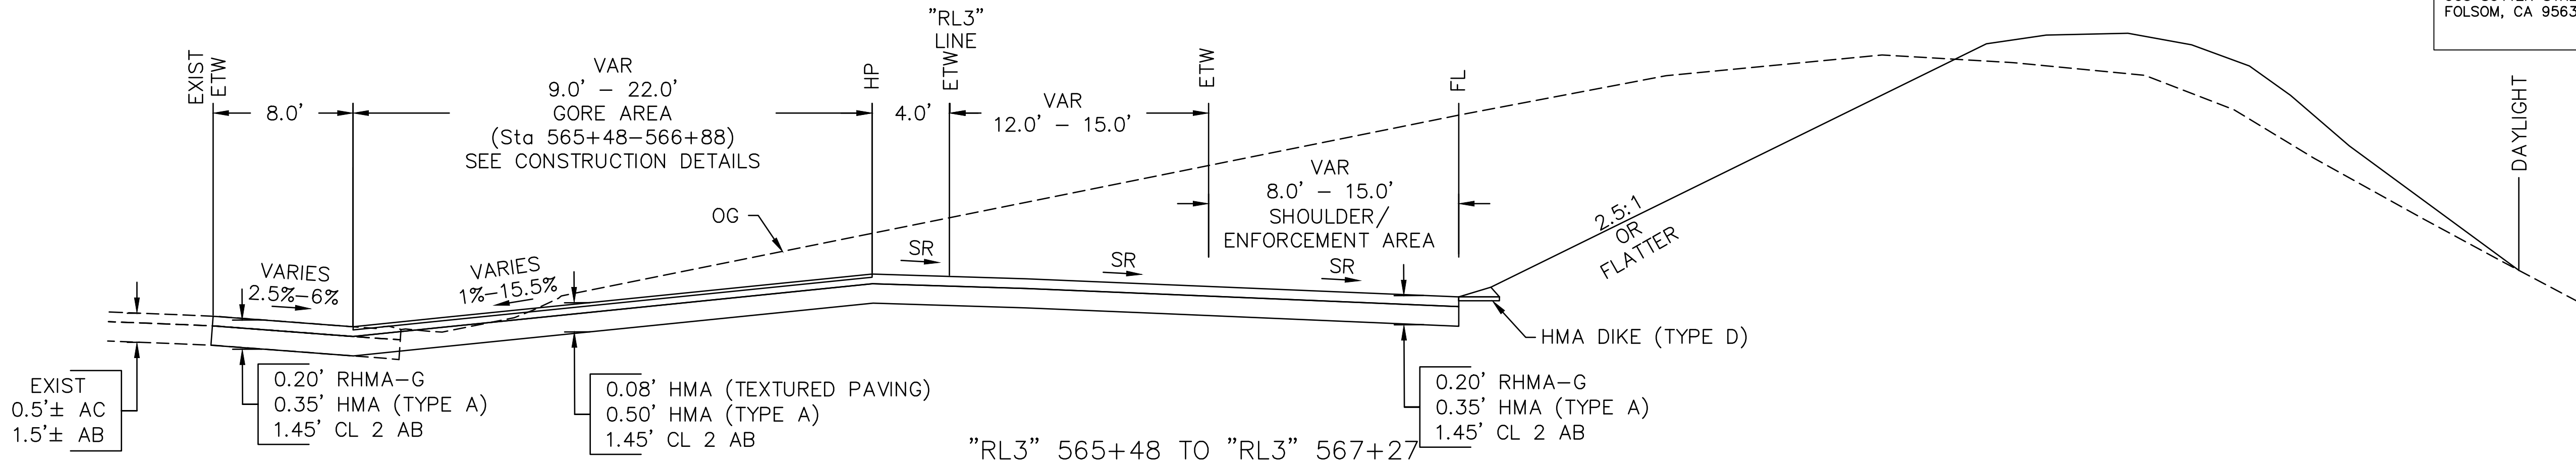

ON RAMP

TYPICAL CROSS SECTIONS

NO SCALE

X-1

DATE PLOTTED => 10/4/2020
TIME PLOTTED => 11:27 AM
LAST REVISION

STATE OF CALIFORNIA

Caltrans

DEPARTMENT OF TRANSPORTATION

CONSULTANT FUNCTIONAL SUPERVISOR

AARON BRUSATORI, PE

CALCULATED—DESIGNED BY

CHECKED BY




VERONICA GARCIA-MCGREW

AARON S. BRUSATORI

REVISED BY

DATE REVISED

NOTE:
FROM "RL3" STATION 568+00 TO
STATION 572+53, MATCH THE EXISTING
VERTICAL CURVE GEOMETRY OF "HW 50"
LINE.

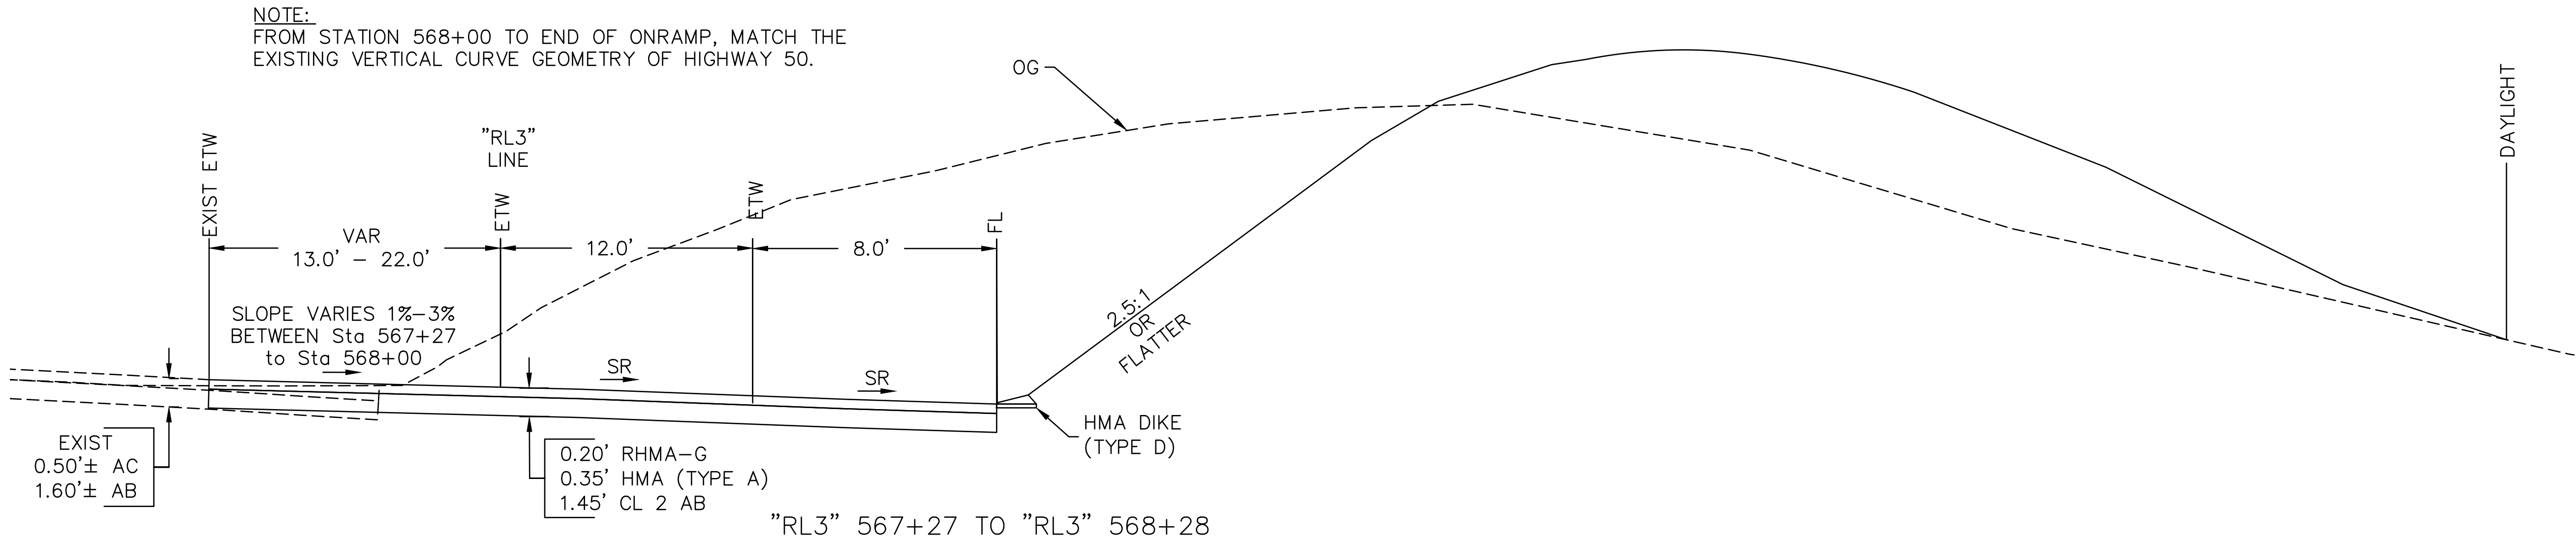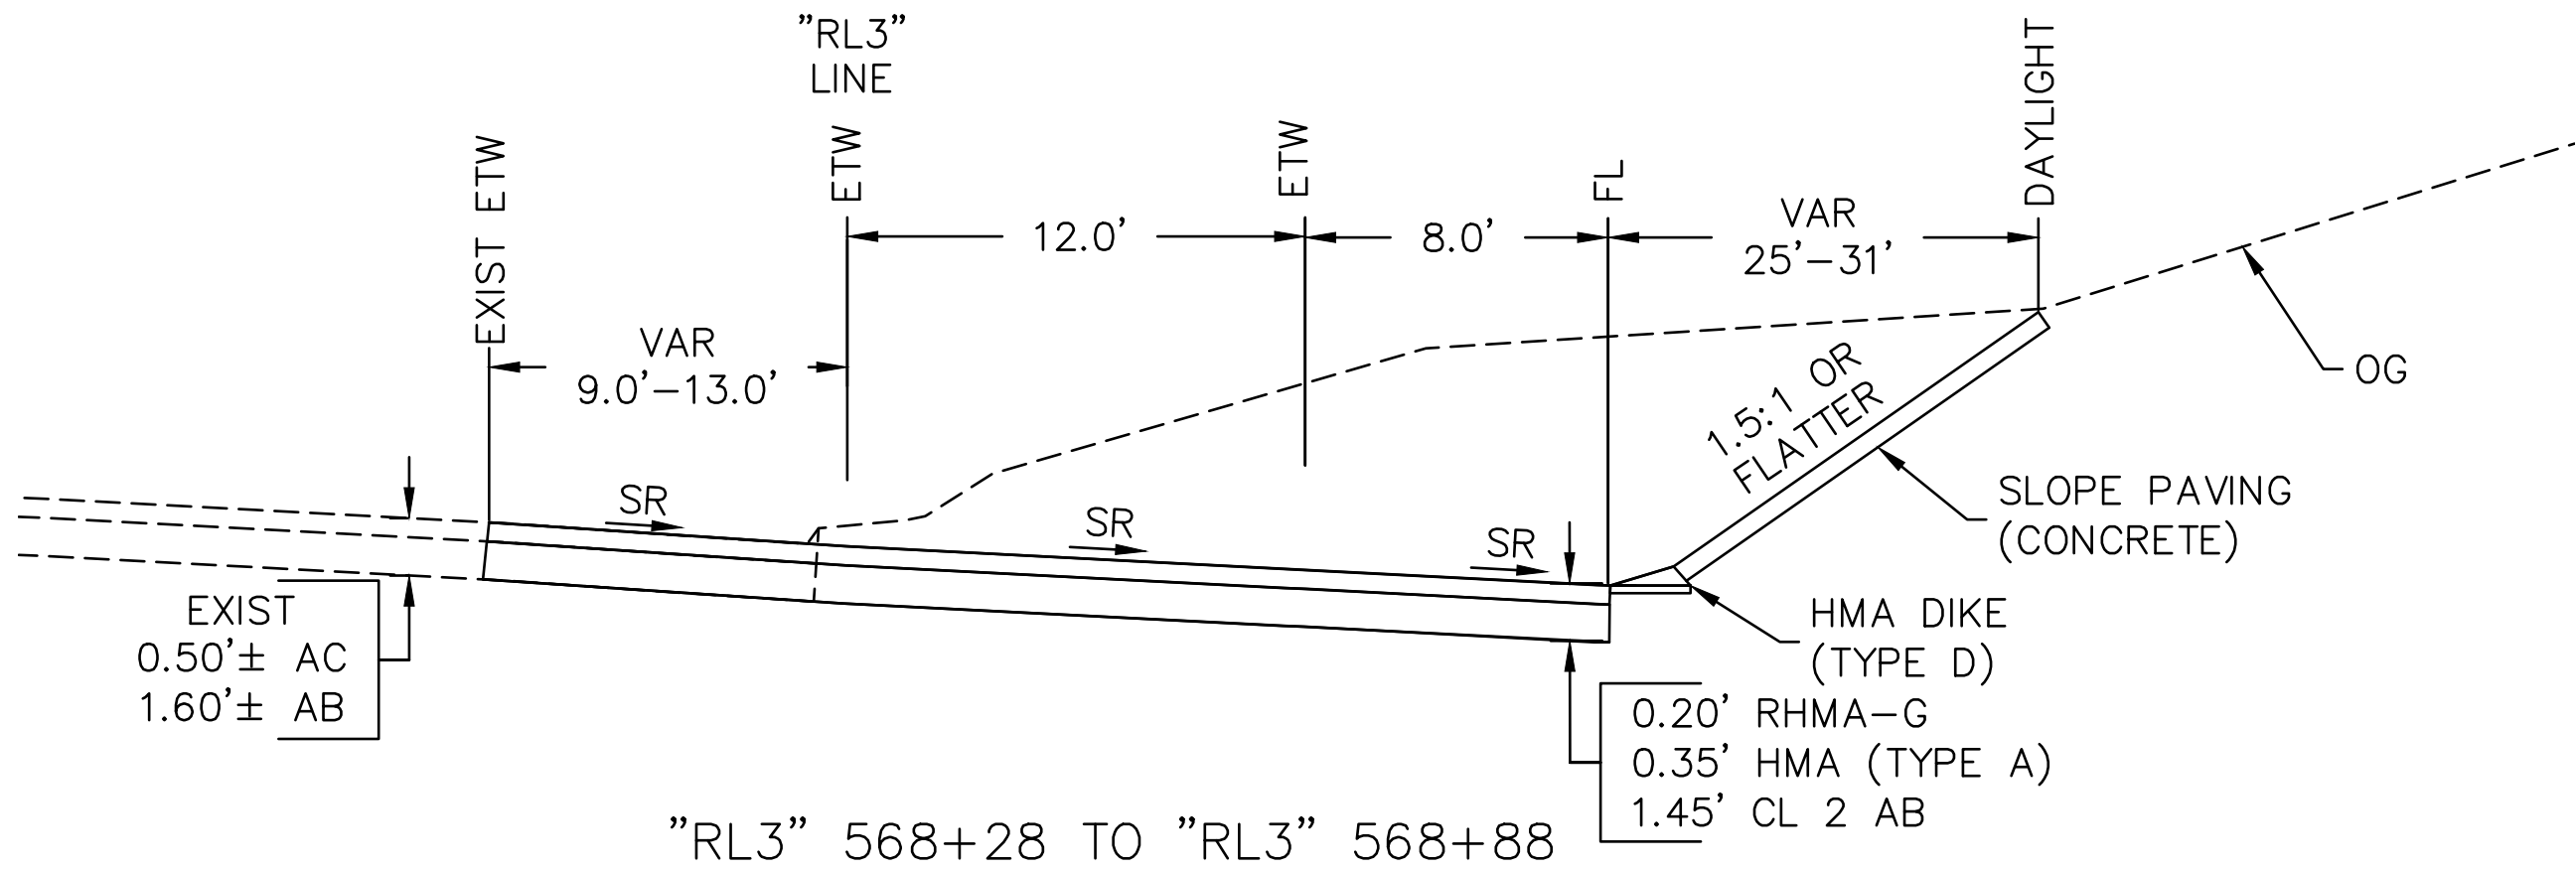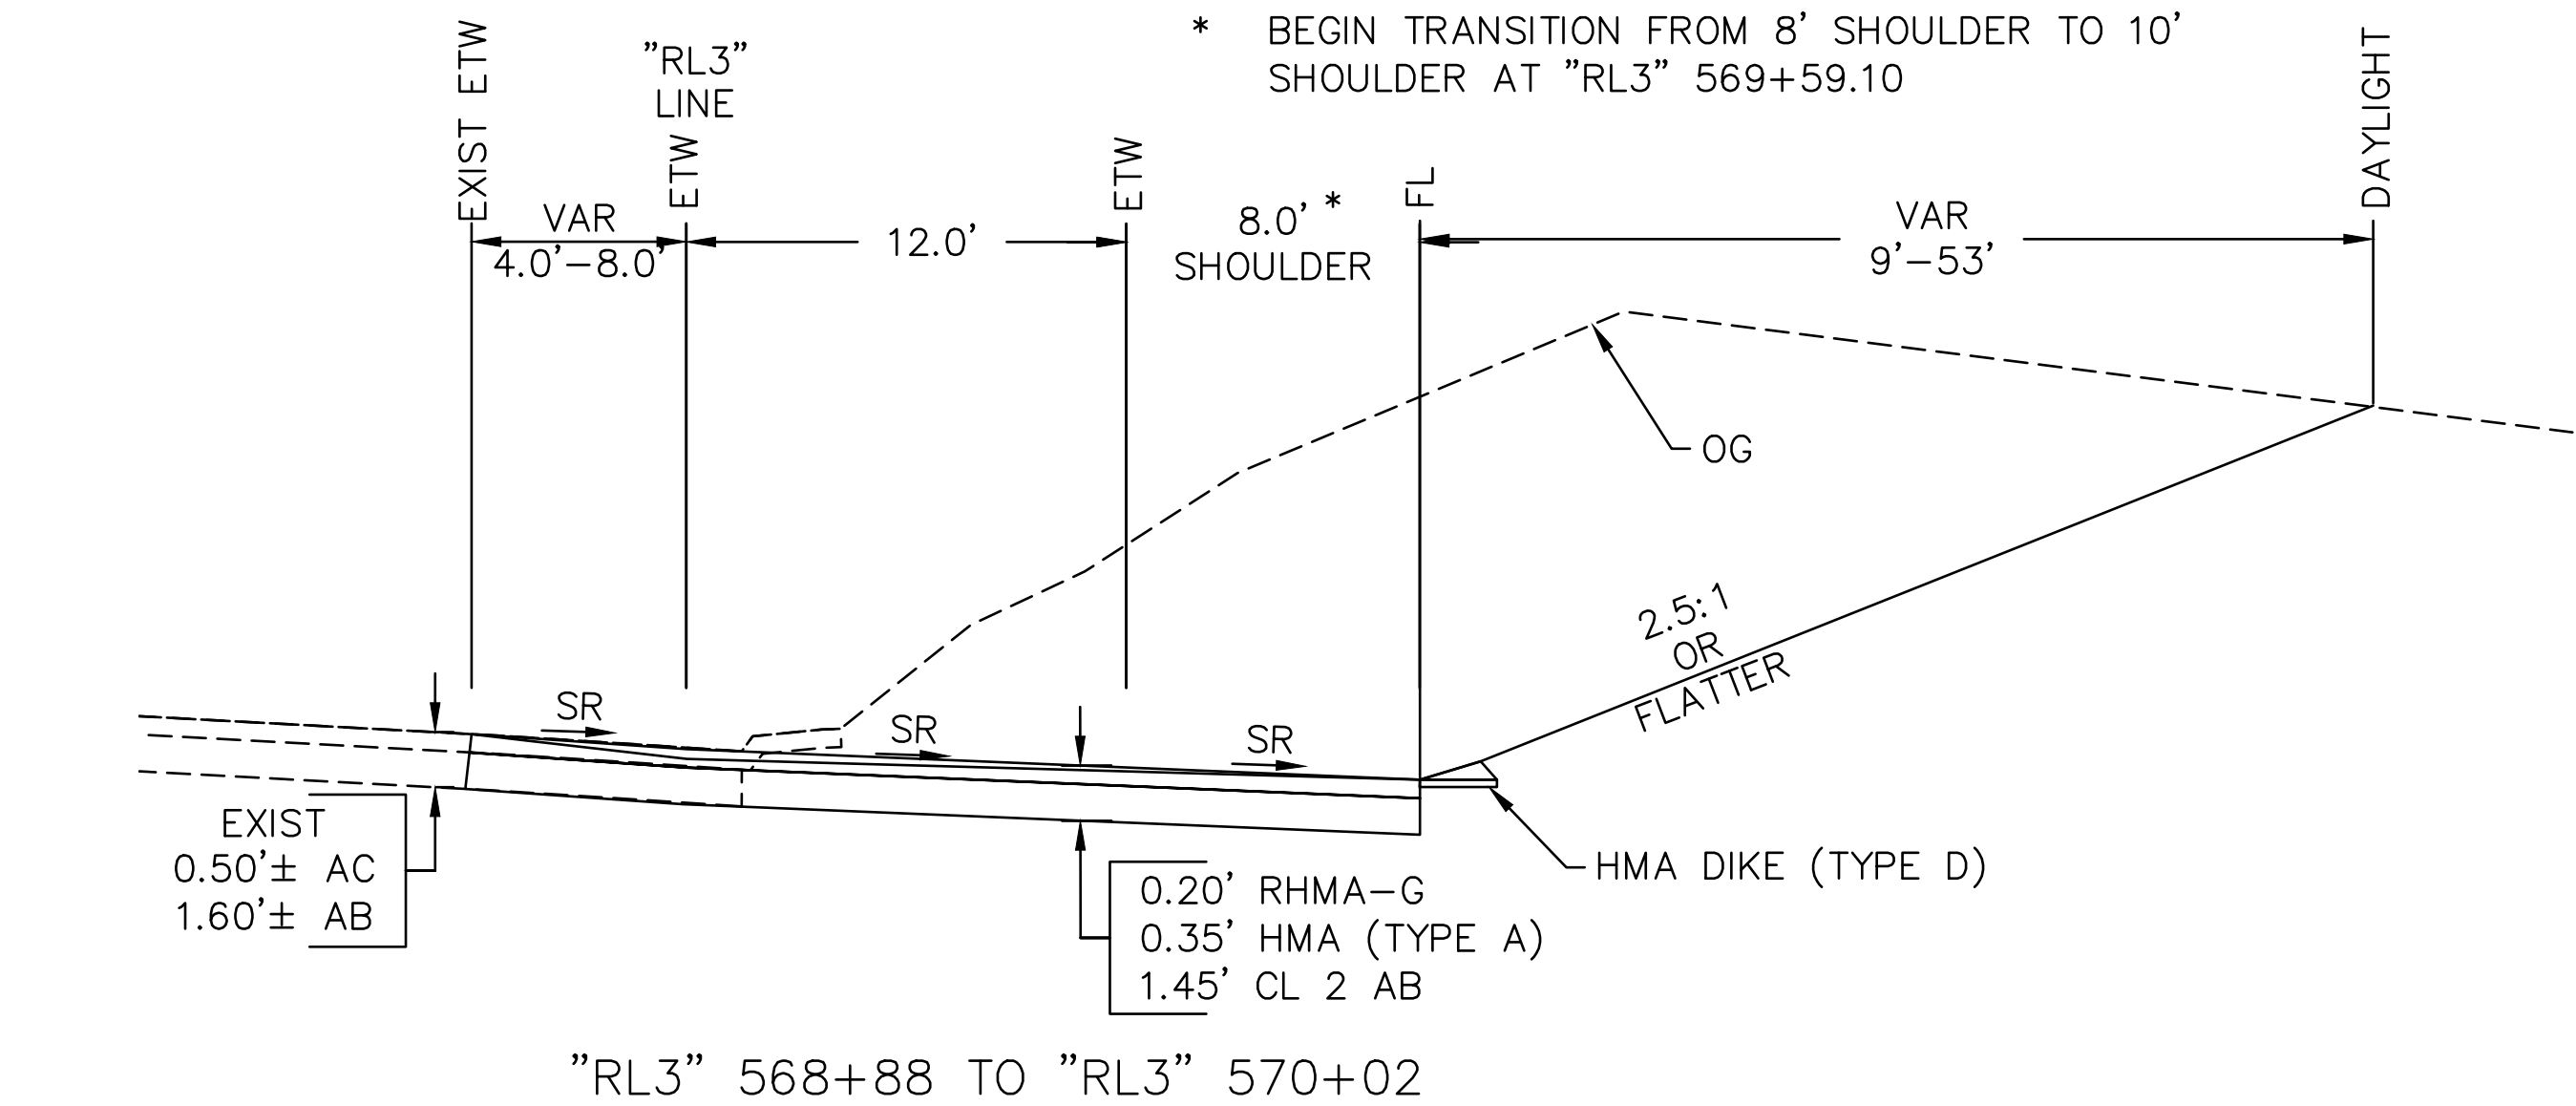

ROUTE 50

TYPICAL CROSS SECTIONS

NO SCALE

X-2

Dist	COUNTY	ROUTE	POST MILES TOTAL PROJECT	SHEET No.	TOTAL SHEETS
03	ED	50	16.4/16.8	3	45

Aaron Brusatori

REGISTERED CIVIL ENGINEER

8-07-20
DATE

AUGUST 31, 2020

PLANS APPROVAL DATE

THE STATE OF CALIFORNIA OR ITS OFFICERS
OR AGENTS SHALL NOT BE RESPONSIBLE FOR
THE ACCURACY OR COMPLETENESS OF SCANNED
COPIES OF THIS PLAN SHEET.

R.E.Y. ENGINEERS
905 SUTTER STREET, SUITE 200
FOLSOM, CA 95630

REGISTERED PROFESSIONAL ENGINEER
AARON
BRUSATORI
No. 64384
Exp. 6/30/21
CIVIL
STATE OF CALIFORNIA

CITY OF PLACERVILLE
ENGINEERING DEPARTMENT
3101 CENTER STREET
PLACERVILLE, CA 95667

NOTE:

- 1. FOR ACCURATE RIGHT OF WAY DATA, CONTACT RIGHT OF WAY ENGINEERING AT THE DISTRICT OFFICE.
- 2. STATION-OFFSET CALLOUTS ON LAYOUT SHEETS REFER TO "RL3" LINE ONLY.

LEGEND:

- REMOVE TREE
- HMA (TEXTURED PAVING)
- SLOPE PAVING (CONCRETE)

CURVE TABLE

CURVE	RADIUS	DELTA	TANGENT	LENGTH
①	1020.00	5°43'04"	50.94	101.792
②	140.00	147°33'44"	481.29	360.56
③	1467.00	14°10'00"	182.29	362.72
④	3000.00	6°42'21"	175.76	351.12
⑤	2999.56	19°41'00"	520.36	1030.46
⑥	754.00	8°29'03"	55.93	111.65
⑦	523.91	7°25'56"	34.03	67.96
⑧	93.48	36°51'49"	31.16	60.15

Dist

COUNTY

ROUTE

POST MILES
TOTAL PROJECT

SHEET
No.

TOTAL
SHEETS

03

ED

50

16.4/16.8

6

45

REGISTERED CIVIL ENGINEER

DATE

8-07-20

AUGUST 31, 2020

PLANS APPROVAL DATE

THE STATE OF CALIFORNIA OR ITS OFFICERS
OR AGENTS SHALL NOT BE RESPONSIBLE FOR
THE ACCURACY OR COMPLETENESS OF SCANNED
COPIES OF THIS PLAN SHEET.

R.E.Y. ENGINEERS
905 SUTTER STREET, SUITE 200
FOLSOM, CA 95630

CITY OF PLACERVILLE
ENGINEERING DEPARTMENT
3101 CENTER STREET
PLACERVILLE, CA 95667

PROFESSIONAL ENGINEER



AARON BRUSATORI


No. 64384

Exp. 6/30/21

CIVIL

STATE OF CALIFORNIA

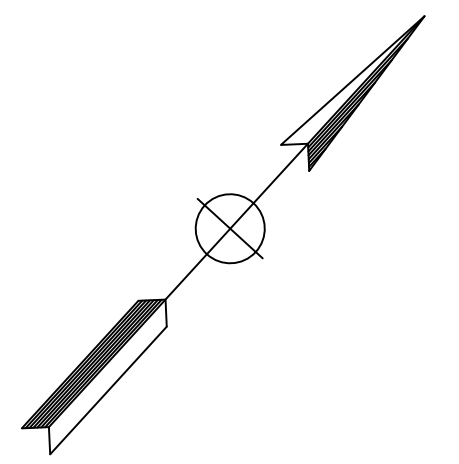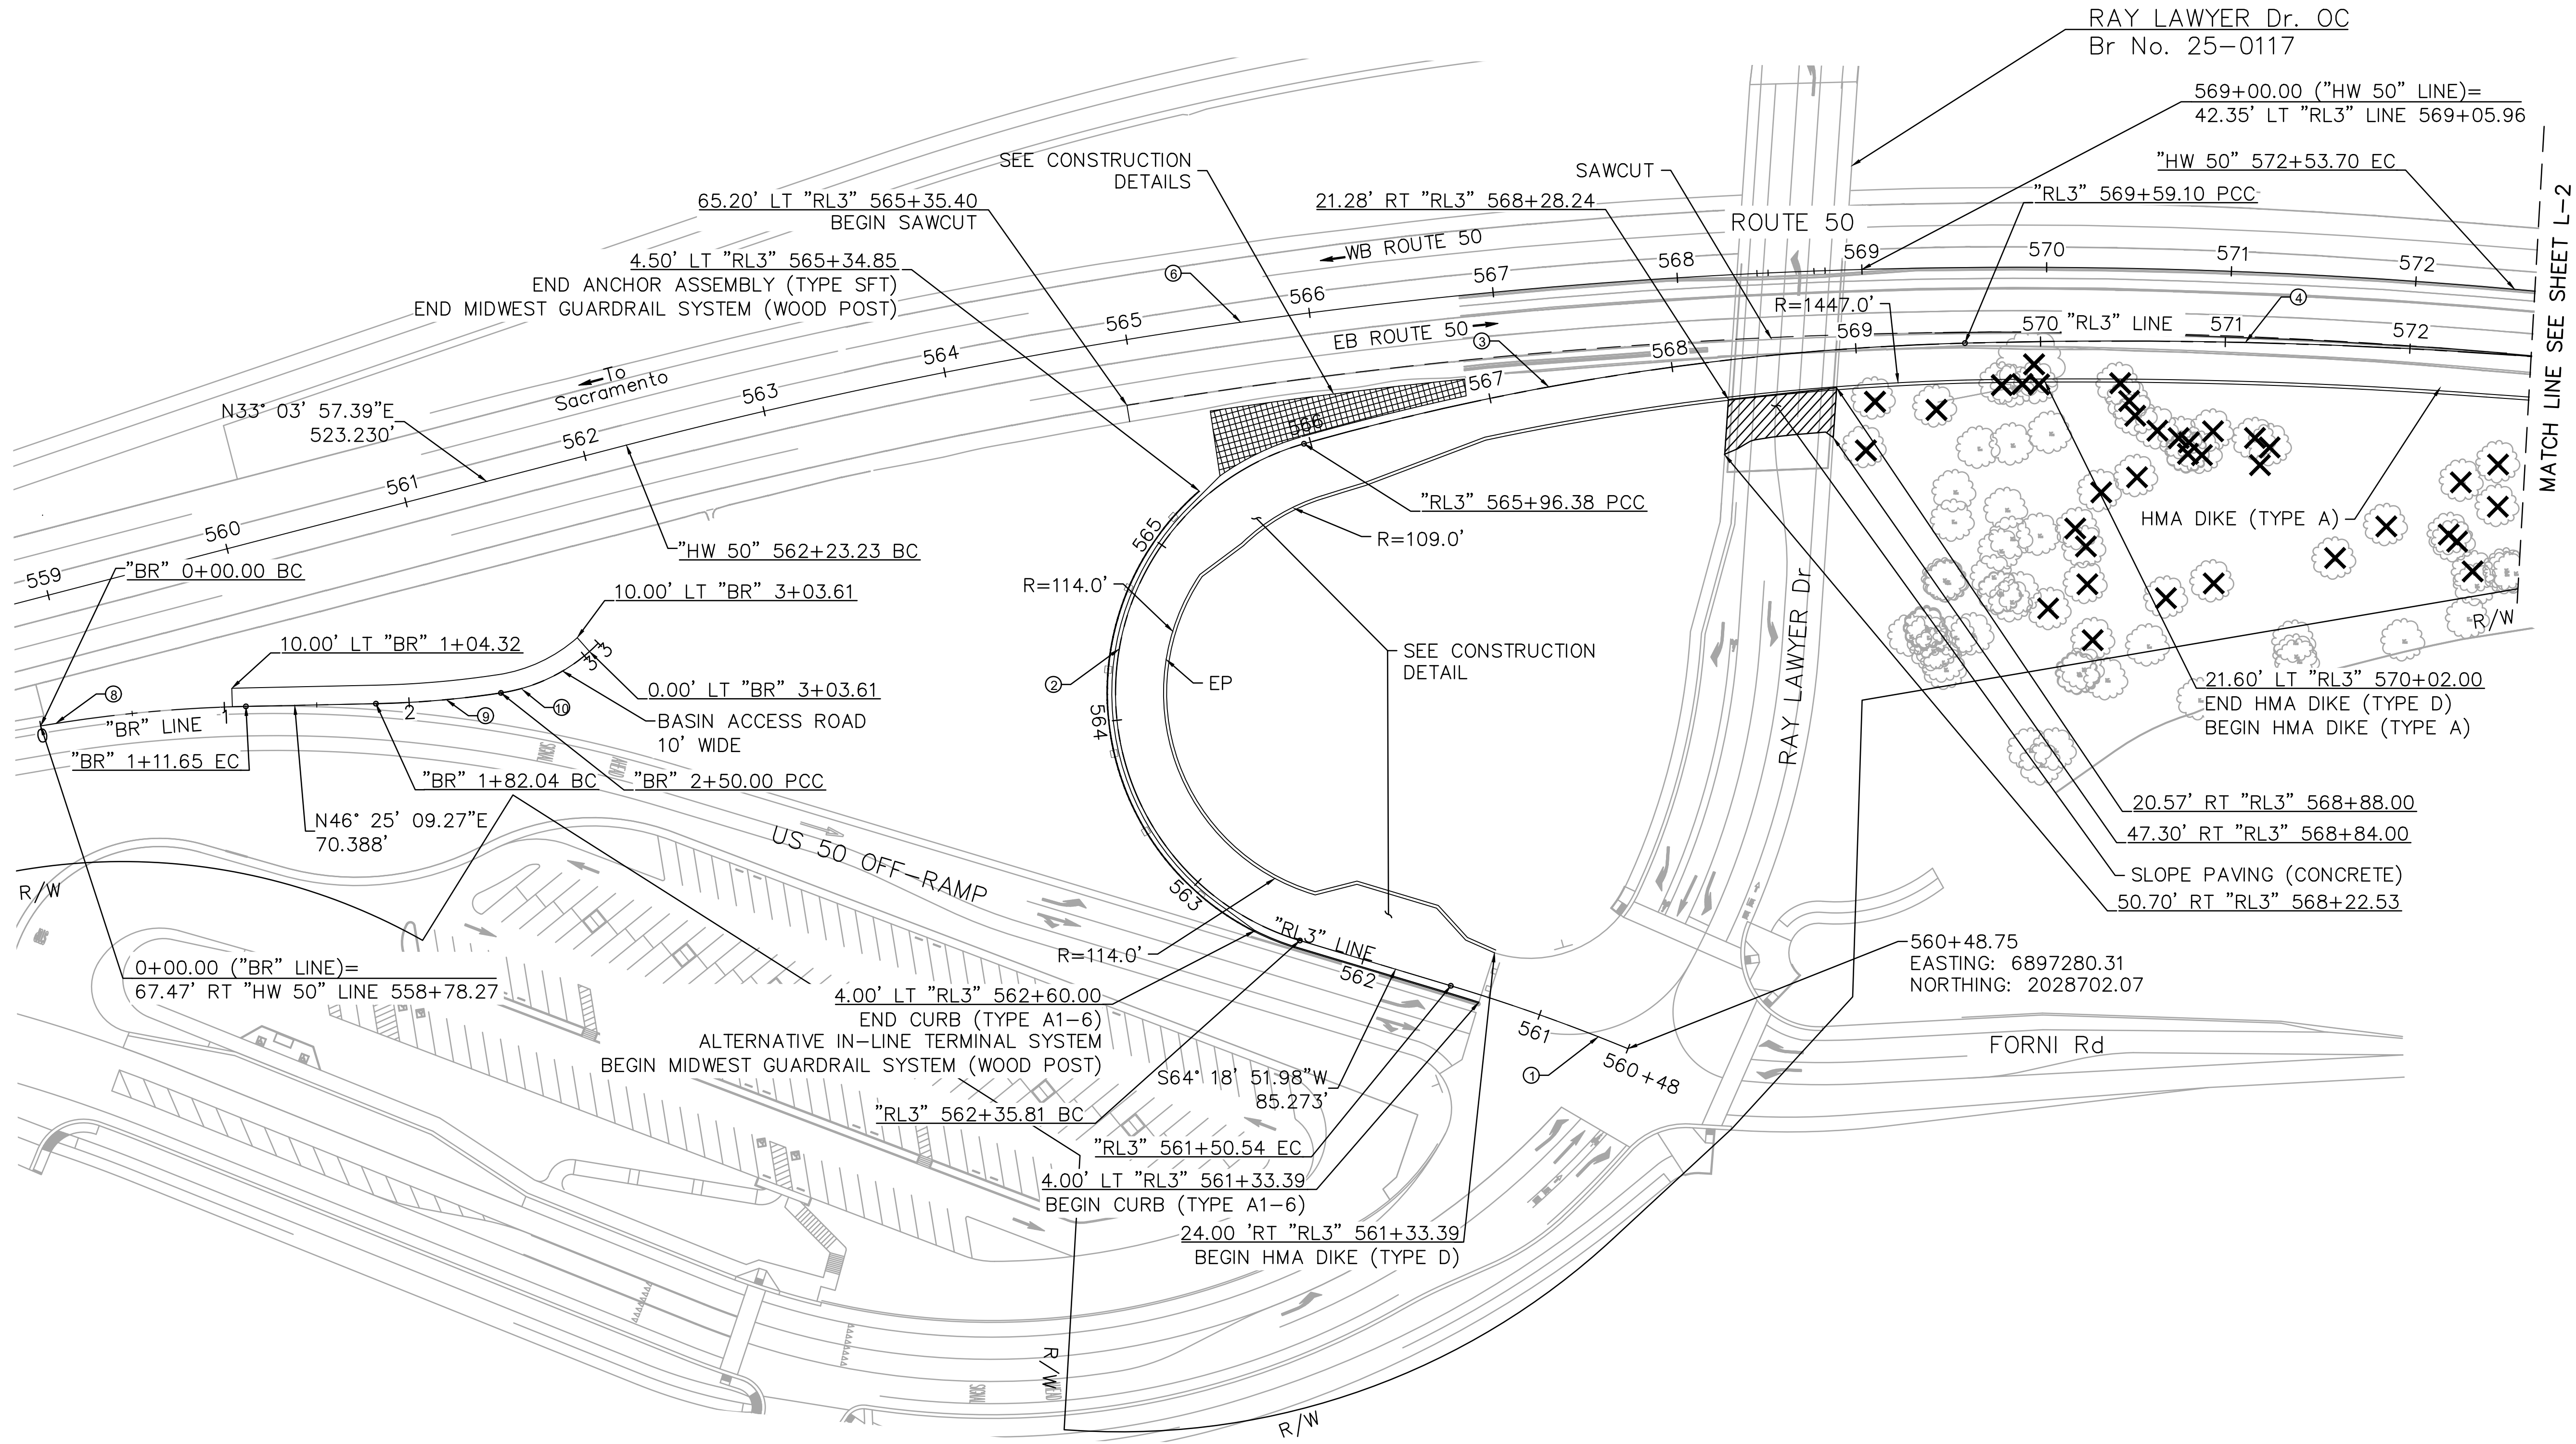

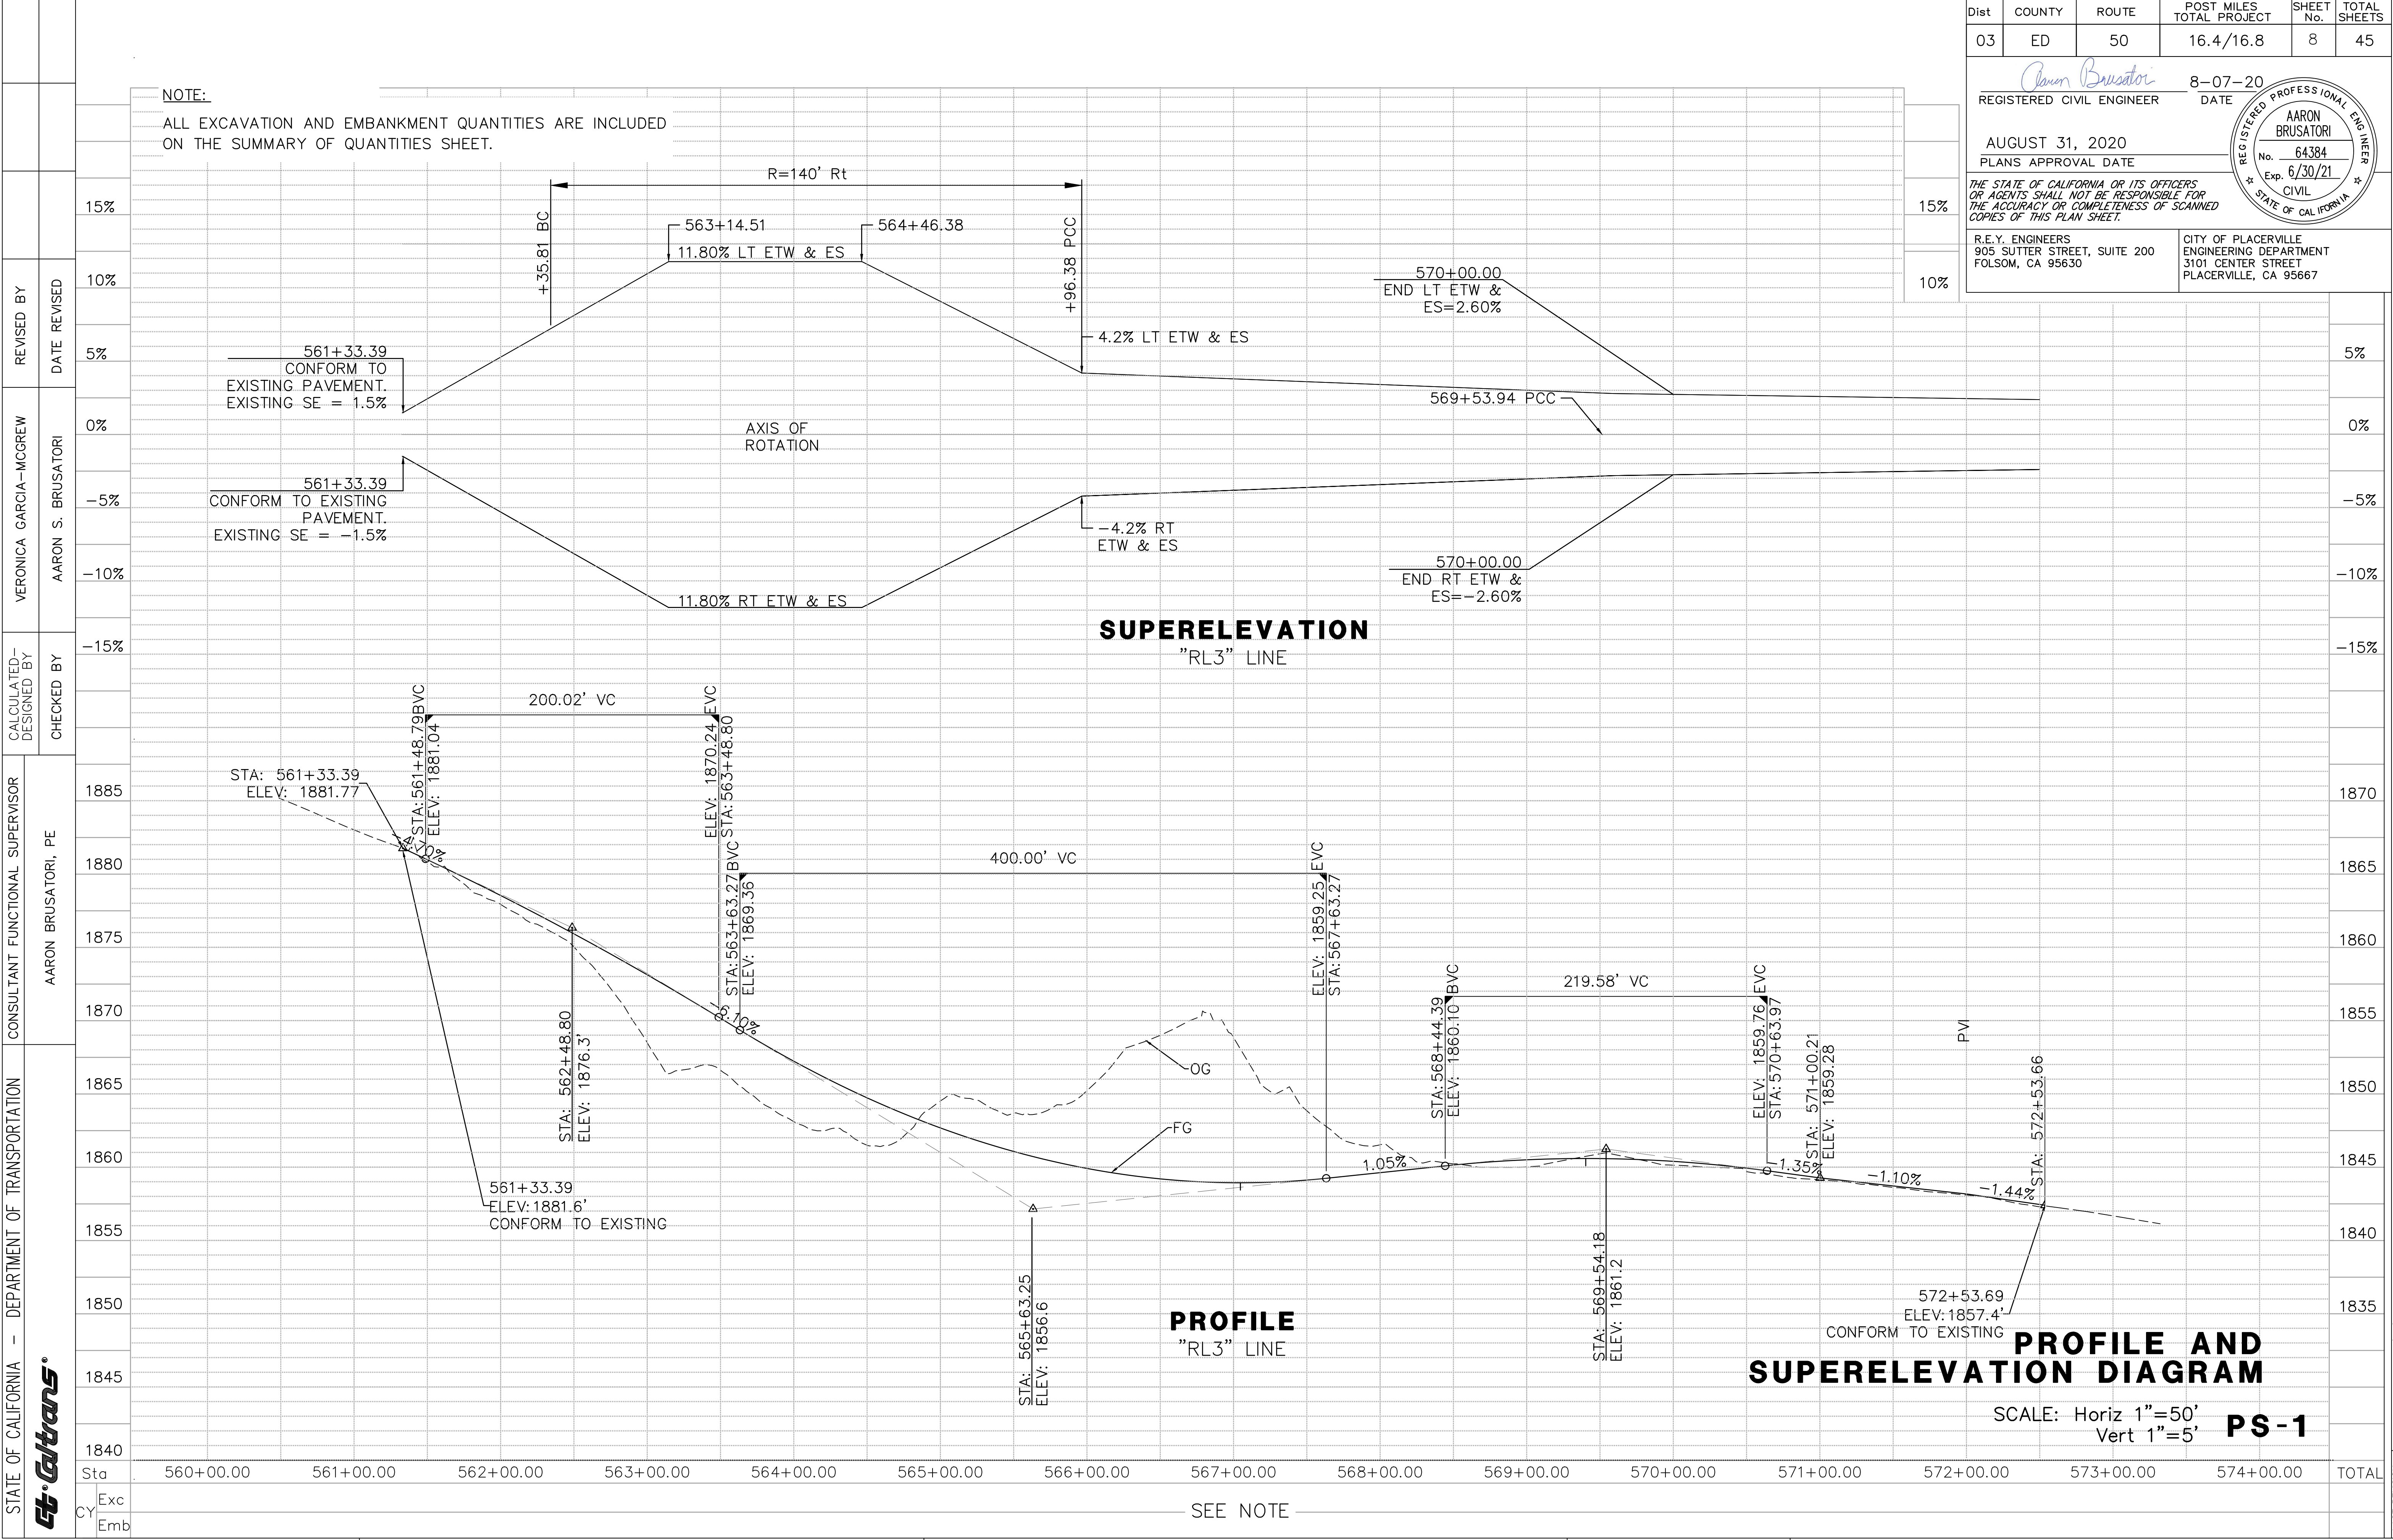

STATE OF CALIFORNIA

Caltrans

DEPARTMENT OF TRANSPORTATION

CONSULTANT FUNCTIONAL SUPERVISOR

AARON BRUSATORI, PE

CALCULATED—
DESIGNED BY

CHECKED BY

VERONICA GARCIA—MCGREW

AARON S. BRUSATORI

REVISED BY

DATE REVISED

Dist	COUNTY	ROUTE	POST MILES TOTAL PROJECT	SHEET No.	TOTAL SHEETS
03	ED	50	16.4/16.8	7	45

Aaron Brusatori

REGISTERED CIVIL ENGINEER

8-07-20
DATE

AUGUST 31, 2020
PLANS APPROVAL DATE

THE STATE OF CALIFORNIA OR ITS OFFICERS
OR AGENTS SHALL NOT BE RESPONSIBLE FOR
THE ACCURACY OR COMPLETENESS OF SCANNED
COPIES OF THIS PLAN SHEET.

R.E.Y. ENGINEERS
905 SUTTER STREET, SUITE 200
FOLSOM, CA 95630

CITY OF PLACERVILLE
ENGINEERING DEPARTMENT
3101 CENTER STREET
PLACERVILLE, CA 95667

REGISTERED PROFESSIONAL ENGINEER
AARON BRUSATORI
No. 64384
Exp. 6/30/21
CIVIL
STATE OF CALIFORNIA

CURVE TABLE				
CURVE	RADIUS	DELTA	TANGENT	LENGTH
⑥	1215.00	43°22'19"	483.16	919.73
⑦	1232.38	43°53'24"	496.54	944.04

The diagram illustrates the plan view of Route 50, showing the alignment and proposed HMA dike locations. Key features include:

- Route 50 Alignment:** Shown with stationing from 573 to 582. The alignment is labeled "ROUTE 50" and "WB ROUTE 50" / "EB ROUTE 50".
- HMA Dike Locations:** Indicated by 'X' marks and labels: "HMA DIKE (TYPE D)" and "HMA DIKE (TYPE A)".
- Curve Data:** Stationing points for curve tangency and beginning/end points are provided, such as "RL3" 573+10.22 EC, "RL3" 578+53.66, and "RL3" 579+97.12 BC.
- Other Features:** Labels for "SAWCUT", "EP" (End Point), and "R/W" (Right of Way) are included.
- Directional Indicators:** Arrows point towards "Placerville" and "To Placerville".

BORDER LAST REVISED 7/2/2010

USERNAME => VGMCGREW
CAD FILE => 6884.009 LAYOUTS.DWG

RELATIVE BORDER SCALE
IS IN INCHES

0 1 2 3

UNIT

PROJECT NUMBER & PHASE

03190001521

SCALE: 1" = 50'

LAYOUT
L-2

DATE PLOTTED => 10/4/2020
TIME PLOTTED => 11:28 AM

STATE OF CALIFORNIA

Caltrans

DEPARTMENT OF TRANSPORTATION

CONSULTANT FUNCTIONAL SUPERVISOR

VERONICA GARCIA-MCGREW

AARON BRUSATORI, PE

REVISOR

DATE

DESIGNED BY

CHECKED BY

VERONICA GARCIA-MCGREW

AARON S. BRUSATORI

REVISOR

DATE

EB ROUTE 50

ETW

ETW / "RL3"

ETW

ON-RAMP

PLAN

50'

23'

HMA (TEXTURED PAVING)
SEE STAMP PATTERN BELOW.
FEDERAL STANDARD 595B, COLOR #30166

HMA (TEXTURED PAVING)
SEE STAMP PATTERN BELOW.
FEDERAL STANDARD 595B,
COLOR #30166

0.08'

0.50' HMA (TYPE A)
1.45' CL 2 AB

TYPICAL GORE PAVING--SECTION

0.396'

0.803'

TYPICAL GORE PAVING STAMP PATTERN

GORE AREA PAVING DETAILS

LEGEND:

CONTRASTING SURFACE TREATMENT

HMA (TEXTURED PAVING)

Dist	COUNTY	ROUTE	POST MILES TOTAL PROJECT	SHEET No.	TOTAL SHEETS
03	ED	50	16.4/16.8	9	45
REGISTERED CIVIL ENGINEER			8-07-20 DATE		
AUGUST 31, 2020 PLANS APPROVAL DATE			AARON BRUSATORI No. 64384 Exp. 6/30/21 CIVIL STATE OF CALIFORNIA		
THE STATE OF CALIFORNIA OR ITS OFFICERS OR AGENTS SHALL NOT BE RESPONSIBLE FOR THE ACCURACY OR COMPLETENESS OF SCANNED COPIES OF THIS PLAN SHEET.					
R.E.Y. ENGINEERS 905 SUTTER STREET, SUITE 200 FOLSOM, CA 95630			CITY OF PLACERVILLE ENGINEERING DEPARTMENT 3101 CENTER STREET PLACERVILLE, CA 95667		

EDGE DETAIL

CONSTRUCTION DETAILS

NO SCALE

C-1

BORDER LAST REVISED 7/2/2010

USERNAME => VGMCGREW
CAD FILE => 6884.009 CONSTRUCTION DETAILS.DWG

RELATIVE BORDER SCALE
IS IN INCHES

0 1 2 3

UNIT

PROJECT NUMBER & PHASE

03190001521

DATE PLOTTED => 10/4/2020
TIME PLOTTED => 11:29 AM

STATE OF CALIFORNIA	DEPARTMENT OF TRANSPORTATION	CONSULTANT FUNCTIONAL SUPERVISOR	CALCULATED— DESIGNED BY	VERONICA GARCIA—MCGREW	REVISED BY	
Caltrans		AARON BRUSATORI, PE	CHECKED BY	AARON S. BRUSATORI	DATE REVISED	

Dist	COUNTY	ROUTE	POST MILES TOTAL PROJECT	SHEET No.	TOTAL SHEETS
03	ED	50	16.4/16.8	10	45

Aaron Brusatori

REGISTERED CIVIL ENGINEER

8-07-20
DATE

AUGUST 31, 2020


PLANS APPROVAL DATE

THE STATE OF CALIFORNIA OR ITS OFFICERS
OR AGENTS SHALL NOT BE RESPONSIBLE FOR
THE ACCURACY OR COMPLETENESS OF SCANNED
COPIES OF THIS PLAN SHEET.

R.E.Y. ENGINEERS
905 SUTTER STREET, SUITE 200
FOLSOM, CA 95630

REGISTERED PROFESSIONAL ENGINEER
AARON
BRUSATORI
No. 64384
Exp. 6/30/21
CIVIL
STATE OF CALIFORNIA

CITY OF PLACERVILLE
ENGINEERING DEPARTMENT
3101 CENTER STREET
PLACERVILLE, CA 95667

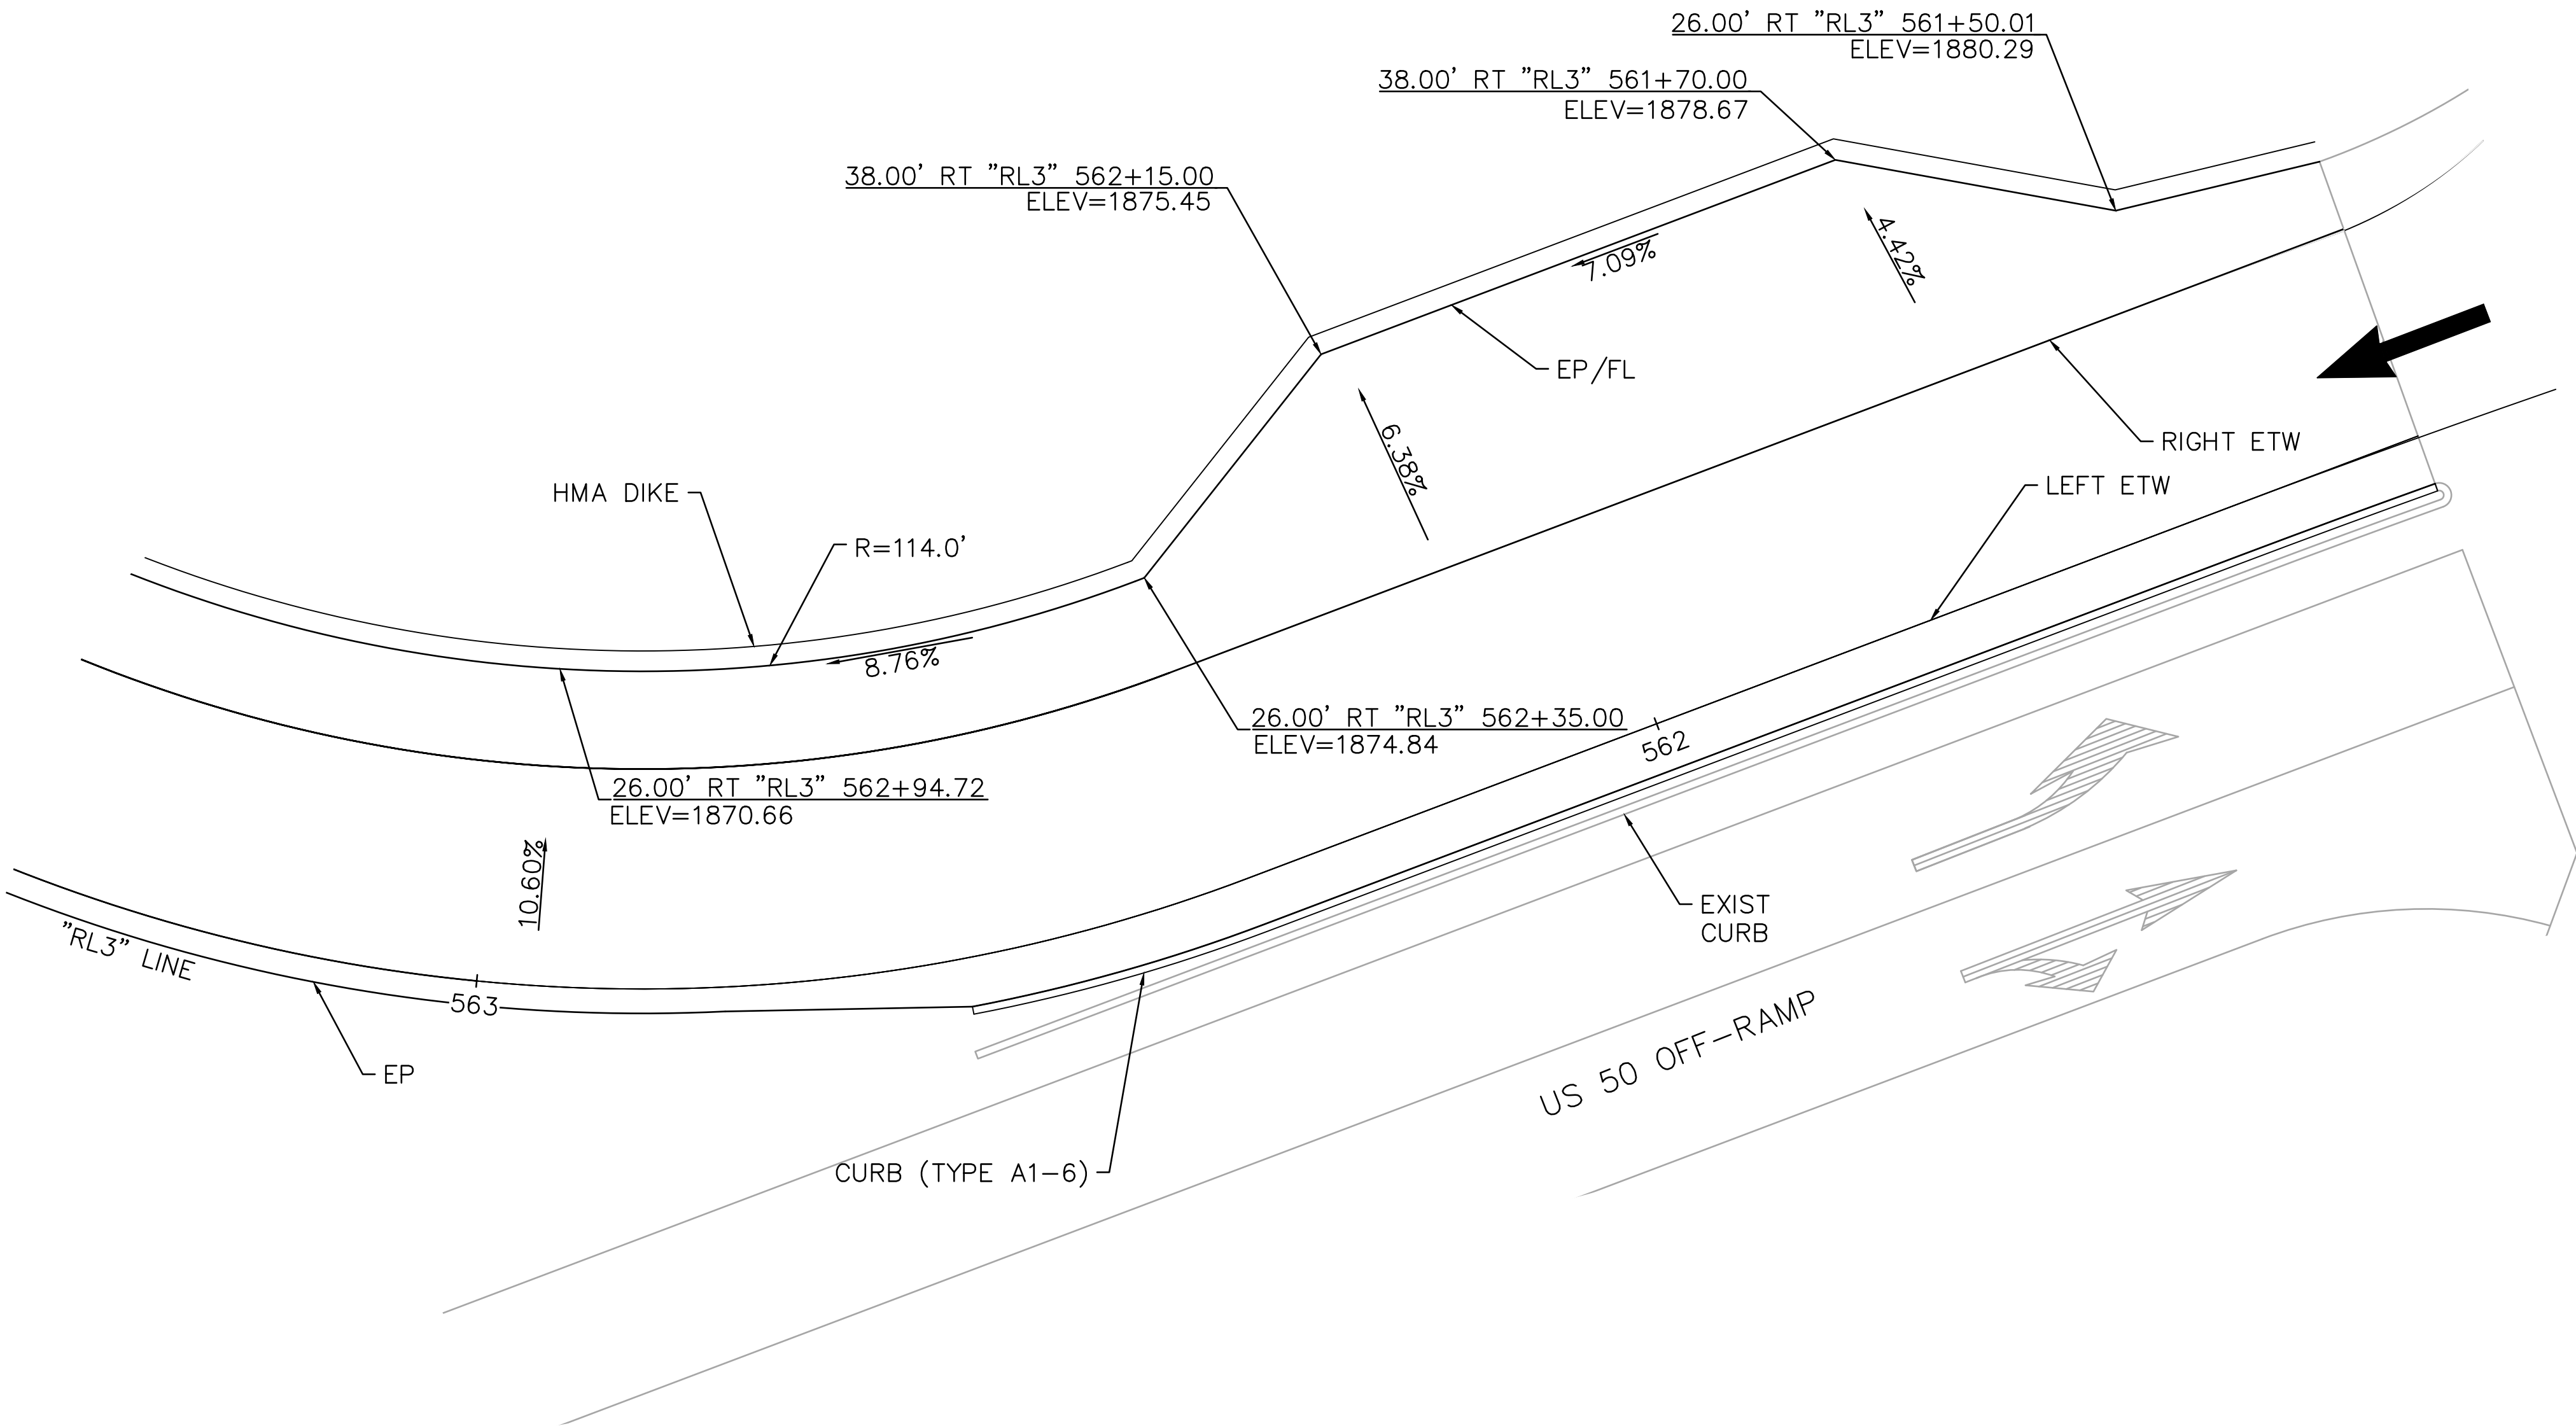

MVP AREA DETAILS

CONSTRUCTION DETAILS
SCALE: 1" = 10'
C-2

STATE OF CALIFORNIA

DEPARTMENT OF TRANSPORTATION

Caltrans

CONSULTANT FUNCTIONAL SUPERVISOR

AARON BRUSATORI, PE

DESIGNED BY

CHECKED BY

VERONICA GARCIA-MCGREW

AARON S. BRUSATORI

REVISED BY

DATE REVISED

Dist	COUNTY	ROUTE	POST MILES TOTAL PROJECT	SHEET No.	TOTAL SHEETS
03	ED	50	16.4/16.8	11	45

Aaron Brusatori

REGISTERED CIVIL ENGINEER

8-07-20

DATE

AUGUST 31, 2020

PLANS APPROVAL DATE

THE STATE OF CALIFORNIA OR ITS OFFICERS
OR AGENTS SHALL NOT BE RESPONSIBLE FOR
THE ACCURACY OR COMPLETENESS OF SCANNED
COPIES OF THIS PLAN SHEET.

R.E.Y. ENGINEERS
905 SUTTER STREET, SUITE 200
FOLSOM, CA 95630

CITY OF PLACERVILLE
ENGINEERING DEPARTMENT
3101 CENTER STREET
PLACERVILLE, CA 95667

PROFESSIONAL ENGINEER

AARON BRUSATORI

No. 64384

Exp. 6/30/21

CIVIL

STATE OF CALIFORNIA

45.70' LT "RL3" 565+63.90
ELEV=1855.97

43.10' LT "RL3" 565+51.78
FL ELEV=1855.00

36.38' LT "RL3" 565+61.06
ELEV=1855.82

35.19' LT "RL3" 565+68.74
FL ELEV=1856.00

4.00' LT "RL3" 565+48.31
ELEV=1861.39

2.00' LT "RL3" 565+24.47

26.76' LT "RL3" 566+03.82
FL ELEV=1857.00

19.50' LT "RL3" 566+59.63
FL ELEV=1858.00

13.08' LT "RL3" 566+88.73
ELEV=1858.58

9.98' LT "RL3" 567+27.98
ELEV=1859.00

4.00' LT "RL3" 566+87.65
ELEV=1859.11

29.72' RT "RL3" 565+97.98
ELEV=1858.51

31.89' RT "RL3" 565+33.46
ELEV=1859.14

26.00' RT "RL3" 564+98.48
ELEV=1860.36

28.89' RT "RL3" 566+22.78
ELEV=1858.21

22.58' RT "RL3" 566+75.00
ELEV=1857.86
LOW POINT

20.00' RT "RL3" 566+92.86
ELEV=1858.00

4.06%

1.23%

1.25%

0.69%

0.82%

R=109.0'

EP

565

566

567

LIMIT LINE STRIPE

LEFT ETW

RIGHT ETW

EP/FL

HMA DIKE

EB ROUTE 50

ROUTE 50

GORE AREA

DIRECTION OF TRAFFIC

CHP ENFORCEMENT AREA AND GORE AREA DETAILS

CONSTRUCTION DETAILS

SCALE: 1" = 10'

C-3

BORDER LAST REVISED 7/2/2010

USERNAME => VGMCGREW
CAD FILE => 6884.009 CONSTRUCTION DETAILS.DWG

RELATIVE BORDER SCALE
IS IN INCHES

0 1 2 3

UNIT

PROJECT NUMBER & PHASE

03190001521


DATE PLOTTED => 10/4/2020
TIME PLOTTED => 11:29 AM

STATE OF CALIFORNIA - DEPARTMENT OF TRANSPORTATION	CONSULTANT FUNCTIONAL SUPERVISOR	CALCULATED-DESIGNED BY	VERONICA GARCIA-MCGREW	REVISED BY	
GTCalttrans	AARON BRUSATORI, PE	CHECKED BY	AARON S. BRUSATORI	DATE REVISED	

NOTE:

1. FOR ACCURATE RIGHT OF WAY DATA, CONTACT RIGHT OF WAY ENGINEERING AT THE DISTRICT OFFICE.

 LEGEND:



TEMPORARY HYDRAULIC MULCH




TEMPORARY CONSTRUCTION ENTRANCE



TEMPORARY DRAINAGE INLET PROTECTION

F...F/C.....C GRADING LIMITS

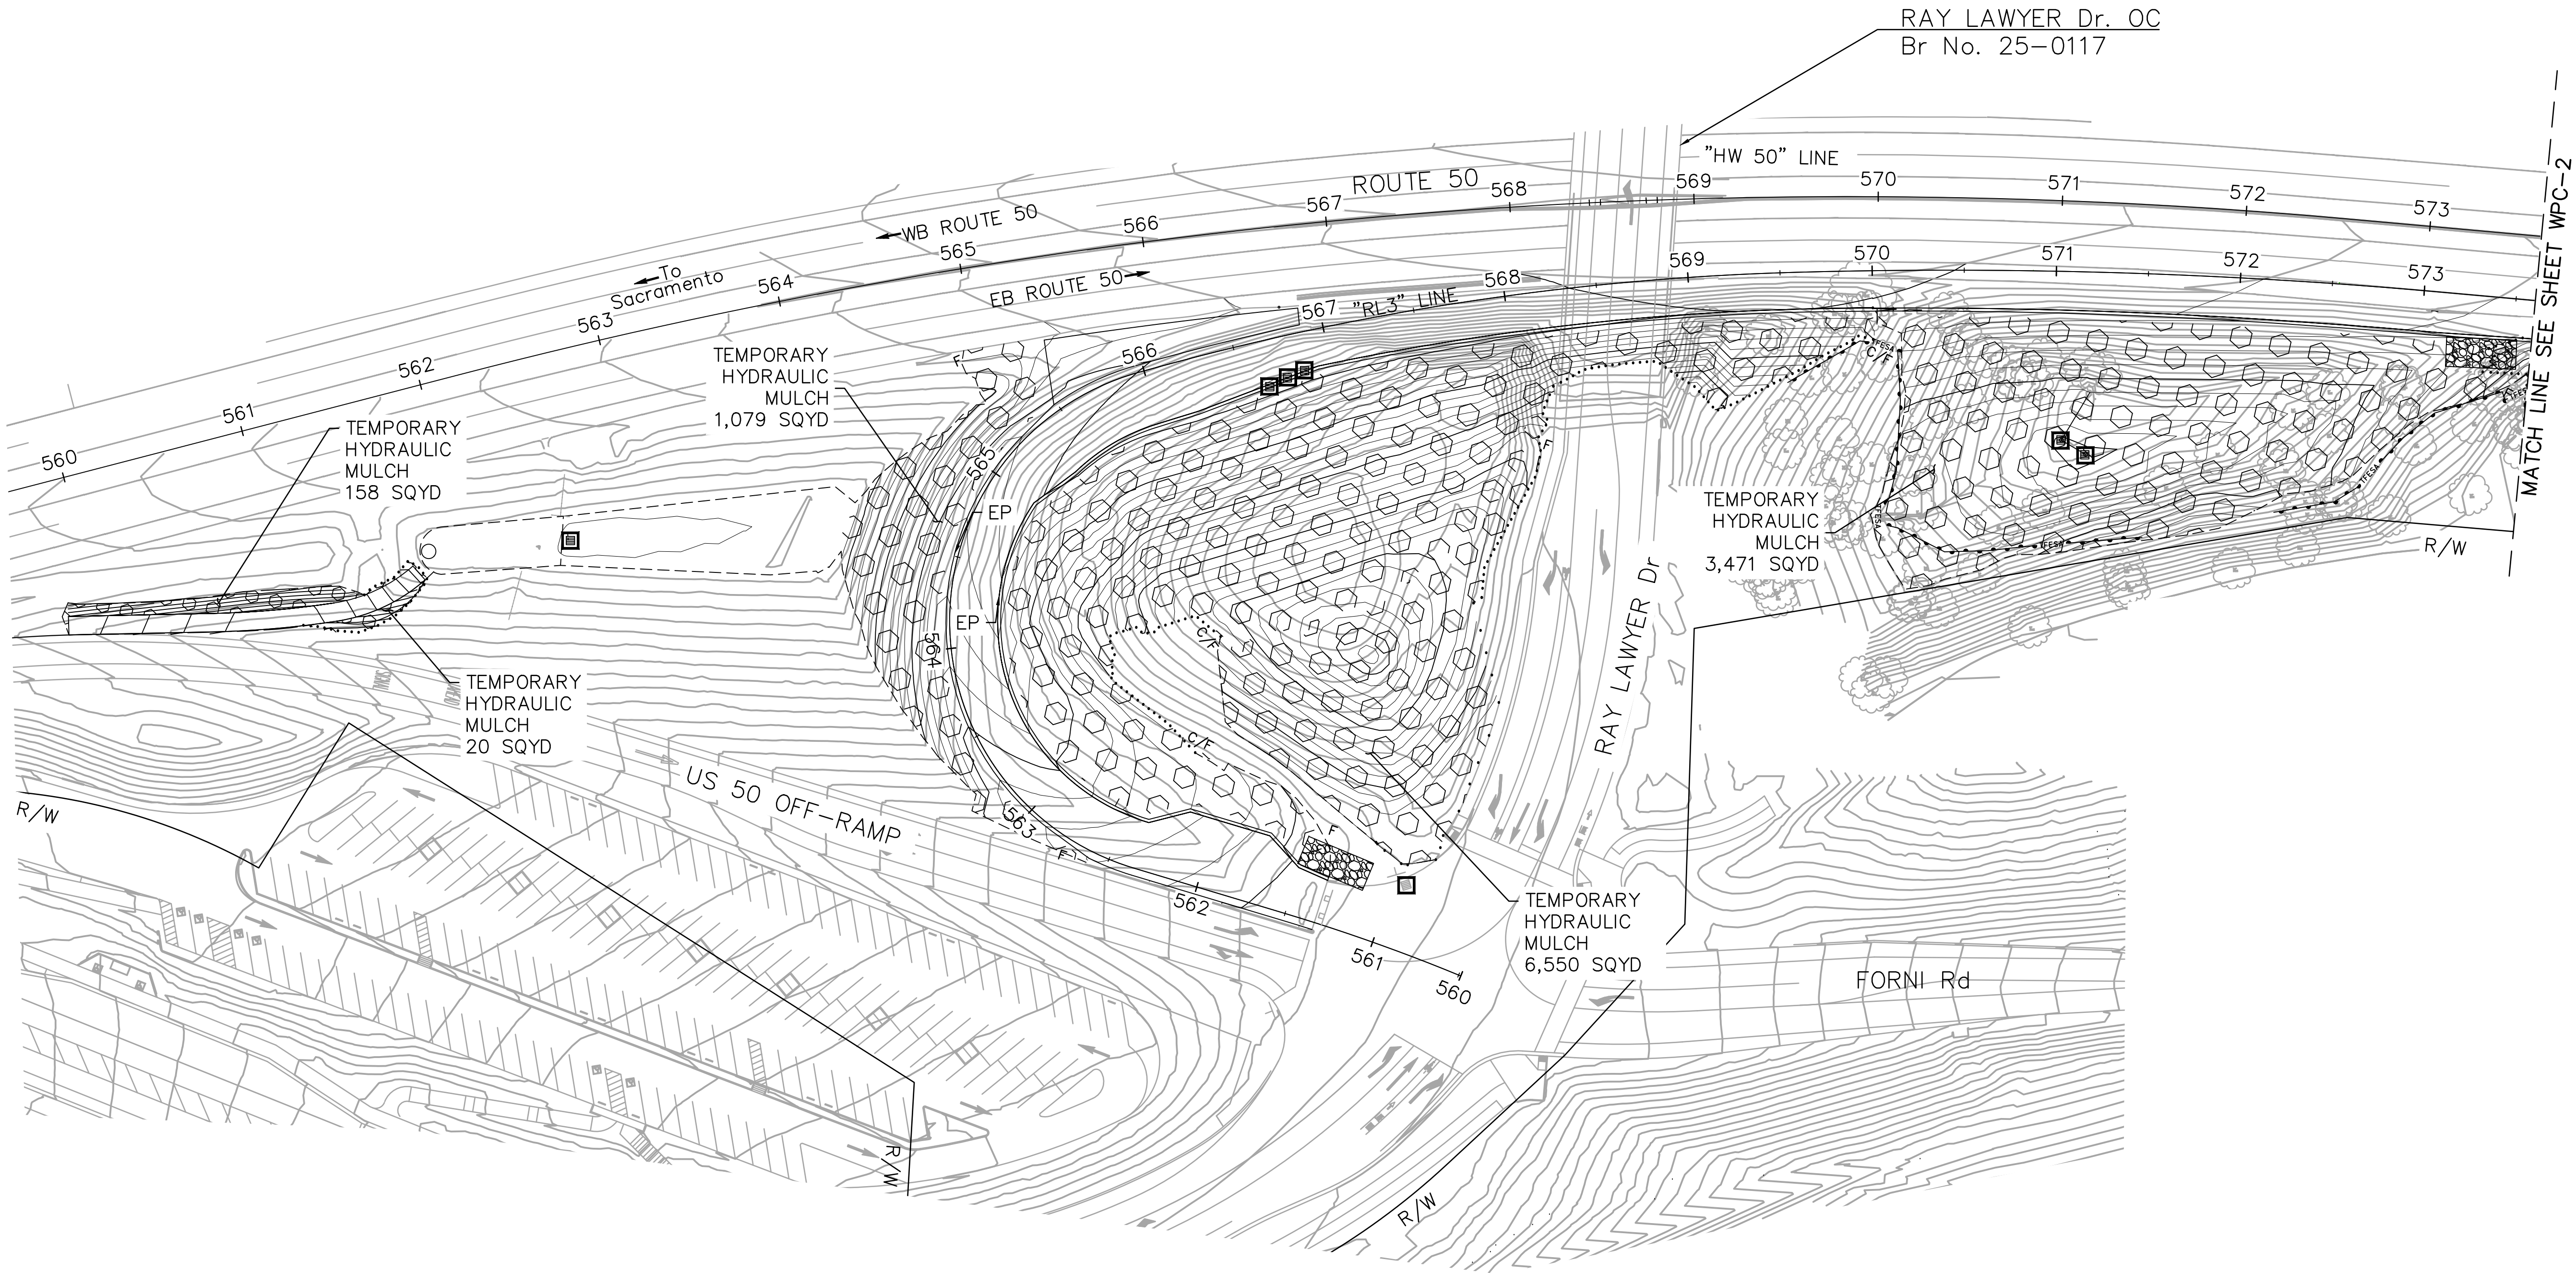

APPROVED FOR WATER POLLUTION CONTROL WORK ONLY

WATER POLLUTION CONTROL PLAN

SCALE: 1"=50'

WPC-1

Dist	COUNTY	ROUTE	POST MILES TOTAL PROJECT	SHEET No.	TOTAL SHEETS
03	ED	50	16.4/16.8	12	45
AARON BRUSATORI REGISTERED CIVIL ENGINEER			8-07-20 DATE		
AUGUST 31, 2020 PLANS APPROVAL DATE					
THE STATE OF CALIFORNIA OR ITS OFFICERS OR AGENTS SHALL NOT BE RESPONSIBLE FOR THE ACCURACY OR COMPLETENESS OF SCANNED COPIES OF THIS PLAN SHEET.					
R.E.Y. ENGINEERS 905 SUTTER STREET, SUITE 200 FOLSOM, CA 95630			CITY OF PLACERVILLE ENGINEERING DEPARTMENT 3101 CENTER STREET PLACERVILLE, CA 95667		

REGISTERED PROFESSIONAL ENGINEER

AARON BRUSATORI

No. 64384

Exp. 6/30/21



CIVIL

STATE OF CALIFORNIA

STATE OF CALIFORNIA - DEPARTMENT OF TRANSPORTATION	CALTRANS	CONSULTANT FUNCTIONAL SUPERVISOR	AARON BRUSATORI, PE	CALCULATED-DESIGNED BY	VERONICA GARCIA-MCGREW	REVISED BY	
		CHECKED BY	AARON S. BRUSATORI	DATE REVISED			

NOTE:

1. FOR ACCURATE RIGHT OF WAY DATA, CONTACT RIGHT OF WAY ENGINEERING AT THE DISTRICT OFFICE.

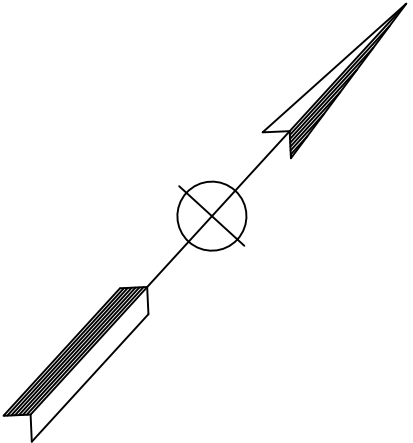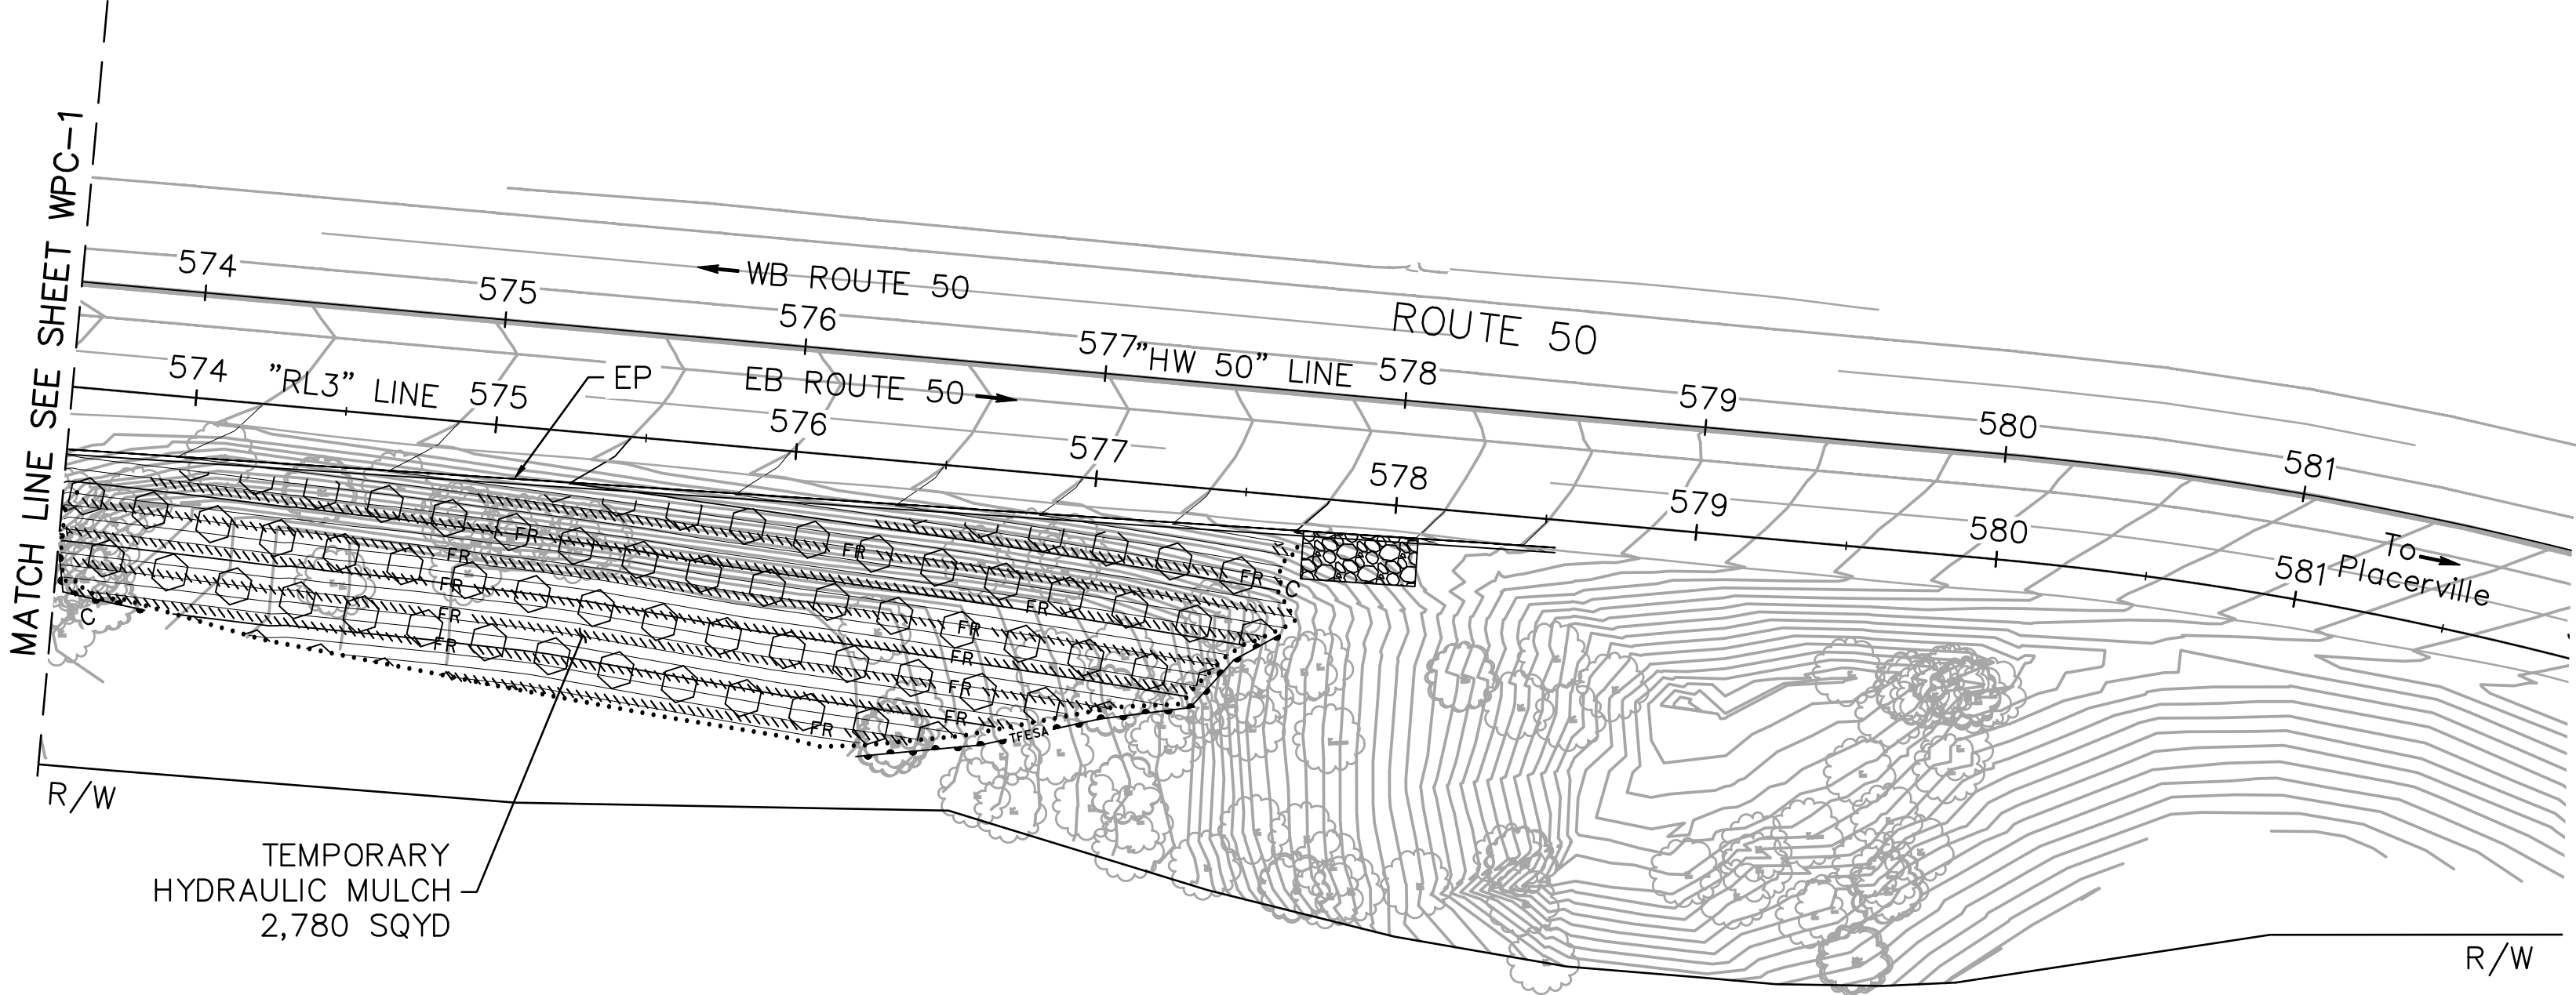

Dist	COUNTY	ROUTE	POST MILES TOTAL PROJECT	SHEET No.	TOTAL SHEETS
03	ED	50	16.4/16.8	13	45

Aaron Brusatori
REGISTERED CIVIL ENGINEER

8-07-20
DATE

AUGUST 31, 2020
PLANS APPROVAL DATE

REGISTERED PROFESSIONAL ENGINEER
AARON BRUSATORI
No. 64384
Exp. 6/30/21
CIVIL
STATE OF CALIFORNIA

THE STATE OF CALIFORNIA OR ITS OFFICERS
OR AGENTS SHALL NOT BE RESPONSIBLE FOR
THE ACCURACY OR COMPLETENESS OF SCANNED
COPIES OF THIS PLAN SHEET.

R.E.Y. ENGINEERS
905 SUTTER STREET, SUITE 200
FOLSOM, CA 95630

CITY OF PLACERVILLE
ENGINEERING DEPARTMENT
3101 CENTER STREET
PLACERVILLE, CA 95667

APPROVED FOR WATER POLLUTION CONTROL WORK ONLY

WATER POLLUTION CONTROL PLAN
WPC-2

SCALE: 1"=50'

STATE OF CALIFORNIA - DEPARTMENT OF TRANSPORTATION

Caltrans

CONSULTANT FUNCTIONAL SUPERVISOR

AARON BRUSATORI, PE

CHECKED BY

AARON S. BRUSATORI

VERONICA GARCIA-MCGREW

REVISED BY

DATE REVISED

NOTE:

1. FOR ACCURATE RIGHT OF WAY DATA, CONTACT RIGHT OF WAY ENGINEERING AT THE DISTRICT OFFICE.

LEGEND:

EROSION CONTROL (TYPE 1)
CUT AND FILL SLOPES

FIBER ROLL (STANDARD PLAN H51)

GRADING LIMITS

Dist	COUNTY	ROUTE	POST MILES TOTAL PROJECT	SHEET No.	TOTAL SHEETS
03	ED	50	16.4/16.8	14	45

Aaron Brusatori

REGISTERED CIVIL ENGINEER

8-07-20
DATE

AUGUST 31, 2020

PLANS APPROVAL DATE

THE STATE OF CALIFORNIA OR ITS OFFICERS
OR AGENTS SHALL NOT BE RESPONSIBLE FOR
THE ACCURACY OR COMPLETENESS OF SCANNED
COPIES OF THIS PLAN SHEET.

R.E.Y. ENGINEERS
905 SUTTER STREET, SUITE 200
FOLSOM, CA 95630

CITY OF PLACERVILLE
ENGINEERING DEPARTMENT
3101 CENTER STREET
PLACERVILLE, CA 95667

REGISTERED PROFESSIONAL ENGINEER

AARON BRUSATORI

No. 64384

Exp. 6/30/21

CIVIL

STATE OF CALIFORNIA

The plan shows a section of Route 50 with an off-ramp and adjacent properties. Key features include:

- Route 50**: Labeled with stationing from 560 to 573. Includes "WB ROUTE 50" and "EB ROUTE 50" directions.
- US 50 OFF-RAMP**: A ramp structure shown with its right-of-way (R/W) boundary.
- RAY LAWYER Dr.**: A property boundary running parallel to the route.
- Forni Rd**: A road located south of Ray Lawyer Dr.
- Erosion Control Measures**:
 - EC (TYPE 1) 1,419 SQFT
 - EC (TYPE 1) 10,865 SQFT
 - EC (TYPE 1) 172 SQFT
 - EC (TYPE 1) 31,756 SQFT
 - EC (TYPE 1) 62,164 SQFT
- Fiber Roll**: 767 LF and 4,873 LF.
- Fill Slope**: Indicated on several areas.
- Cut Slope**: Indicated on the central embankment.
- Right-of-Way (R/W)**: Multiple boundaries are marked with dashed lines.
- Match Line**: "MATCH LINE SEE SHEET EC-2" is shown on the right side.
- North Arrow**: Located in the upper right corner.

APPROVED FOR EROSION CONTROL WORK ONLY

EROSION CONTROL PLAN
EC-1

SCALE: 1"=50'

BORDER LAST REVISED 7/2/2010

USERNAME => VGMCGREW
CAD FILE => 6884.009 EROSION CONTROL.DWG

RELATIVE BORDER SCALE
IS IN INCHES

0 1 2 3

UNIT

PROJECT NUMBER & PHASE


03190001521

DATE PLOTTED => 10/4/2020
TIME PLOTTED => 12:06 PM

STATE OF CALIFORNIA DEPARTMENT OF TRANSPORTATION Caltrans	CONSULTANT FUNCTIONAL SUPERVISOR AARON BRUSATORI, PE	CALCULATED— DESIGNED BY CHECKED BY	VERONICA GARCIA—MCGREW AARON S. BRUSATORI	REVISED BY DATE REVISED				

NOTE:

1. FOR ACCURATE RIGHT OF WAY DATA, CONTACT RIGHT OF WAY ENGINEERING AT THE DISTRICT OFFICE.

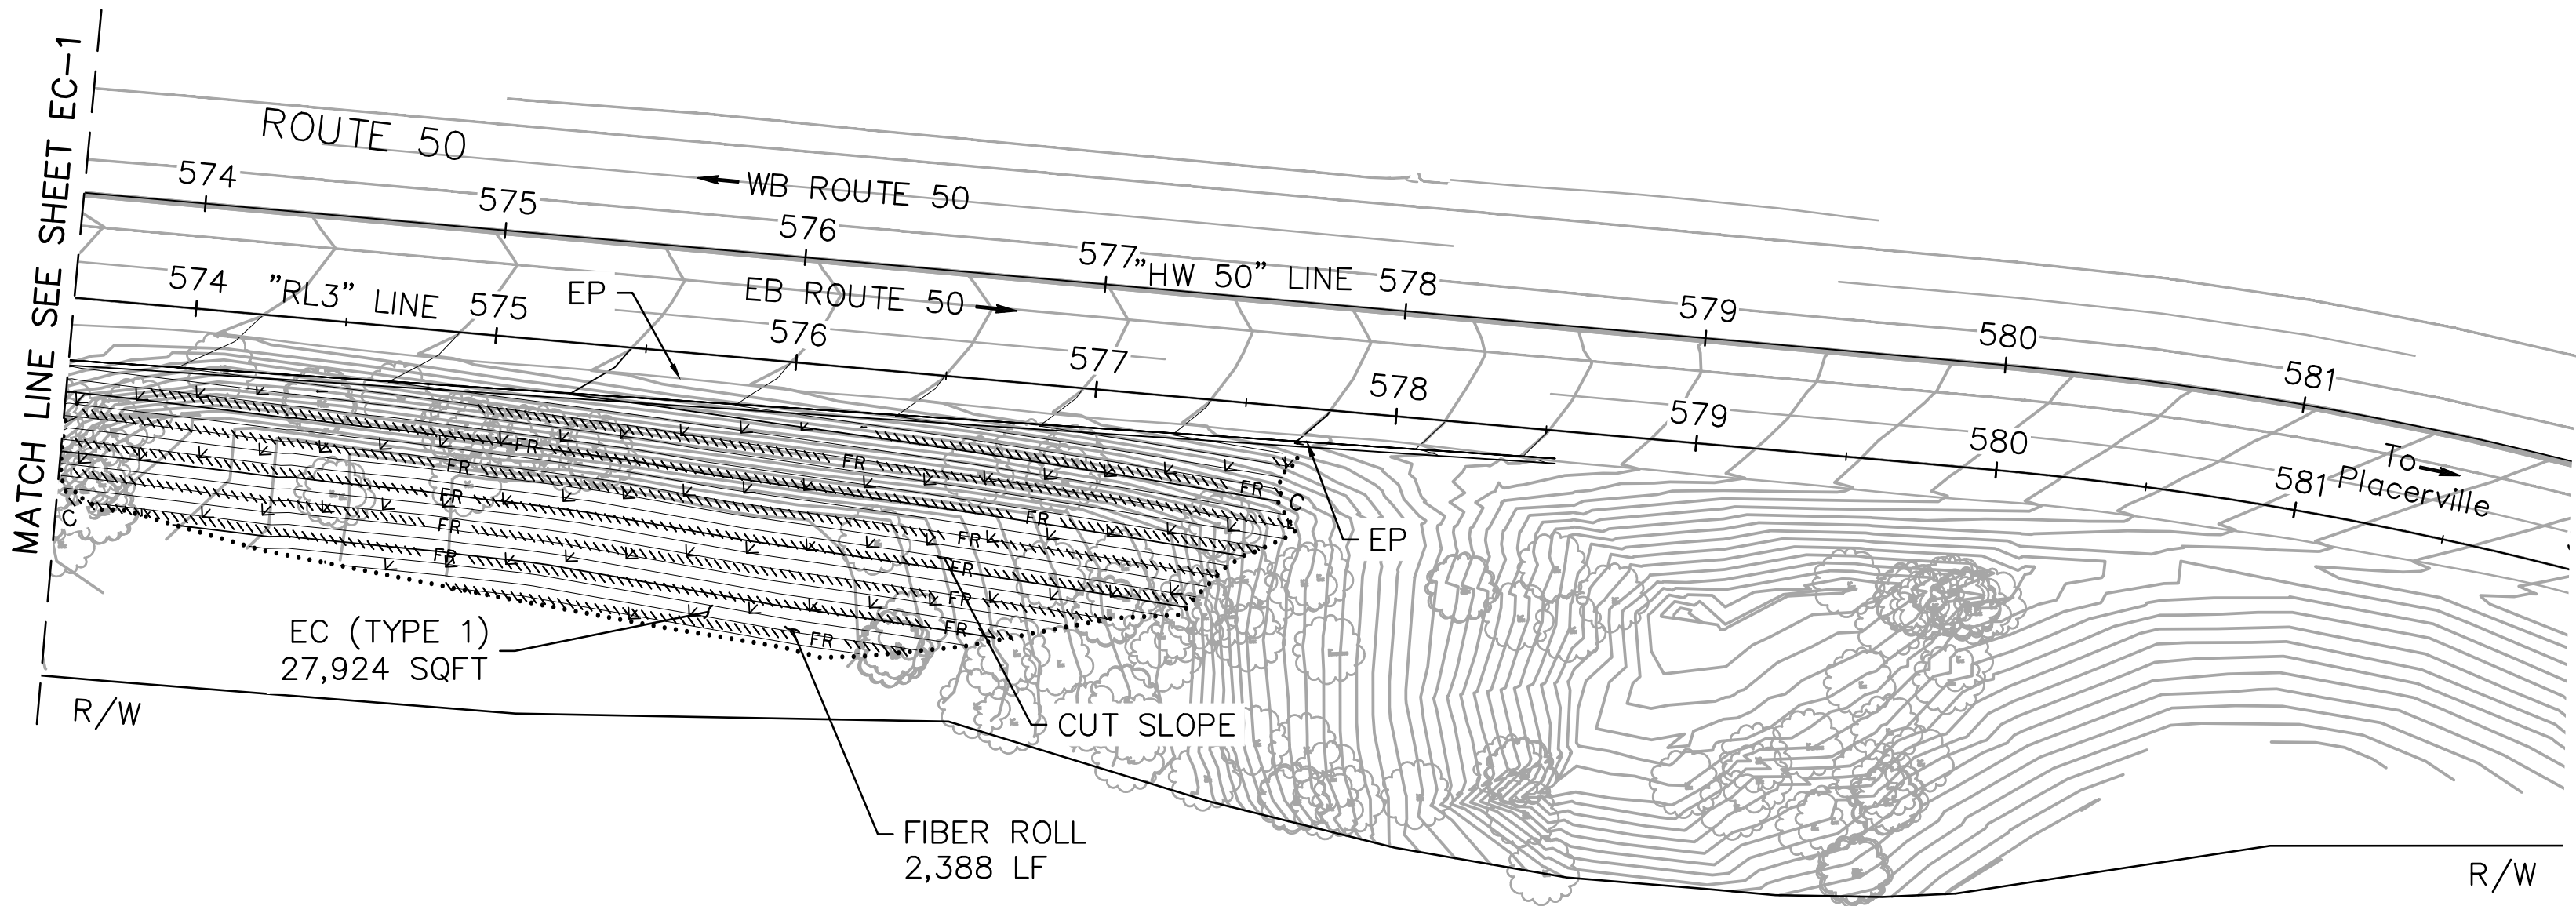

APPROVED FOR EROSION CONTROL WORK ONLY

EROSION CONTROL PLAN
EC-2

SCALE: 1"=50'

Dist	COUNTY	ROUTE	POST MILES TOTAL PROJECT	SHEET No.	TOTAL SHEETS
03	ED	50	16.4/16.8	15	45
REGISTERED CIVIL ENGINEER			8-07-20 DATE		
AUGUST 31, 2020			PLANS APPROVAL DATE		
R.E.Y. ENGINEERS 905 SUTTER STREET, SUITE 200 FOLSOM, CA 95630			CITY OF PLACERVILLE ENGINEERING DEPARTMENT 3101 CENTER STREET PLACERVILLE, CA 95667		

Aaron Brusatori

REGISTERED PROFESSIONAL ENGINEER

AARON BRUSATORI

No. 64384

Exp. 6/30/21

CIVIL

STATE OF CALIFORNIA

THE STATE OF CALIFORNIA OR ITS OFFICERS OR AGENTS SHALL NOT BE RESPONSIBLE FOR THE ACCURACY OR COMPLETENESS OF SCANNED COPIES OF THIS PLAN SHEET.

STATE OF CALIFORNIA

DEPARTMENT OF TRANSPORTATION

Caltrans

CONSULTANT FUNCTIONAL SUPERVISOR

AARON BRUSATORI, PE

CALCULATED—DESIGNED BY

CHECKED BY

VERONICA GARCIA—MCGREW

AARON S. BRUSATORI

REVISED BY

DATE REVISED

EROSION CONTROL QUANTITIES

FIBER ROLLS	HYDRAULIC BIOTIC GROWTH MEDIUM WITH FIBER REINFORCED MATRIX	DESCRIPTION	SHEET
LF	SQFT		
	141,213	EC	EC-1 / EC-2
10,732		FIBER ROLLS	
10,732	141,213	TOTAL	

EROSION CONTROL TYPE 1

SEQUENCE	ITEM	MATERIAL		APPLICATION RATE
		DESCRIPTION	TYPE	
STEP 1	HYDRAULIC BIOTIC GROWTH MEDIUM WITH FIBER REINFORCED MATRIX	SEED	MIX	50 LB/ACRE
		HGBM	—	4,000/ACRE
		FRM	—	2,500 LB/ACRE

FIBER ROLLS				
SEQUENCE	ITEM	MATERIAL	MATERIAL TYPE	REMARKS
FIBER ROLLS MUST BE INSTALLED AFTER THE HGBM WITH FRM HAS CURED	FIBER ROLLS	8 TO 10 INCHES IN DIA	RICE STRAW FILLED AND JUTE COVERED	TYPE 1 FIBER ROLL INSTALLATION. PLACE 10 FEET APART.

SEED MIX		
BOTANICAL NAME (COMMON NAME)	PERCENT GERMINATION (MINIMUM)	POUNDS PURE LIVE SEED PER ACRE (SLOPE MEASUREMENT)
ACHILLEA MILLIFOLIUM (NATIVE WHITE YARROW)	60	1
AMSINCKIA MENZIESII	40	3
ACMISPON AMERICANA (SPANISH CLOVER)	60	2.5
BROMUS CARINATUS, SIERRA 4500 (CALIFORNIA BROME)	65	12
ELYMUS GLAUCUS, SIERRA 4500 (BLUE WILD RYE)	60	8
ESCHSCHOLZIA CALIFORNICA	50	1.5
FESTUCA MICROSTACHYS (THREE WEEKS FESCUE)	60	6
LASTHENIA CALIFORNICA (DWARF GOLDFIELD)	50	1.5
LAYIA PLATYGLOSSA (TIDY TIPS)	35	1.5
LUPINUS NANUS (SKY LUPINE)	60	4
STIPA PULCHRA (PURPLE NEEDLEGRASS)	50	6
TRIFOLIUM WILDENOVII (TOM CAT CLOVER)	60	3

Dist	COUNTY	ROUTE	POST MILES TOTAL PROJECT	SHEET No.	TOTAL SHEETS
03	ED	50	16.4/16.8	16	45
Aaron Brusatori REGISTERED CIVIL ENGINEER			8-07-20 DATE		
AUGUST 31, 2020 PLANS APPROVAL DATE			REGISTERED PROFESSIONAL ENGINEER AARON BRUSATORI No. 64384 Exp. 6/30/21 CIVIL STATE OF CALIFORNIA		
THE STATE OF CALIFORNIA OR ITS OFFICERS OR AGENTS SHALL NOT BE RESPONSIBLE FOR THE ACCURACY OR COMPLETENESS OF SCANNED COPIES OF THIS PLAN SHEET.					
R.E.Y. ENGINEERS 905 SUTTER STREET, SUITE 200 FOLSOM, CA 95630			CITY OF PLACERVILLE ENGINEERING DEPARTMENT 3101 CENTER STREET PLACERVILLE, CA 95667		

EROSION CONTROL LEGEND


NO SCALE ECL -1

DATE PLOTTED ==> 10/4/2020
TIME PLOTTED ==> 11:29 AM

STATE OF CALIFORNIA	—	DEPARTMENT OF TRANSPORTATION	CONSULTANT FUNCTIONAL SUPERVISOR	CHECKED BY	VERONICA GARCIA-MCGREW	REVISED BY	
Caltrans	—		AARON BRUSATORI, PE		AARON S. BRUSATORI		

NOTE:

1. THIS PLAN ACCURATE FOR FOR CONTOUR GRADING WORK ONLY.

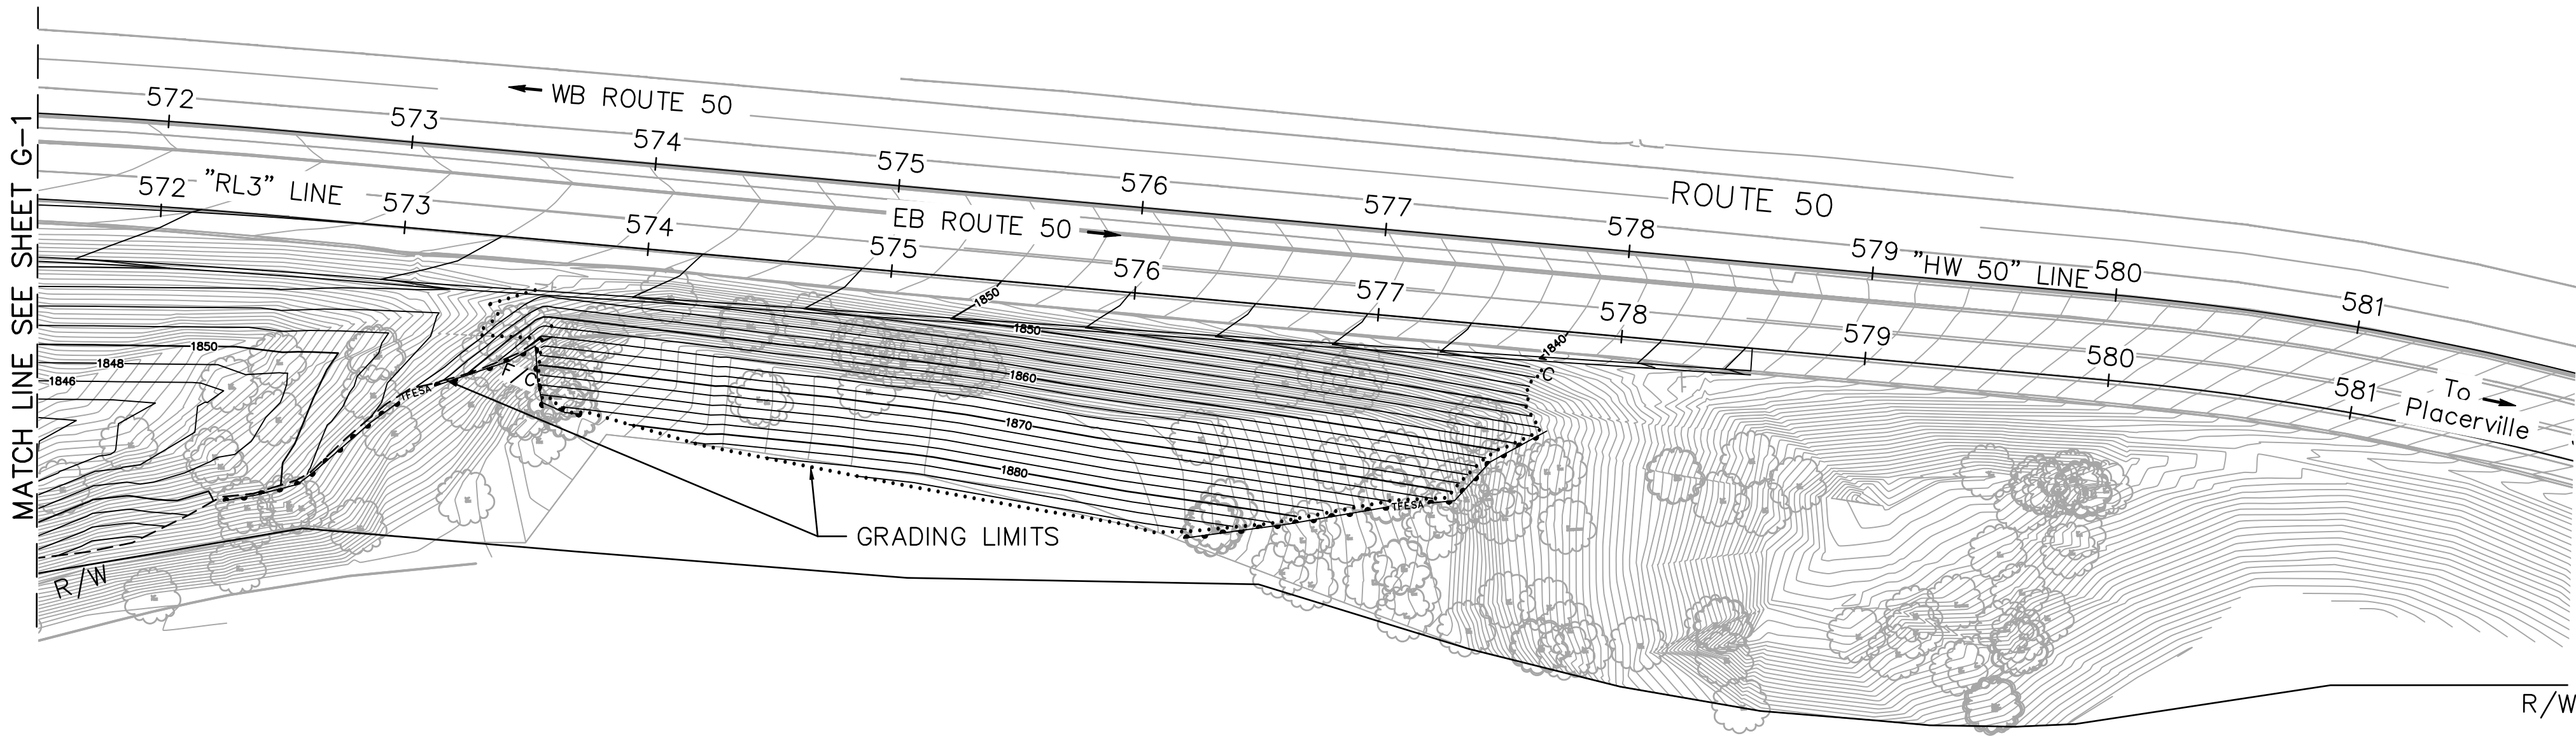

APPROVED FOR CONTOUR GRADING WORK ONLY

CONTOUR GRADING

SCALE: 1" = 50'

G-2

DIST	COUNTY	ROUTE	POST MILES TOTAL PROJECT	SHEET No.	TOTAL SHEETS
03	ED	50	16.4 / 16.8	18	45
Aaron Brusatori REGISTERED CIVIL ENGINEER			8-07-20 DATE	REGISTERED PROFESSIONAL ENGINEER AARON BRUSATORI No. 64384 Exp. 6/30/21 CIVIL STATE OF CALIFORNIA	
AUGUST 31, 2020 PLANS APPROVAL DATE					
THE STATE OF CALIFORNIA OR ITS OFFICERS OR AGENTS SHALL NOT BE RESPONSIBLE FOR THE ACCURACY OR COMPLETENESS OF SCANNED COPIES OF THIS PLAN SHEET.					
R.E.Y. ENGINEERS 905 SUTTER STREET, SUITE 200 FOLSOM, CA 95630			CITY OF PLACERVILLE ENGINEERING DEPARTMENT 3101 CENTER STREET PLACERVILLE, CA 95667		

STATE OF CALIFORNIA - DEPARTMENT OF TRANSPORTATION

Caltrans


CONSULTANT FUNCTIONAL SUPERVISOR

VERONICA GARCIA-MCGREW

CHECKED BY

REVISOR

DATE

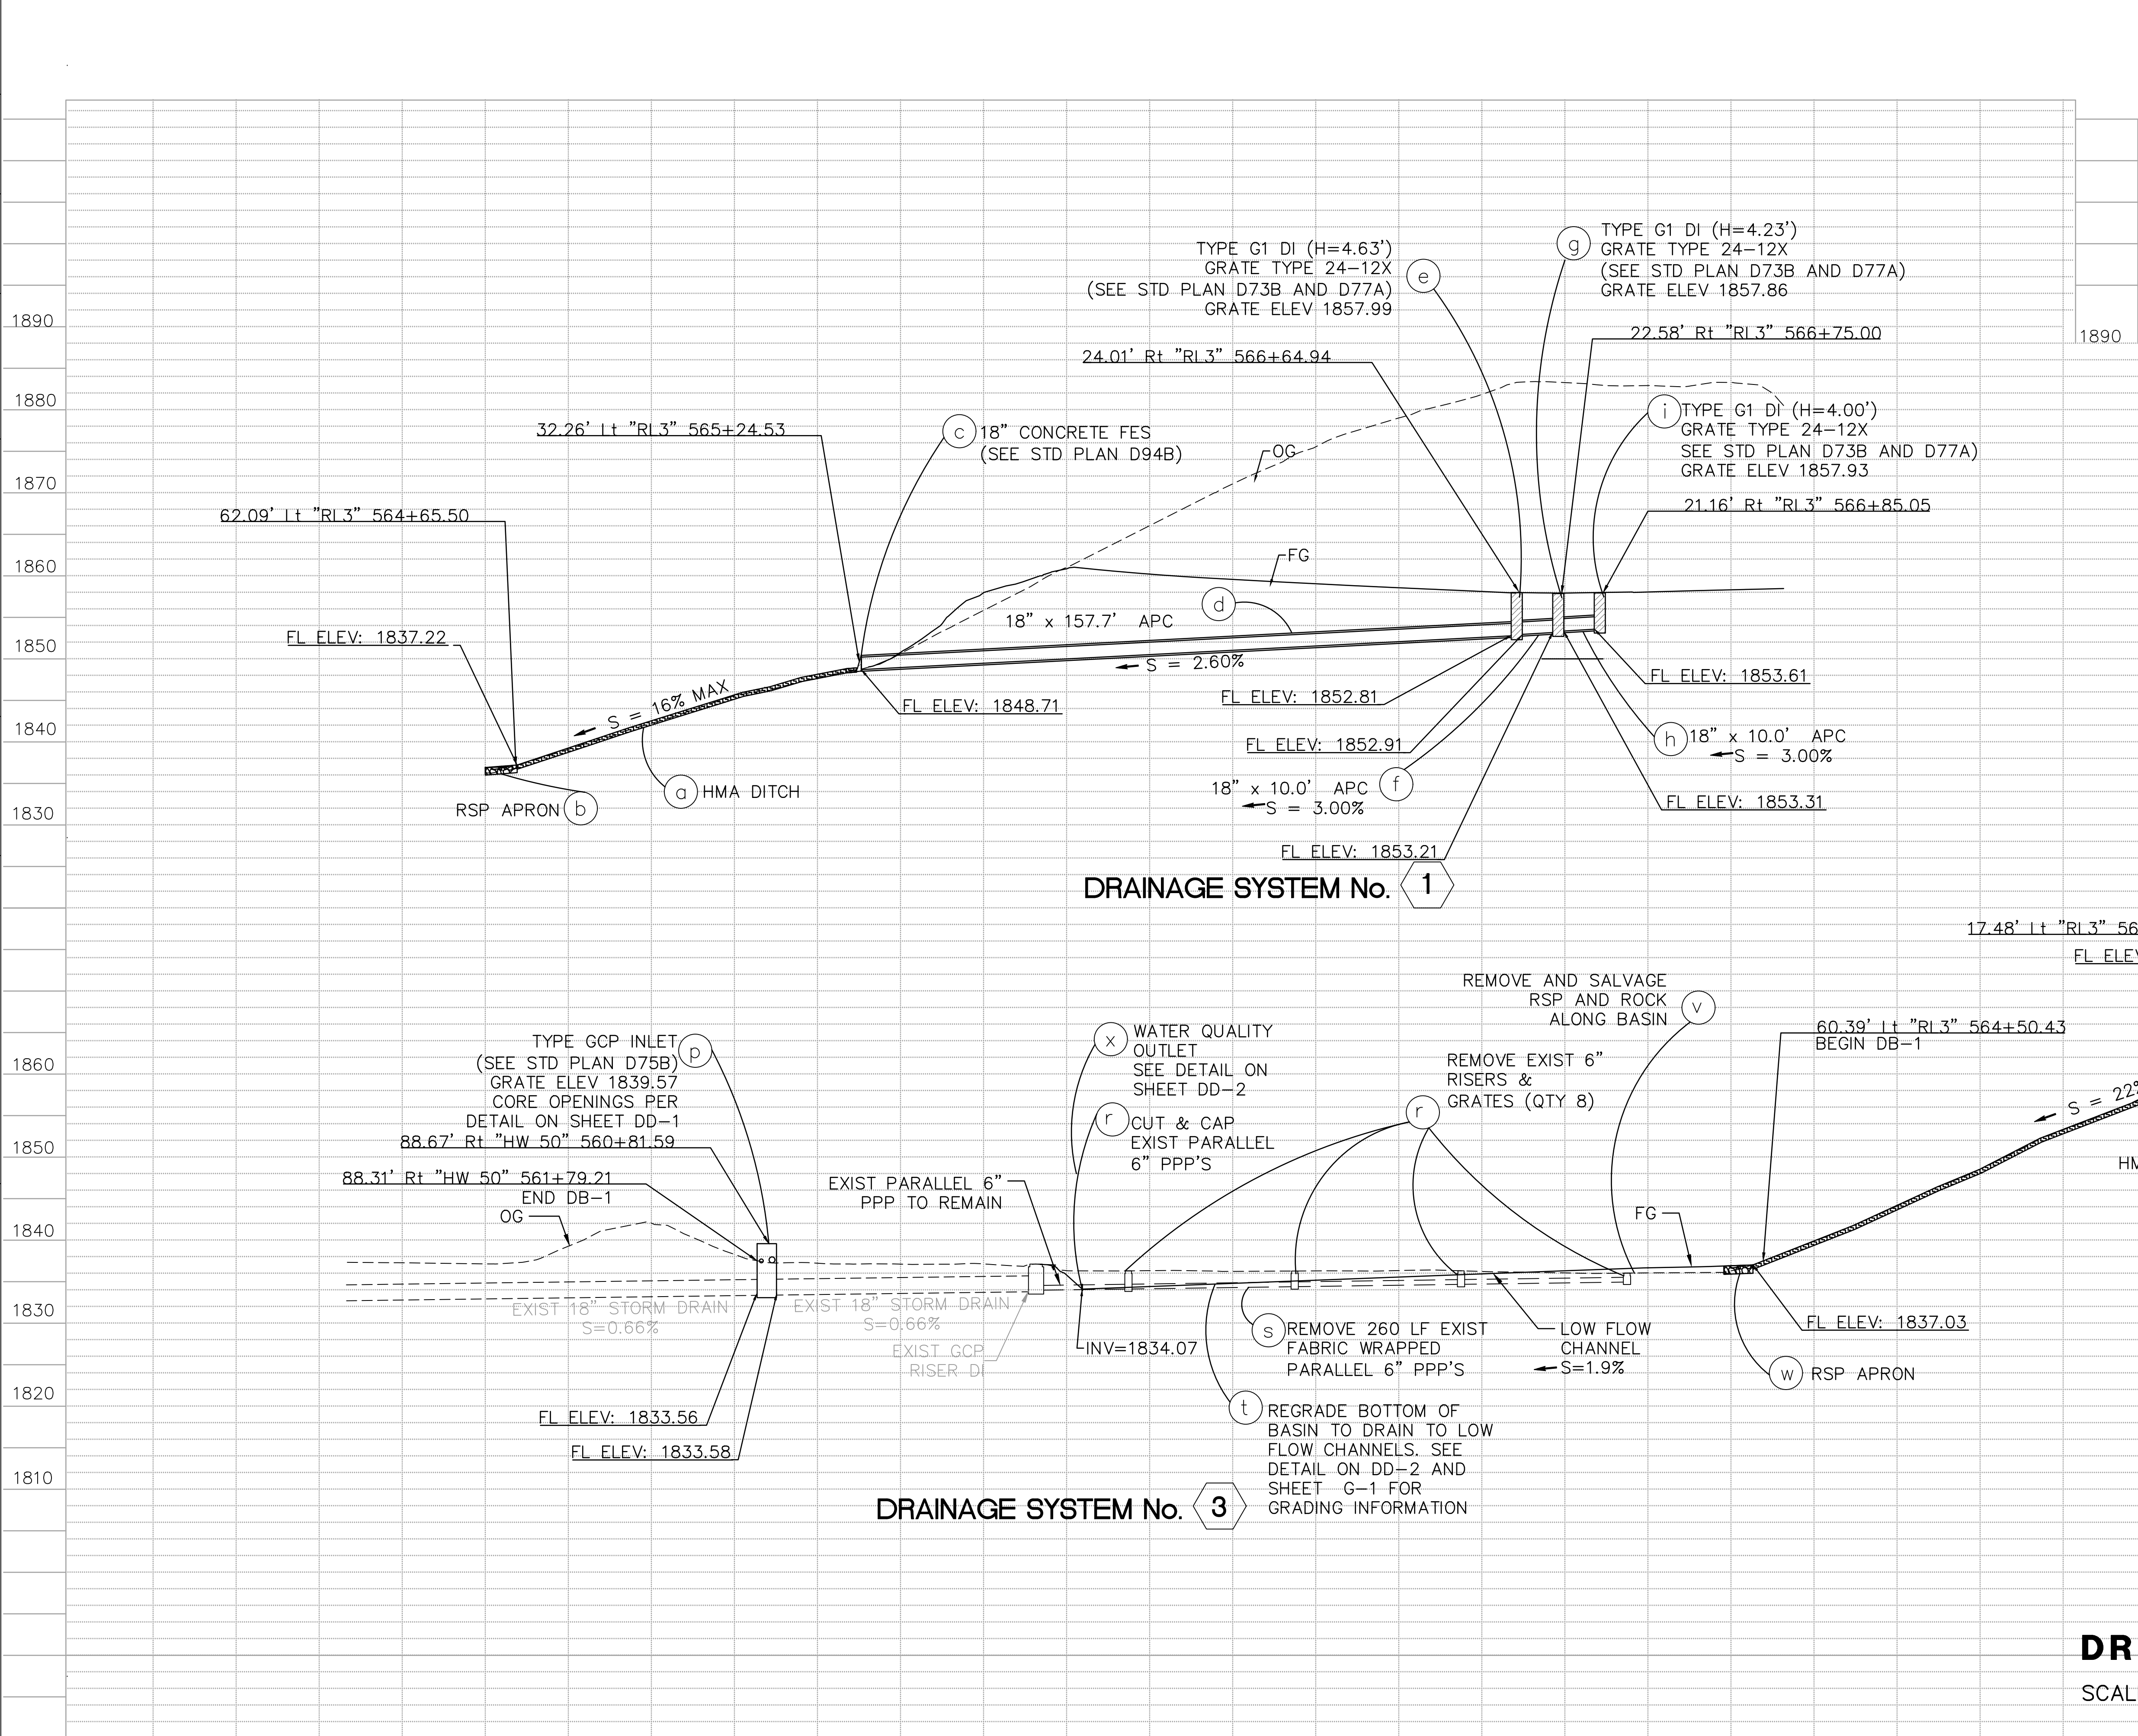

Dist	COUNTY	ROUTE	POST MILES TOTAL PROJECT	SHEET No.	TOTAL SHEETS
03	ED	50	16.4/16.8	20	45

Aaron Brusatori

REGISTERED CIVIL ENGINEER

8-07-20
DATE

AUGUST 31, 2020

PLANS APPROVAL DATE

THE STATE OF CALIFORNIA OR ITS OFFICERS
OR AGENTS SHALL NOT BE RESPONSIBLE FOR
THE ACCURACY OR COMPLETENESS OF SCANNED
COPIES OF THIS PLAN SHEET.

REG. NO. 64384

EXP. 6/30/21

CIVIL

R.E.Y. ENGINEERS
905 SUTTER STREET, SUITE 200
FOLSOM, CA 95630

CITY OF PLACERVILLE
ENGINEERING DEPARTMENT
3101 CENTER STREET
PLACERVILLE, CA 95667

DATE PLOTTED => 10/14/2020

TIME PLOTTED => 11:30 AM

DRAINAGE PROFILE

SCALE: Horiz 1" = 20'

Vert 1" = 10'

DP-1

STATE OF CALIFORNIA - DEPARTMENT OF TRANSPORTATION

Caltrans

CONSULTANT FUNCTIONAL SUPERVISOR

AARON BRUSATORI, PE

CALCULATED-DESIGNED BY


CHECKED BY

VERONICA GARCIA-MCGREW

AARON S. BRUSATORI

REVISED BY

DATE REVISED

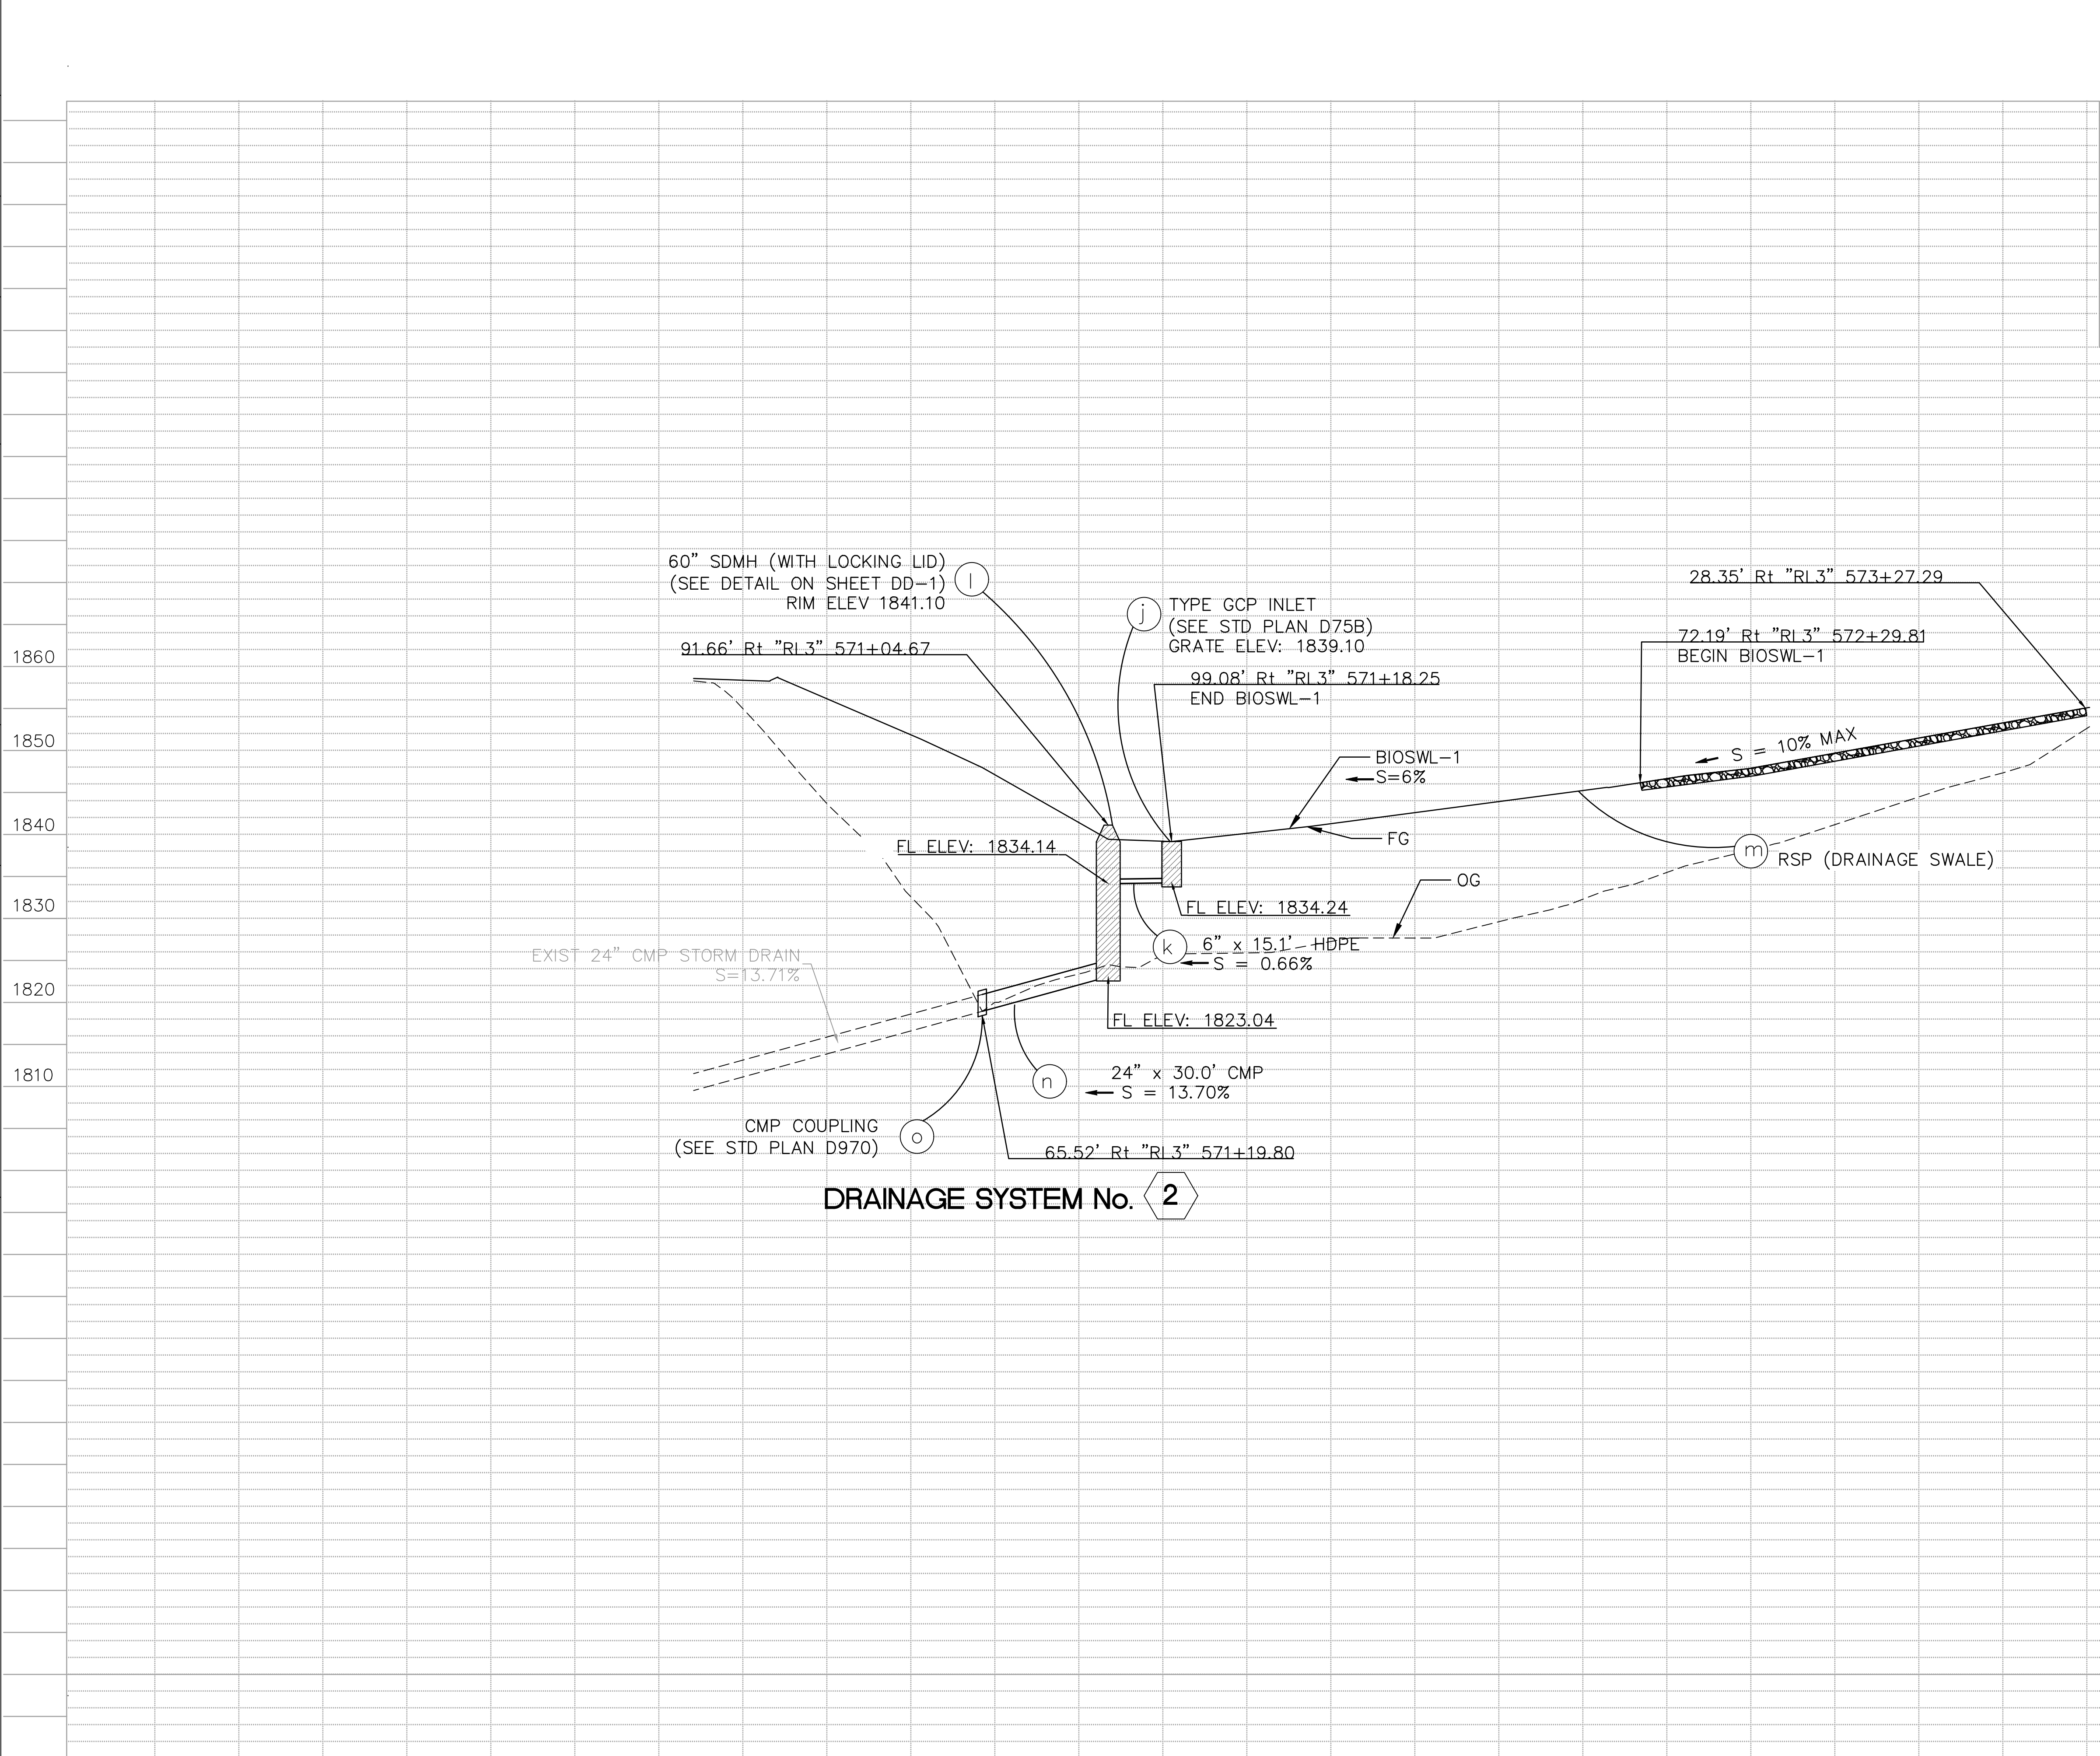

Dist	COUNTY	ROUTE	POST MILES TOTAL PROJECT	SHEET No.	TOTAL SHEETS
03	ED	50	16.4/16.8	21	45

Aaron Brusatori

REGISTERED CIVIL ENGINEER

8-07-20

DATE

AUGUST 31, 2020

PLANS APPROVAL DATE

THE STATE OF CALIFORNIA OR ITS OFFICERS
OR AGENTS SHALL NOT BE RESPONSIBLE FOR
THE ACCURACY OR COMPLETENESS OF SCANNED
COPIES OF THIS PLAN SHEET.

R.E.Y. ENGINEERS
905 SUTTER STREET, SUITE 200
FOLSOM, CA 95630

CITY OF PLACERVILLE
ENGINEERING DEPARTMENT
3101 CENTER STREET
PLACERVILLE, CA 95667

REGISTERED PROFESSIONAL ENGINEER

AARON BRUSATORI

No. 64384

Exp. 6/30/21

CIVIL

STATE OF CALIFORNIA

DRAINAGE PROFILE

SCALE: Horiz 1" = 20'

Vert 1" = 10'

DP-2

BORDER LAST REVISED 7/2/2010

USERNAME => VGMCGREW
CAD FILE => 6884.009 DRAINAGE PLAN.DWG

RELATIVE BORDER SCALE
IS IN INCHES

0 1 2 3

UNIT

PROJECT NUMBER & PHASE

03190001521

DATE PLOTTED => 10/14/2020
TIME PLOTTED => 11:30 AM

STATE OF CALIFORNIA

DEPARTMENT OF TRANSPORTATION

Caltrans

CONSULTANT FUNCTIONAL SUPERVISOR

AARON BRUSATORI, PE

DESIGNED BY

CHECKED BY

VERONICA GARCIA-MCGREW

AARON S. BRUSATORI

REVISED BY

DATE REVISED

Dist	COUNTY	ROUTE	POST MILES TOTAL PROJECT	SHEET No.	TOTAL SHEETS
03	ED	50	16.4/16.8	22	45

Aaron Brusatori

REGISTERED CIVIL ENGINEER

8-07-20

DATE

AUGUST 31, 2020

PLANS APPROVAL DATE

THE STATE OF CALIFORNIA OR ITS OFFICERS
OR AGENTS SHALL NOT BE RESPONSIBLE FOR
THE ACCURACY OR COMPLETENESS OF SCANNED
COPIES OF THIS PLAN SHEET.

R.E.Y. ENGINEERS
905 SUTTER STREET, SUITE 200
FOLSOM, CA 95630

CITY OF PLACERVILLE
ENGINEERING DEPARTMENT
3101 CENTER STREET
PLACERVILLE, CA 95667

REGISTERED PROFESSIONAL ENGINEER

AARON BRUSATORI

No. 64384

Exp. 6/30/21

CIVIL

STATE OF CALIFORNIA

HMA DITCH

1 a
3 u

PLAN

SECTION

HMA DITCH AT FES

1 a c

SECTION

RSP APRON

1 b
3 w

CORE OPENINGS INTO GCP RISER

3 p

RSP DRAINAGE SWALE

2 m

SECTION

INLET ADJACENT TO HMA DIKE

1 e g i

DRAINAGE DETAILS

NO SCALE

DD-1

BORDER LAST REVISED 7/2/2010

USERNAME => VGMCGREW
CAD FILE => 6884.009 DRAINAGE PLAN.DWG

RELATIVE BORDER SCALE IS IN INCHES

0 1 2 3

UNIT

PROJECT NUMBER & PHASE

03190001521

DATE PLOTTED => 10/14/2020
TIME PLOTTED => 11:30 AM
LAST REVISION

NOTE:


(N) = NOT A SEPARATE PAY ITEM, FOR INFORMATION ONLY.

ABBREVIATIONS:

S STANDARD JOINT

APC ALLOWABLE PIPE MATERIAL		
DESIGNATION	RCP CL 3	HDPE PIPE TYPE S
18” APC	YES	YES

 DRAINAGE QUANTITIES

DRAINAGE SYSTEM NO. 	DRAINAGE UNIT 	ROCK SLOPE PROTECTION																	24" CSP COUPLING (N)	REMOVE EXISTING RISERS AND GRATES (N)	CUT & CAP EXIST 6"PPP (N)	BAR REINFORCEMENT (N)	HEIGHT OF INLET (N)	PIPE JOINT CLASSIFICATION (N)	LADDER (N)	HEIGHT OF COVER (N)	DESCRIPTION	STATION	DRAINAGE UNIT 	DRAINAGE SYSTEM NO. 
		CY	LF	SQYD	EA	LF	36" REINFORCED CONCRETE PIPE INLET	60" SDMH	6" HDPE (TYPE S)	24" CSP	WATER QUALITY OUTLET	STRUCTURAL CONCRETE (DRAINAGE INLET)	INLET FRAME AND GRATE	DRAINAGE INLET MARKER	60 LB CLASS II, METHOD B	300 LB CLASS IV, METHOD B	RSP FABRIC (CLASS 8)													
1	a			65																							HMA DITCH	"RL3" 564+65.50 – 565+32.68	a	1
	b															7.7	16.1										RSP APRON	"RL3" 564+65.50	b	
	c				1																						18" CONCRETE FES	"RL3" 565+32.68	c	
	d					158																	S				18" APC	"RL3" 565+24.53 – 566+64.94	d	
	e										1.31	1	1								124.20	5.2				GRATE TYPE 24–12X	"RL3" 566+64.94	e		
	f					10																	S				18" HDPE TYPE S	"RL3" 566+65.00 – 566+75.00	f	
	g										1.22	1	1								115.44	5.5				GRATE TYPE 24–12X	"RL3" 566+75.00	g		
	h					10																	S				18" HDPE TYPE S	"RL3" 566+75.00 – 566+85.00	h	
	i										1.17	1	1								110.40	5.2				GRATE TYPE 24–12X	566+85.05	i		
2	j					6.8						1	1									5.8					GCP INLET	"RL3" 571+22.99	j	2
	k							9.5																			6" HDPE	"RL3" 571+13.29 – 571+22.99	k	
	l						1					1	1									18.9		18			60" SDMH	"RL3" 571+13.29	l	
	m													17.6		70.1											RSP	"RL3" 571+82.20 – 572+78.79	m	
	n								13.0																		24" CORRUGATED STEEL PIPE	"RL3" 571+13.29 – 571+19.80	n	
	o																1										CONNECT TO EXIST PIPE	"RL3" 571+19.80	o	
3	p					6.9						1	1									6.9					GCP INLET	"HW 50" 560+81.59	p	3
	q																		2								PAID UNDER REMOVE CULVERT	"HW 50" 562+57.81	q	
	r																	8									PAID UNDER REMOVE CULVERT	"HW 50" 562+57.81 – 563+56.81	r	
	s		130																						3		REMOVE DUAL PIPE CULVERT	"HW 50" 562+57.81 – 563+56.81	s	
	u			100																							HMA DITCH	"RL3" 563+23.73 – 564+32.87	u	
	v	56																									REMOVE AND SALVAGE RSP & ROCK	"HW 50" 562+52.53 – 563+67.52	v	
	w														7.7	16											RSP APRON	"RL3" 564+32.87	w	
	x								1																		WATER QUALITY OUTLET	"HW 50" 562+58	x	
TOTAL		56	130	165	1	178	13.7		9.5	13.0	1	3.7	6	6	17.6	15.6	103	1	8	2	350.04			18						

Dist

COUNTY

ROUTE

POST MILES TOTAL PROJECT

SHEET No.

TOTAL SHEETS

03

 
ED

50

16.4/16.8

24

45




8-07-20

REGISTERED CIVIL ENGINEER

DATE

AUGUST 31, 2020

PLANS APPROVAL DATE

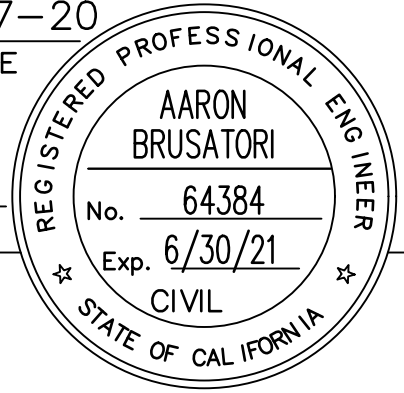

THE STATE OF CALIFORNIA OR ITS OFFICERS OR AGENTS SHALL NOT BE RESPONSIBLE FOR THE ACCURACY OR COMPLETENESS OF SCANNED COPIES OF THIS PLAN SHEET.

R.E.Y. ENGINEERS
905 SUTTER STREET, SUITE 200
FOLSOM, CA 95630

CITY OF PLACERVILLE
ENGINEERING DEPARTMENT
3101 CENTER STREET
PLACERVILLE, CA 95667

DRAINAGE QUANTITIES

DQ-1

STATE OF CALIFORNIA

DEPARTMENT OF TRANSPORTATION

Caltrans

CONSULTANT FUNCTIONAL SUPERVISOR

AARON BRUSATORI, PE

CALCULATED—DESIGNED BY

CHECKED BY

VERONICA GARCIA—MCGREW

AARON S. BRUSATORI

REVISED BY

DATE REVISED

NOTE:

1. THIS PLAN IS ACCURATE FOR CONSTRUCTION AREA SIGNS ONLY.
2. SIGN LOCATIONS SHOWN ARE APPROXIMATE. EXACT LOCATIONS WILL BE DETERMINED BY THE ENGINEER.
3. SIGN POST LENGTH ARE APPROXIMATE, EXACT SIZE AND LENGTH WILL BE DETERMINED BY THE ENGINEER.
4. FOR ADDITIONAL CONSTRUCTION AREA SIGNS, SEE SHEET TH-1.

LEGEND:

- ⚡

 - TEMP CONSTRUCTION AREA SIGN
- ⓧ

 - SIGN NUMBER

STATIONARY MOUNTED CONSTRUCTION AREA SIGNS

SIGN NO.	SIGN CODE		SIGN MESSAGE	PANEL SIZE (INCHES)	NO. & SIZE OF POSTS (INCHES)	NO. SIGNS
	FEDERAL	CALIFORNIA				
Ⓐ	W20-1	-	ROAD WORK AHEAD	60 X 60	2 - 4 X 6	4
Ⓑ	G20-2	-	END ROAD WORK	48 X 24	1 - 4 X 6	3
Ⓒ	-	C40A(CA)	TRAFFIC FINES DOUBLED IN WORK ZONES	48 X 48	1 - 4 X 6	1

Dist

COUNTY

ROUTE

POST MILES
TOTAL PROJECT

SHEET No.

TOTAL SHEETS

03

ED

50

16.4/16.8

25

45

Aaron Brusatori

REGISTERED CIVIL ENGINEER

8-07-20

DATE

AUGUST 31, 2020

PLANS APPROVAL DATE

THE STATE OF CALIFORNIA OR ITS OFFICERS OR AGENTS SHALL NOT BE RESPONSIBLE FOR THE ACCURACY OR COMPLETENESS OF SCANNED COPIES OF THIS PLAN SHEET.

REGISTERED PROFESSIONAL ENGINEER

AARON BRUSATORI

No. 64384



Exp. 6/30/21

CIVIL

STATE OF CALIFORNIA

R.E.Y. ENGINEERS
905 SUTTER STREET, SUITE 200
FOLSOM, CA 95630

CITY OF PLACERVILLE
ENGINEERING DEPARTMENT
3101 CENTER STREET
PLACERVILLE, CA 95667

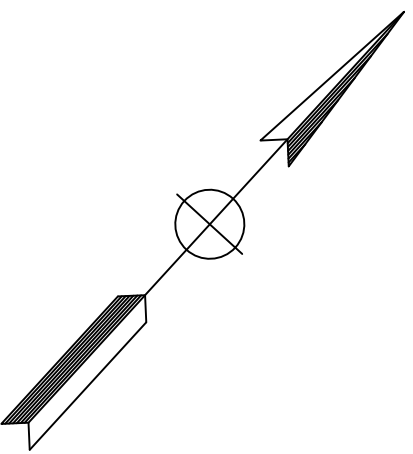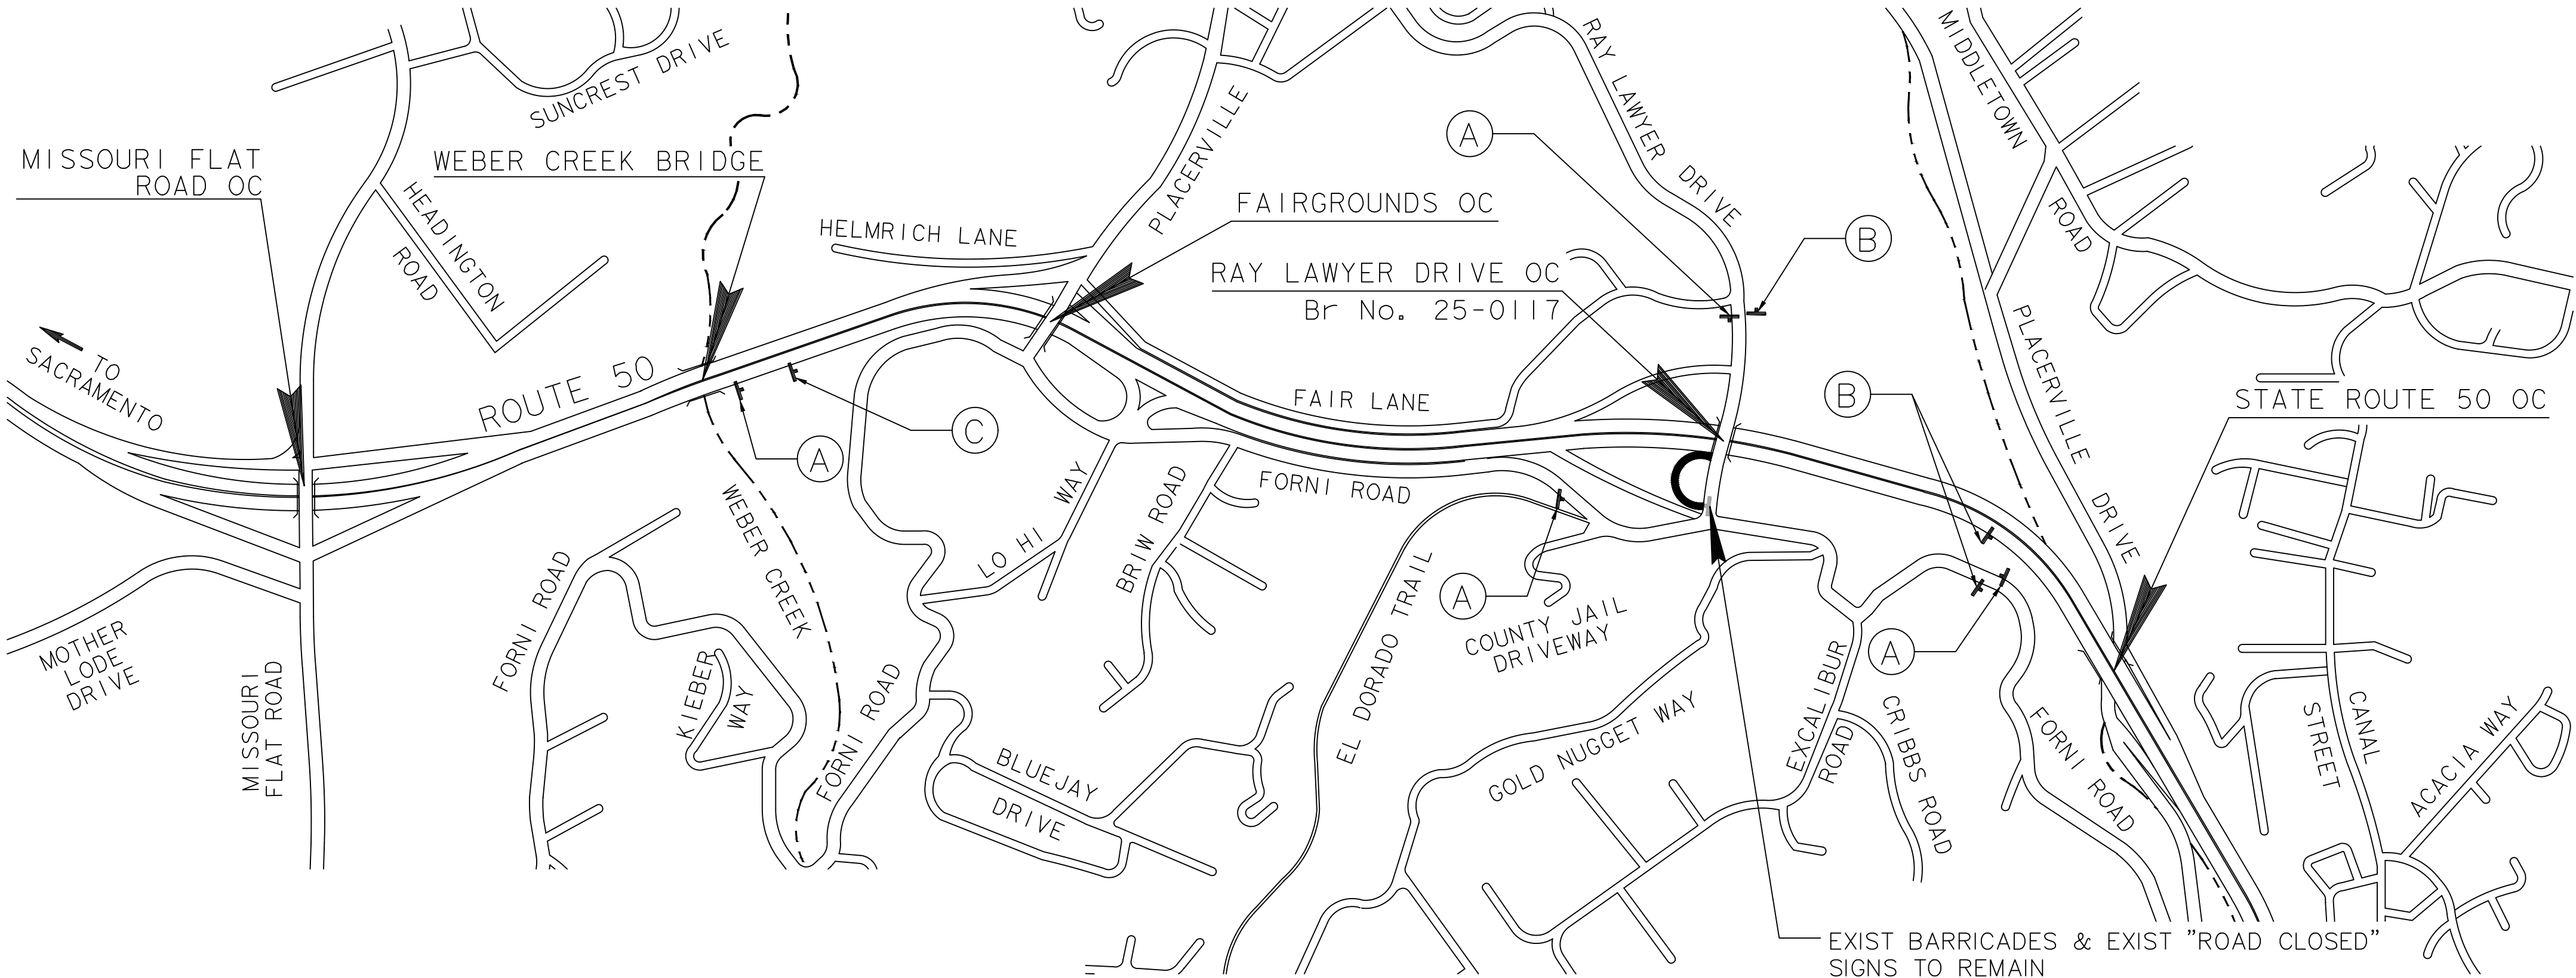

APPROVED FOR CONSTRUCTION AREA SIGN WORK ONLY


CONSTRUCTION AREA SIGN PLAN

NO SCALE

CS-1

NOTE:

- SEE CONSTRUCTION AREA SIGNS SHEETS CS-1 FOR MORE SIGNS.
- ANCHOR K-RAIL WHEN CLEAR SPACE BEHIND IT IS LESS THAN 24”.
- STATION-OFFSET CALLOUTS ON TRAFFIC HANDLING PLAN SHEETS REFER TO “HW-50” LINE ONLY.

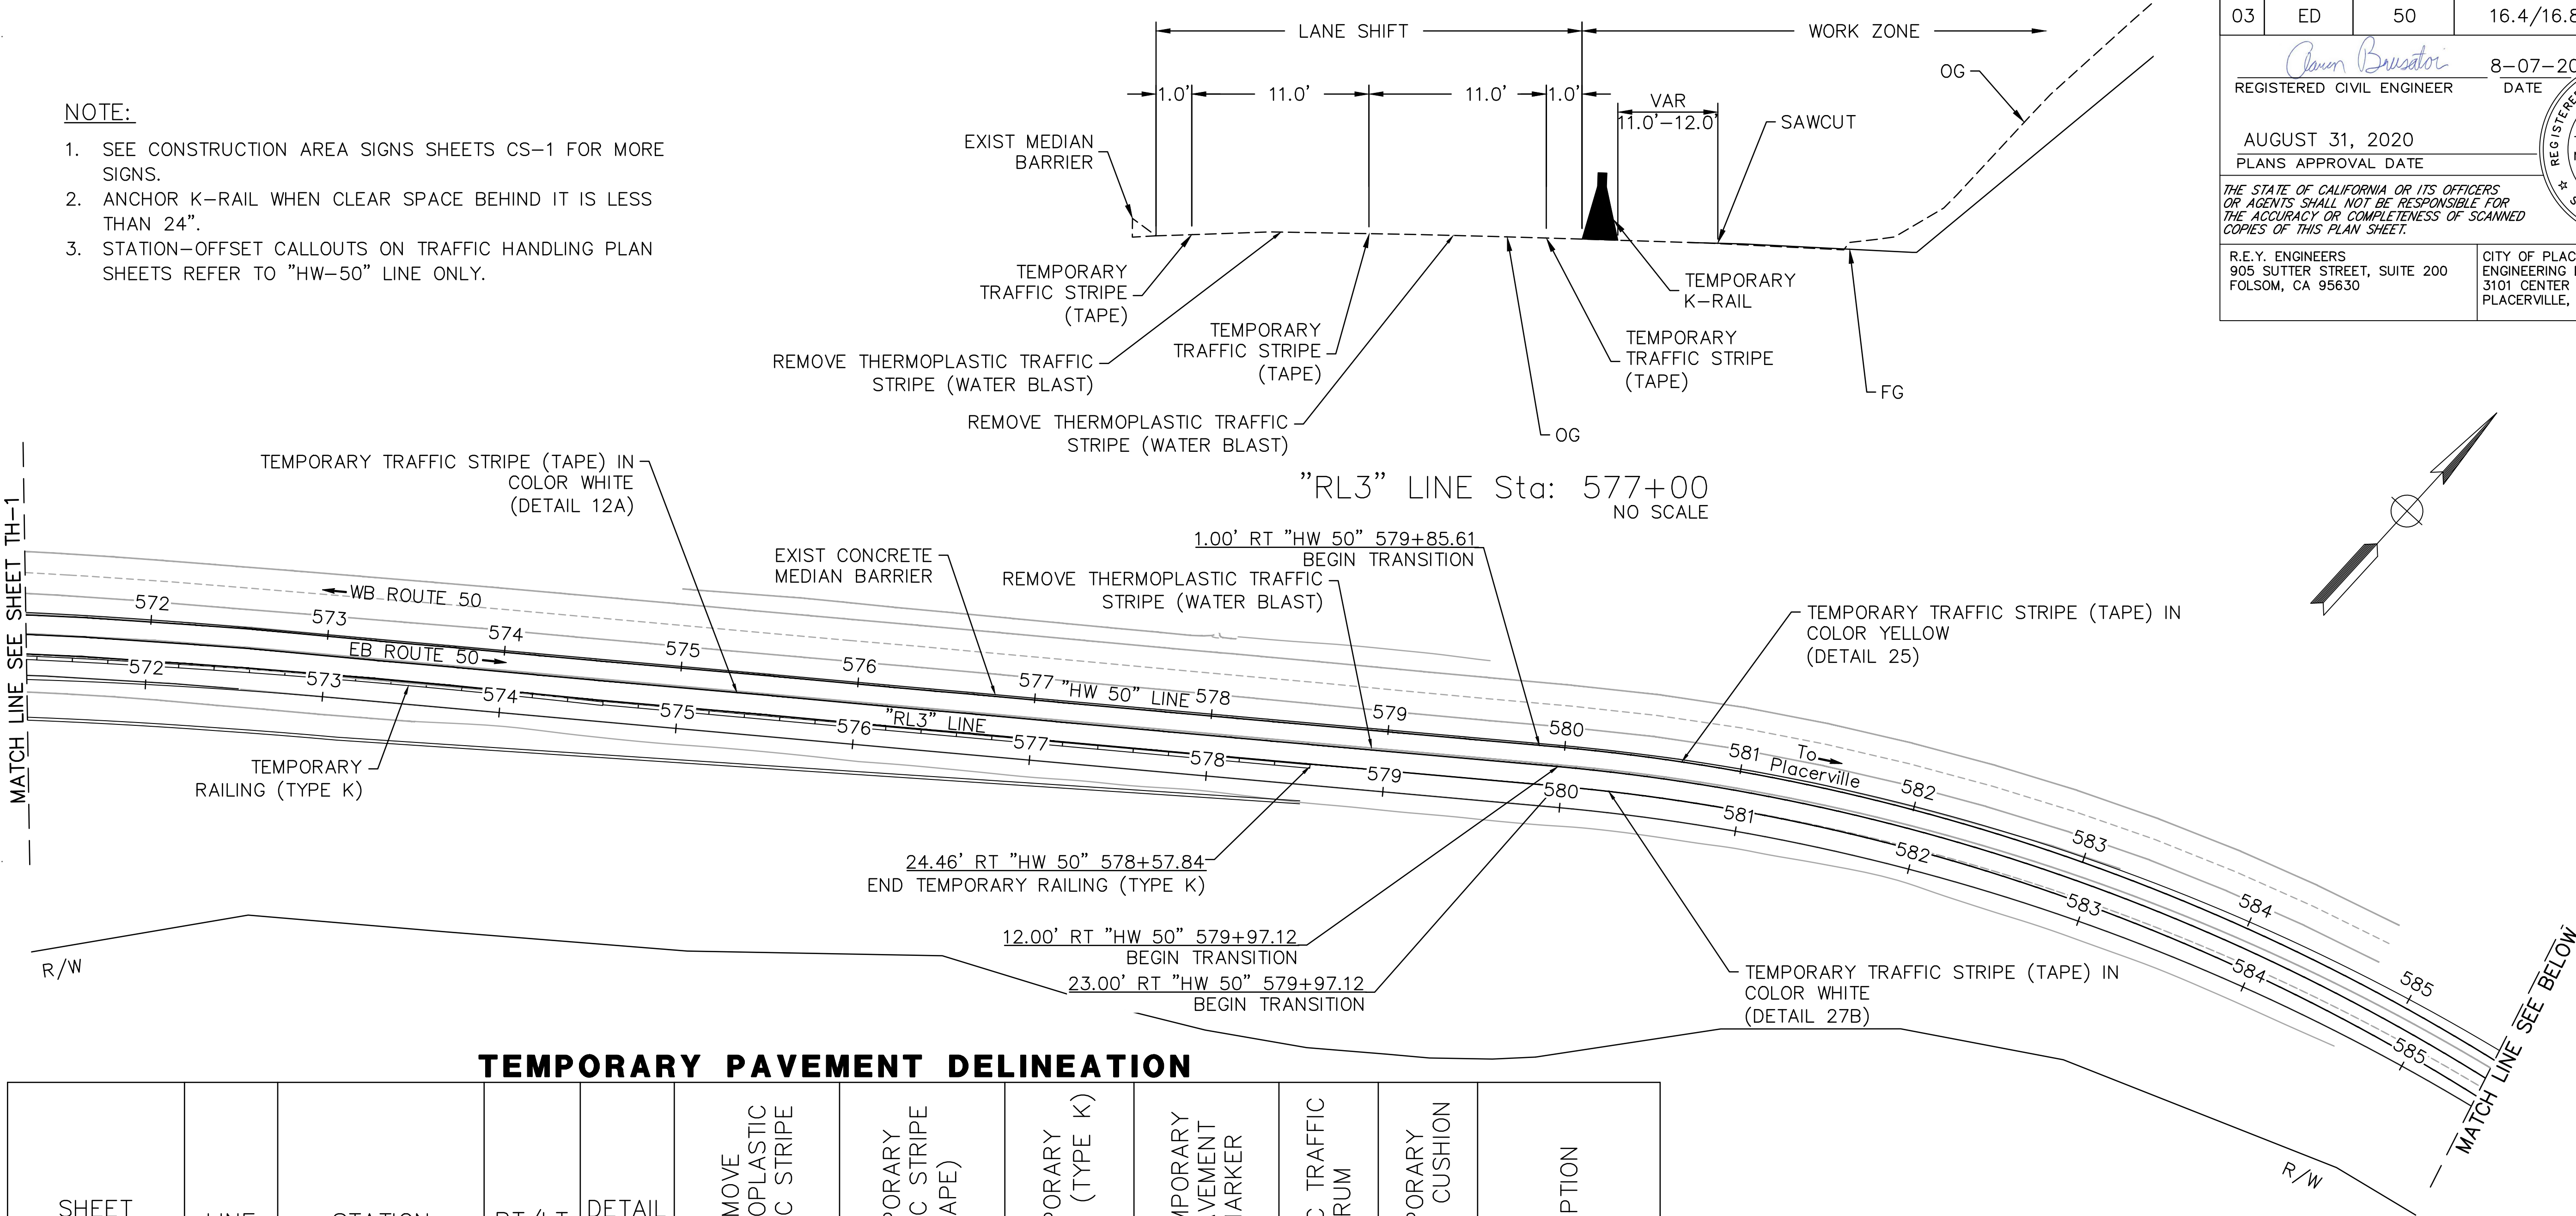

TEMPORARY PAVEMENT DELINEATION

SHEET NUMBER	LINE	STATION	RT/LT	DETAIL NO.	REMOVE THERMOPLASTIC TRAFFIC STRIPE	TEMPORARY TRAFFIC STRIPE (TAPE)	TEMPORARY RAILING (TYPE K)	TEMPORARY PAVEMENT MARKER		PLASTIC TRAFFIC DRUM	TEMPORARY CRASH CUSHION	DESCRIPTION
					(LF)	(LF)	(LF)	G	RY	EA	(EA)	
TH-1 – TH-2	“HW 50”	561+87.36 – 588+26.49	RT	12A	2625	2625		55				WATER BLAST
TH-1 – TH-2	“HW 50”	561+87.31 – 588+26.49	RT	25	2635	2635			55			WATER BLAST
TH-1 – TH-2	“HW 50”	559+27.22 – 578+57.84	RT				1918					TYPE K
TH-1 – TH-2	“HW 50	561+87.32 – 588+26.49	RT	27B	2612	2612						WATER BLAST
TH-1	“HW 50”	557+38.54 – 558+46.30	RT							5		
TH-1	“HW 50”	559+27.22	RT								1	SAND FILLED ARRAY 'TS14'

APPROVED FOR STAGE COSTRUCTION AND TRAFFIC HANDLING WORK ONLY

TRAFFIC HANDLING PLAN

SCALE: 1”=50’

TH-2

Dist

COUNTY

ROUTE

POST MILES TOTAL PROJECT

SHEET No.

TOTAL SHEETS

03

ED

50

16.4/16.8

27

45

Aaron Brusatori

REGISTERED CIVIL ENGINEER

8-07-20

DATE

AUGUST 31, 2020

PLANS APPROVAL DATE

THE STATE OF CALIFORNIA OR ITS OFFICERS OR AGENTS SHALL NOT BE RESPONSIBLE FOR THE ACCURACY OR COMPLETENESS OF SCANNED COPIES OF THIS PLAN SHEET.

R.E.Y. ENGINEERS

905 SUTTER STREET, SUITE 200

FOLSOM, CA 95630

CITY OF PLACERVILLE

ENGINEERING DEPARTMENT

3101 CENTER STREET

PLACERVILLE, CA 95667

REGISTERED PROFESSIONAL ENGINEER

AARON BRUSATORI

No. 64384

Exp. 6/30/21

CIVIL

STATE OF CALIFORNIA

NOTE:

1. FOR ACCURATE RIGHT OF WAY DATA, CONTACT RIGHT OF WAY ENGINEERING AT THE DISTRICT OFFICE.
2. SEE SHEET E-5 FOR SIGN CHANGES ON EXISTING MAST ARMS AT RAY LAWYER DRIVE INTERSECTION

LEGEND:

- XX

 - PAVEMENT DELINEATION DETAIL
- XX

 - ROADSIDE SIGN No.
- ▶

 - BEGIN/END PAVEMENT DELINEATION DETAIL
- ≡

 - CHANGE IN PAVEMENT DELINEATION DETAIL

- ⌋

 - ROADSIDE SIGN (TWO POSTS)
- ⌋

 - ROADSIDE SIGN (ONE POST)
- ⌋

 - ROADSIDE SIGN ON TYPE 1B POLE
- ⌋

 - OBJECT MARKER
- G

 - GUARD RAILING DELINEATOR (TYPE G)
- F

 - DELINEATOR (CLASS 1) TYPE F

- ⊙

 ELECTROLIER PER ELECTRICAL SHEET E-4
- ⊙

 1-D POLE PER ELECTRICAL SHEET E-2
- ▲

 RESET ROADSIDE SIGN
- REMOVE ROADSIDE SIGN

Dist

03

COUNTY

ED

ROUTE

50

POST MILES TOTAL PROJECT

16.4/16.8

SHEET No.

28

TOTAL SHEETS

45

REGISTERED CIVIL ENGINEER

DATE

8-07-20

AUGUST 31, 2020

PLANS APPROVAL DATE

THE STATE OF CALIFORNIA OR ITS OFFICERS OR AGENTS SHALL NOT BE RESPONSIBLE FOR THE ACCURACY OR COMPLETENESS OF SCANNED COPIES OF THIS PLAN SHEET.

R.E.Y. ENGINEERS

905 SUTTER STREET, SUITE 200
FOLSOM, CA 95630

CITY OF PLACERVILLE

ENGINEERING DEPARTMENT
3101 CENTER STREET
PLACERVILLE, CA 95667

REGISTERED PROFESSIONAL ENGINEER


AARON BRUSATORI

No. 64384

Exp. 6/30/21

CIVIL

STATE OF CALIFORNIA

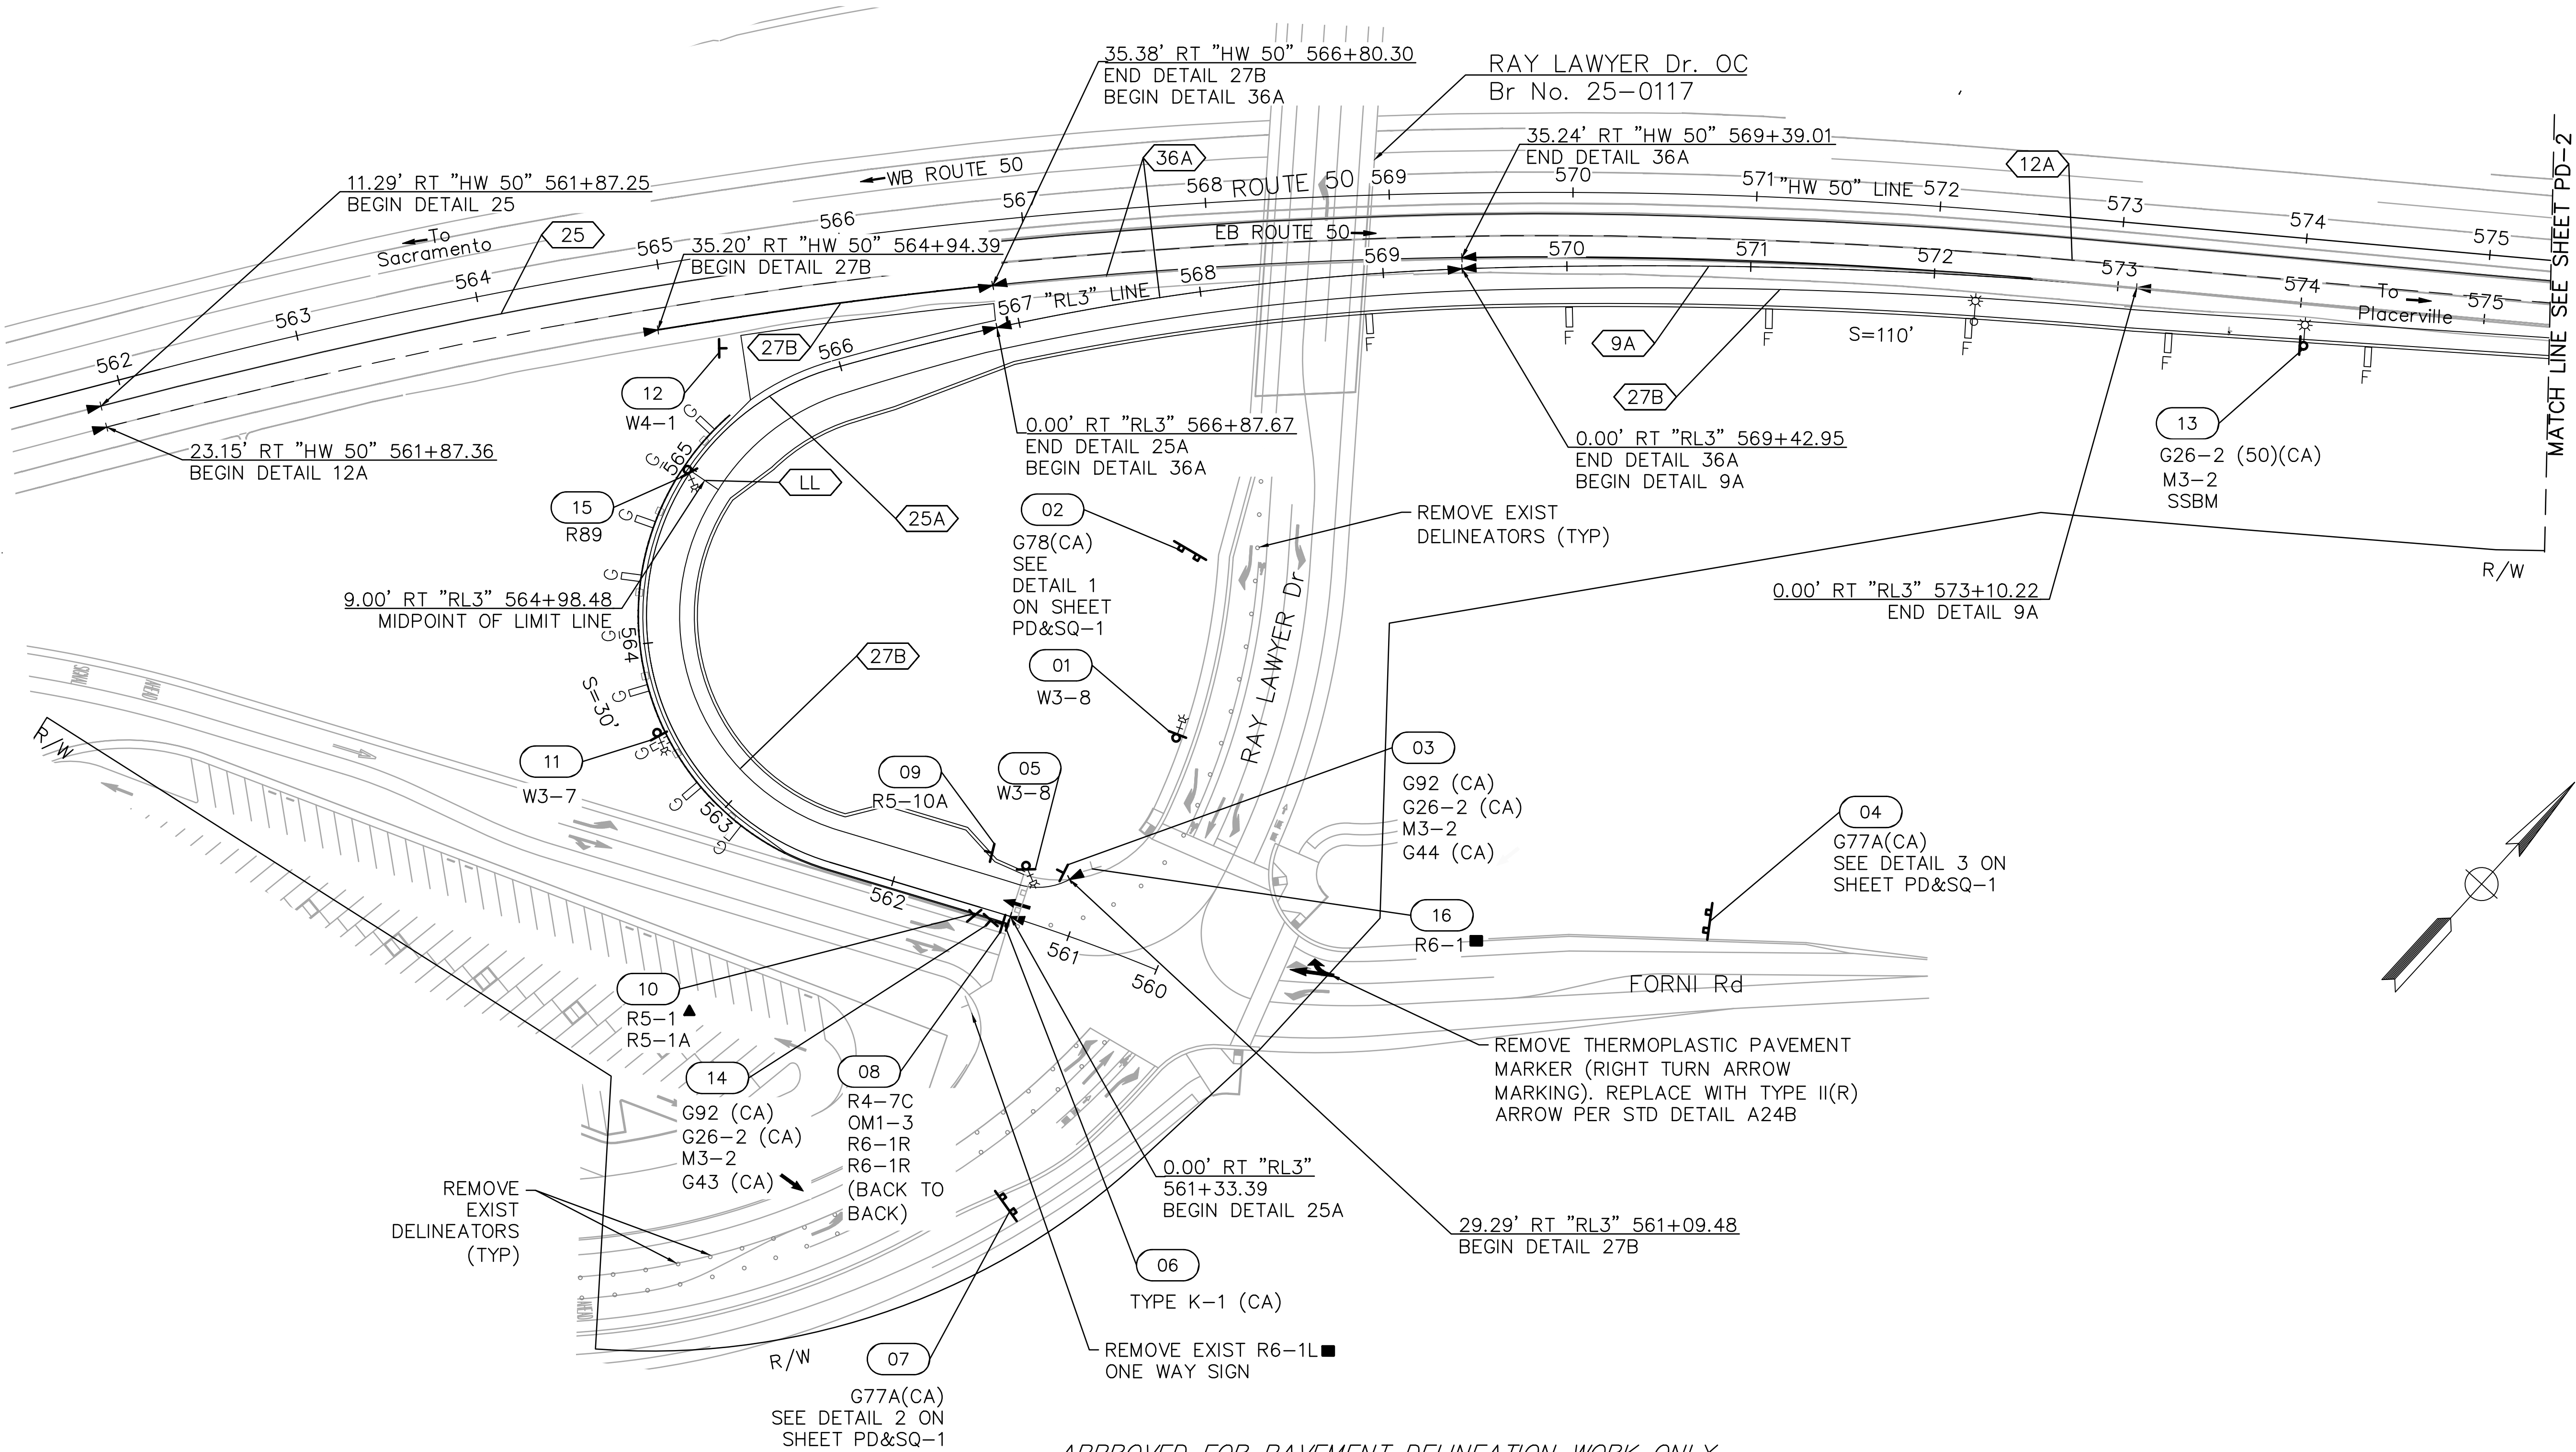

APPROVED FOR PAVEMENT DELINEATION WORK ONLY

PAVEMENT DELINEATION & SIGNS

SCALE: 1" = 50'

PD-1

STATE OF CALIFORNIA

Caltrans

CONSULTANT FUNCTIONAL SUPERVISOR

AARON BRUSATORI, PE

CALCULATED—
DESIGNED BY

CHECKED BY

VERONICA GARCIA—MCGREW

AARON S. BRUSATORI

REVISED BY

DATE REVISED

NOTE:

1. FOR ACCURATE RIGHT OF WAY DATA, CONTACT RIGHT OF WAY ENGINEERING AT THE DISTRICT OFFICE.
2. SEE SHEET E-5 FOR SIGN CHANGES ON EXISTING MAST ARMS AT RAY LAWYER DRIVE INTERSECTION

Dist	COUNTY	ROUTE	POST MILES TOTAL PROJECT	SHEET No.	TOTAL SHEETS
03	ED	50	16.4/16.8	29	45

Aaron Brusatori

REGISTERED CIVIL ENGINEER

8-07-20

DATE

AUGUST 31, 2020

PLANS APPROVAL DATE

THE STATE OF CALIFORNIA OR ITS OFFICERS
OR AGENTS SHALL NOT BE RESPONSIBLE FOR
THE ACCURACY OR COMPLETENESS OF SCANNED
COPIES OF THIS PLAN SHEET.

R.E.Y. ENGINEERS
905 SUTTER STREET, SUITE 200
FOLSOM, CA 95630

CITY OF PLACERVILLE
ENGINEERING DEPARTMENT
3101 CENTER STREET
PLACERVILLE, CA 95667

REGISTERED PROFESSIONAL ENGINEER

AARON BRUSATORI

No. 64384

Exp. 6/30/21

CIVIL

STATE OF CALIFORNIA

APPROVED FOR PAVEMENT DELINEATION WORK ONLY

PAVEMENT DELINEATION & SIGNS

SCALE: 1" = 50'

PD-2

BORDER LAST REVISED 7/2/2010

USERNAME => VGMCGREW
CAD FILE => 6884.009 STRIPE AND SIGNS.DWG

RELATIVE BORDER SCALE
IS IN INCHES

0 1 2 3

UNIT

PROJECT NUMBER & PHASE

03190001521

DATE PLOTTED => 10/4/2020
TIME PLOTTED => 11:31 AM

STATE OF CALIFORNIA – DEPARTMENT OF TRANSPORTATION



CONSULTANT FUNCTIONAL SUPERVISOR

AARON BRUSATORI, PE

CALCULATED—
DESIGNED BY

CHECKED BY

VERONICA GARCIA—MCGREW

AARON S. BRUSATORI

REVISED BY

DATE REVISED

03

 
ED

50

16.4/16.8


30

45


REGISTERED CIVIL ENGINEER

8-07-20
DATE

AUGUST 31, 2020
PLANS APPROVAL DATE

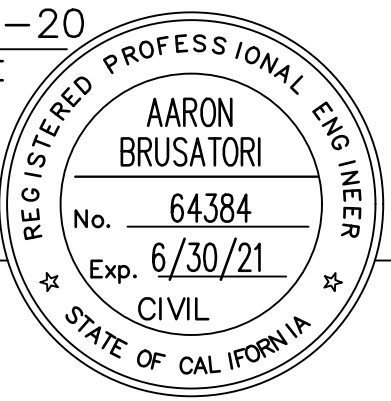

R.E.Y. ENGINEERS
905 SUTTER STREET, SUITE 200
FOLSOM, CA 95630

CITY OF PLACERVILLE
ENGINEERING DEPARTMENT
3101 CENTER STREET
PLACERVILLE, CA 95667

REMARKS	SHEET NUMBER	LINE	STATION	RT/LT	DETAIL NO.	THERMOPLASTIC TRAFFIC STRIPE (EWNV)			PAVEMENT MARKER (RETROREFLECTIVE-- RECESSED)		DELINEATORS		REMOVE DELINEATORS	REMOVE THERMOPLASTIC PAVEMENT MARKING	THERMOPLASTIC PAVEMENT MARKING (EWNV)	DESCRIPTION
						6 IN WHITE	6 IN YELLOW	8 IN WHITE	TYPE C	TYPE RY	CLASS 1	GUARD RAILING				
						(LF)	(LF)	(LF)	(EA)	(EA)	(EA)	(EA)	(EA)	(SQFT)	(SQFT)	
	PD-1 / PD-2	"HW 50"	561+87.25 TO 588+26.49	RT	25		2628			56						
	PD-1 / PD-2	"HW 50"	561+87.36 TO 588+26.49	RT	12A	2616			55							
	PD-1	"RL3"	562+91 TO 565+22	LT								9				TYPE G
	PD-1	"RL3"	FORNI RD ON WB LEG	RT										42	45	TYPE II (R) ARROW
	PD-1	"RL3"	561+33.39 TO 566+87.67	RT/LT	25A		555			35						
	PD-1 / PD-2	"RL3"	561+09.48 TO 588+26.49	RT	27B	2649										
	PD-1	"RL3"	561+24.74 TO 561+48.57	RT											31	TYPE I (24') ARROW
	PD-1	"RL3"	564+98.48	RT											18	LIMIT LINE
	PD-1	"HW 50"	564+94.39 TO 566+80.30	RT	27B	184										
	PD-1	"HW 50"	566+80.30 TO 569+39.01	RT	36A			256	11							
	PD-1	"RL3"	566+87.67 TO 569+42.95	RT/LT	36A			256	11							
	PD-1 / PD-2	"HW 50"	568+87 TO 577+65	RT							9					TYPE F
	PD-1	"RL3"	569+42.95 TO 573+10.22	RT	9A	368			8							
	PD-1	"RL3"	560+50	RT/LT									45			REMOVE DELINEATORS ON RAY LAWYER DR AND FORNI RD
	TOTAL					5817	3183	512	85	91	9	9	45	42	94	

PAVEMENT DELINEATION
QUANTITIES

PDQ-1

DATE PLOTTED => 10/4/2020
TIME PLOTTED => 11:31 AM

NOTE:

1. EXACT LOCATION AND POSITION OF ROADSIDE SIGNS TO BE DETERMINED BY THE ENGINEER.
2. POST LENGTHS GIVEN ARE APPROXIMATE.
3. "C" DIM=VERTICAL
4. SIGN NUMBERS DESIGNATED BY (C) CORRESPOND TO MAST ARM POSTS ON SHEET E–5.

ROADSIDE SIGN QUANTITIES

SHEET NO.	SIGN NO.	SIGN CODE		PANEL SIZE		FURNISH SINGLE SHEET ALUMINUM SIGN	C' DIM	POST SIZE AND LENGTH			ROADSIDE SIGN		INSTALL SIGN (STRAP & SADDLE BRACKET METHOD)	RESET ROADSIDE SIGN	REMOVE ROADSIDE SIGN	REMARKS
				HORIZ	VERT			4" X 4"	4" X 6"	6" X 6"	ONE POST	TWO POST				
		FEDERAL	CALIFORNIA	IN X IN		SQFT	FT	FT			EA	EA	EA	EA		
	01	W3–8		36	36	9	7				1					MOUNT ON FLASHING BEACON
	02		G78(CA)	120	48	40	2			16		1				
	03		G92 (CA)	48	30	10			14		1					
			G26–1 (CA)	28	24	4.66										
		M3–2		24	12	2										
			G44(CA)	21	15	1.25				14		1				
	04		G77A(CA)	90	90	56.25	7									
	05	W3–8		36	36	9	7				1					MOUNT ON ELECTROLIER
	06	OM2–1H		12	6	0.5	4									INSTALL ON FLEXIBLE POST
	07		G77A(CA)	90	90	56.25	7			14		1				
	8	R4–7C		18	30	3.75	4	12			1					
		OM 1–3		18	18	2.25										
		R6–1R		36	12	3										
		R6–1R		36	12	3										R6–1 SIGNS TO BE BACK TO BACK
	09	R5–10A		30	36	7.5	5	10			1					
	10	R5–1		36	36	-								1		
		R5–1A		36	24	-	2									DO NOT ENTER, WRONG WAY SIGNS ARE EXISTING. TO BE REMOVED DURING CONSTRUCTION OF CONCRETE MEDIAN AND RESET IN THEIR ORIGINAL LOCATION.
	11	W3–7		36	36	9	7				1					MOUNT ON FLASHING BEACON
	12	W4–1		36	36	9	7			18	1					
	13		G26–2(50)(CA)	30	30	6.25							1			
		M3–2		30	15	3.13										MOUNT ON FLASHING BEACON
	14		G92 (CA)	48	30	10	2		14		1					
			G26–1 (CA)	28	24	4.66										
		M3–2		24	12	2										
			G43(CA)	21	15	2.19										
	15	R89		24	6	12		12			1					
	16	R6–1		36	12	-									1	REMOVE EXIST R6–1
E–5	(a)		R61–5.1(CA)	36	30	7.50									1	REMOVE EXISTING R61–19(CA) SIGN AND MOUNT NEW SIGN ON MAST ARM
E–5	(d)		R73–3(CA)	24	24	4.00									1	REMOVE EXISTING R3–18 SIGN AND MOUNT NEW SIGN ON MAST ARM
TOTAL						271.15					9	3	1	1	3	

STATE OF CALIFORNIA – DEPARTMENT OF TRANSPORTATION	CONSULTANT FUNCTIONAL SUPERVISOR					
Caltrans		AARON BRUSATORI, PE	CALCULATED– DESIGNED BY	VERONICA GARCIA–MCGREW	REVISED BY	
			CHECKED BY	AARON S. BRUSATORI	DATE REVISED	

AGGREGATE BASE (CLASS 2)					
SHEET NUMBER	LINE	STATION	SQFT (N)	CUFT (N)	CUYD
L-1/L-2	"RL3"	561+50.54 – 578+53.66	47,464	68,823	2,549
L-1	"BR"	1+04.32 – 2+82.74	2,061	687	26

HOT MIX ASPHALT (TYPE A)

SHEET NUMBER	LINE	STATION	SQFT (N)	TON
L-1/L-2	"RL3"	561+33.39 – 578+53.66	50,164	1,256
D-1	"RL3"	563+27.73 – 564+32.87	900	22
D-2	"RL3"	544+65.50 – 565+32.68	585	14

PLACE HOT MIX ASPHALT (MISCELLANEOUS AREAS)

SHEET NUMBER	LINE	STATION	SQFT (N)	SQYD	NOTES
L-1	"RL3"	565+48.31 – 566+88.73	2,596	289	HMA (TEXTURED PAVING)
D-1	SEE SHEET DQ-1 FOR HMA DITCH QUANTITIES				

COLD PLANE ASPHALT CONCRETE PAVEMENT

SHEET NUMBER	LINE	STATION	SQFT (N)	SQYD
L-1/L-2	"RL3"	565+35.40 – 578+53.66	2,700	300

EARTHWORK

LINE	ROADWAY EXCAVATION	REMOVE BASE AND SURFACING	EXPORT
	CY	CY	CY
RL3	32,748	898	17,606

EARTHWORK (N)

LINE	ROADWAY EXCAVATION	
	CY	
	CUT	FILL
RL3 Sta 561+33 – 570+20	22,830	3,500
RL3 Sta 570+20 – 573+60	0	11,642
RL3 Sta 573+60 – 577+70	9,918	0

WATER POLLUTION CONTROL QUANTITIES

TEMPORARY HYDRAULIC MULCH	TEMPORARY DRAINAGE INLET PROTECTION	STABILIZED CONSTRUCTION ENTRANCE	SHEET
SQYD	EA	EA	
14,050	7	3	WPC-1 / WPC-2

PLACE HMA DIKE

SHEET NUMBER	LINE	RT/LT	STATION	TYPE D	TYPE A
				(LF)	(LF)
L-1	"RL3"	RT	561+33.39 – 570+02.00	804	
L-1 / L-2	"RL3"	RT	570+02.00 – 573+29.16		326
L-2	"RL3"	RT	573+29.16 – 578+53.78	523	

MISCELLANEOUS ITEMS

SHEET NUMBER	LINE	RT/LT	STATION	TEMPORARY FENCE (TYPE ESA)	SUBGRADE ENHANCEMENT GEOGRID	REMOVE TREE
				(LF)	(SQYD)	(EA)
CG-1	"RL3"	RT	569+50.16 – 571+49.00	310		
CG-2	"RL3"	RT	572+25.85 – 573+89.29	208		
CG-2	"RL3"	RT	576+28.75 – 577+65.30	161		
L-1	"BR"	LT	1+04.32 – 2+82.74		214	
L-1 / L-2	-	-	-			80

MINOR CONCRETE (CURB)

SHEET NUMBER	LINE	RT/LT	STATION	TYPE A1-6
				(LF)
L-1	"RL3"	LT	561+33.39 – 562+60.00	128

MIDWEST GUARDRAIL SYSTEM

SHEET NUMBER	LINE	RT/LT	STATION	MIDWEST GUARDRAIL SYSTEM (WOOD POST)	ALTERNATIVE IN-LINE TERMINAL SYSTEM	END ANCHOR ASSEMBLY (TYPE SFT)
				(LF)	(EA)	(EA)
L-1	"RL3"	LT	562+60.00 – 565+34.85	284	1	1

(N) NOT A SEPARATE PAY ITEM, FOR INFORMATION ONLY

DIST	COUNTY	ROUTE	POST MILES TOTAL PROJECT	SHEET No.	TOTAL SHEETS
03	ED	50	16.4/16.8	33	45
 <u>REGISTERED CIVIL ENGINEER</u>			<u>8-07-20</u> DATE		
<u>AUGUST 31, 2020</u> <u>PLANS APPROVAL DATE</u>			<i>THE STATE OF CALIFORNIA OR ITS OFFICERS OR AGENTS SHALL NOT BE RESPONSIBLE FOR THE ACCURACY OR COMPLETENESS OF SCANNED COPIES OF THIS PLAN SHEET.</i>		
R.E.Y. ENGINEERS 905 SUTTER STREET, SUITE 200 FOLSOM, CA 95630			CITY OF PLACERVILLE ENGINEERING DEPARTMENT 3101 CENTER STREET PLACERVILLE, CA 95667		

CONCRETE

SHEET NUMBER	LINE	RT/LT	STATION	SLOPE PAVING (CONCRETE)	
				SQFT (N)	CY
L-1	"RL3"	RT	568+28.24 – 568+88.00	1,412	20

**RUBBERIZED HOT MIX
ASPHALT (GAP GRADED)**

SHEET NUMBER	LINE	STATION	SQFT (N)	TON
L-1/L-2	"RL3"	561+33.39 – 578+53.66	49,082	736

SUMMARY OF QUANTITIES

NO SCALE

Q-1

STATE OF CALIFORNIA – DEPARTMENT OF TRANSPORTATION

CH2M HILL

CONSULTANT FUNCTIONAL SUPERVISOR

DANIEL K. YAU

CALCULATED – DESIGNED BY

CHECKED BY

MENG YANG

KIN Y. CHAN

REVISED BY

DATE REVISED

INDEX OF ELECTRICAL SYSTEMS PLANS:

SHEET	DESCRIPTION
E-1	INDEX OF ELECTRICAL SYSTEMS PLANS, NOTES, LEGEND, ABBREVIATIONS
E-2	RAMP METERING SYSTEM
E-3 TO E-4	MODIFYING LIGHTING SYSTEMS
E-5 TO E-6	MODIFYING SIGNAL AND LIGHTING SYSTEMS
ED-1 TO ED-5	ELECTRICAL SYSTEMS DETAILS
EQ-1	ELECTRICAL SYSTEMS QUANTITIES

NOTES:

1. PRIOR TO ANY WORK ON PG&E SERVICE POINT, THE CONTRACTOR MUST NOTIFY THE ENGINEER.
2. SEE SHEET ED-3 FOR TRAFFIC RATED PULL BOX DETAILS.

ABBREVIATIONS:

AT&T	AMERICAN TELEPHONE AND TELEGRAPH
EVUDa	EMERGENCY VEHICLE UNIT DETECTOR (CHANNEL a)
PG&E	PACIFIC GAS & ELECTRIC
TC	TELEPHONE CABLE

SYMBOLS:

EXISTING	NEW	DESCRIPTION
		DIRECT BURIED CABLE
		TYPE 1-D Std WITH RAMP METER SIGNALS

INDEX OF ELECTRICAL SYSTEMS PLANS, NOTES, LEGEND, ABBREVIATIONS

ELECTRICAL SYSTEMS

E-1

Dist	COUNTY	ROUTE	POST MILES TOTAL PROJECT	SHEET No.	TOTAL SHEETS
03	ED	50	16.0/16.6	34	45

REGISTERED CIVIL ENGINEER

7-30-20

DATE

AUGUST 31, 2020

PLANS APPROVAL DATE

THE STATE OF CALIFORNIA OR ITS OFFICERS
OR AGENTS SHALL NOT BE RESPONSIBLE FOR
THE ACCURACY OR COMPLETENESS OF SCANNED
COPIES OF THIS PLAN SHEET.

REGISTERED PROFESSIONAL ENGINEER

KIN Y. CHAN

No. 55391

Exp. 12-31-20

CIVIL

STATE OF CALIFORNIA

Y&C TRANSPORTATION
CONSULTANTS, INC.
3250 RAMOS CIRCLE
SACRAMENTO, CA 95827

CITY OF PLACERVILLE
PUBLIC WORKS
3101 CENTER STREET
PLACERVILLE, CA 95667


Dist	COUNTY	ROUTE	POST MILES TOTAL PROJECT	SHEET No.	TOTAL SHEETS
03	ED	50	16.0/16.6	35	45
 REGISTERED CIVIL ENGINEER 7-30-20 DATE  AUGUST 31, 2020 <u>PLANS APPROVAL DATE</u> <i>THE STATE OF CALIFORNIA OR ITS OFFICERS OR AGENTS SHALL NOT BE RESPONSIBLE FOR THE ACCURACY OR COMPLETENESS OF SCANNED COPIES OF THIS PLAN SHEET.</i> Y&C TRANSPORTATION CONSULTANTS, INC. 3250 RAMOS CIRCLE SACRAMENTO, CA 95827 CITY OF PLACERVILLE PUBLIC WORKS 3101 CENTER STREET PLACERVILLE, CA 95667					


NOTE:

FOR ACCURATE RIGHT OF WAY DATA, CONTACT RIGHT OF WAY ENGINEERING AT THE DISTRICT OFFICE.

LEGEND:

- 1 INSTALL DEPARTMENT—FURNISHED MODEL 2070E CONTROLLER ASSEMBLY WITH MODEL 334 CABINET. FRONT DOOR MUST FACE EAST.
- 2 INSTALL EQUIPMENT OUTSIDE OF CLEAR RECOVERY ZONE.
- 3 INSTALL TYPE 1—D POLE WITH FB (YELLOW). SEE DETAIL A ON SHEET ED—2 FOR DETAILS.
- 4 INSTALL 4G (LTE) WIRELESS MODEM ASSEMBLY, ANTENNA, POWER SUPPLY, ETHERNET SWITCH AND TERMINAL BLOCK IN CABINET. SEE SHEETS ED—4 AND ED—5 FOR DETAILS.
- 5 INSTALL TYPE 1—B POLE WITH RM SIGNALS. SEE DETAIL SIG ON SHEET ED—2 FOR DETAILS.
- 6 SEE SHEET ED—1 FOR DETECTOR SPACING AND DESIGNATION DETAILS.
- 7 3"C, 2#6 (120 V RM), 2#8 (120 V FB), 9#14, 1#8 (N).
3"C, 12 DLC.
- 8 2"C, 9#14, 1#8 (N), 2#8 (240 V Ltg).
2"C, 10 DLC.

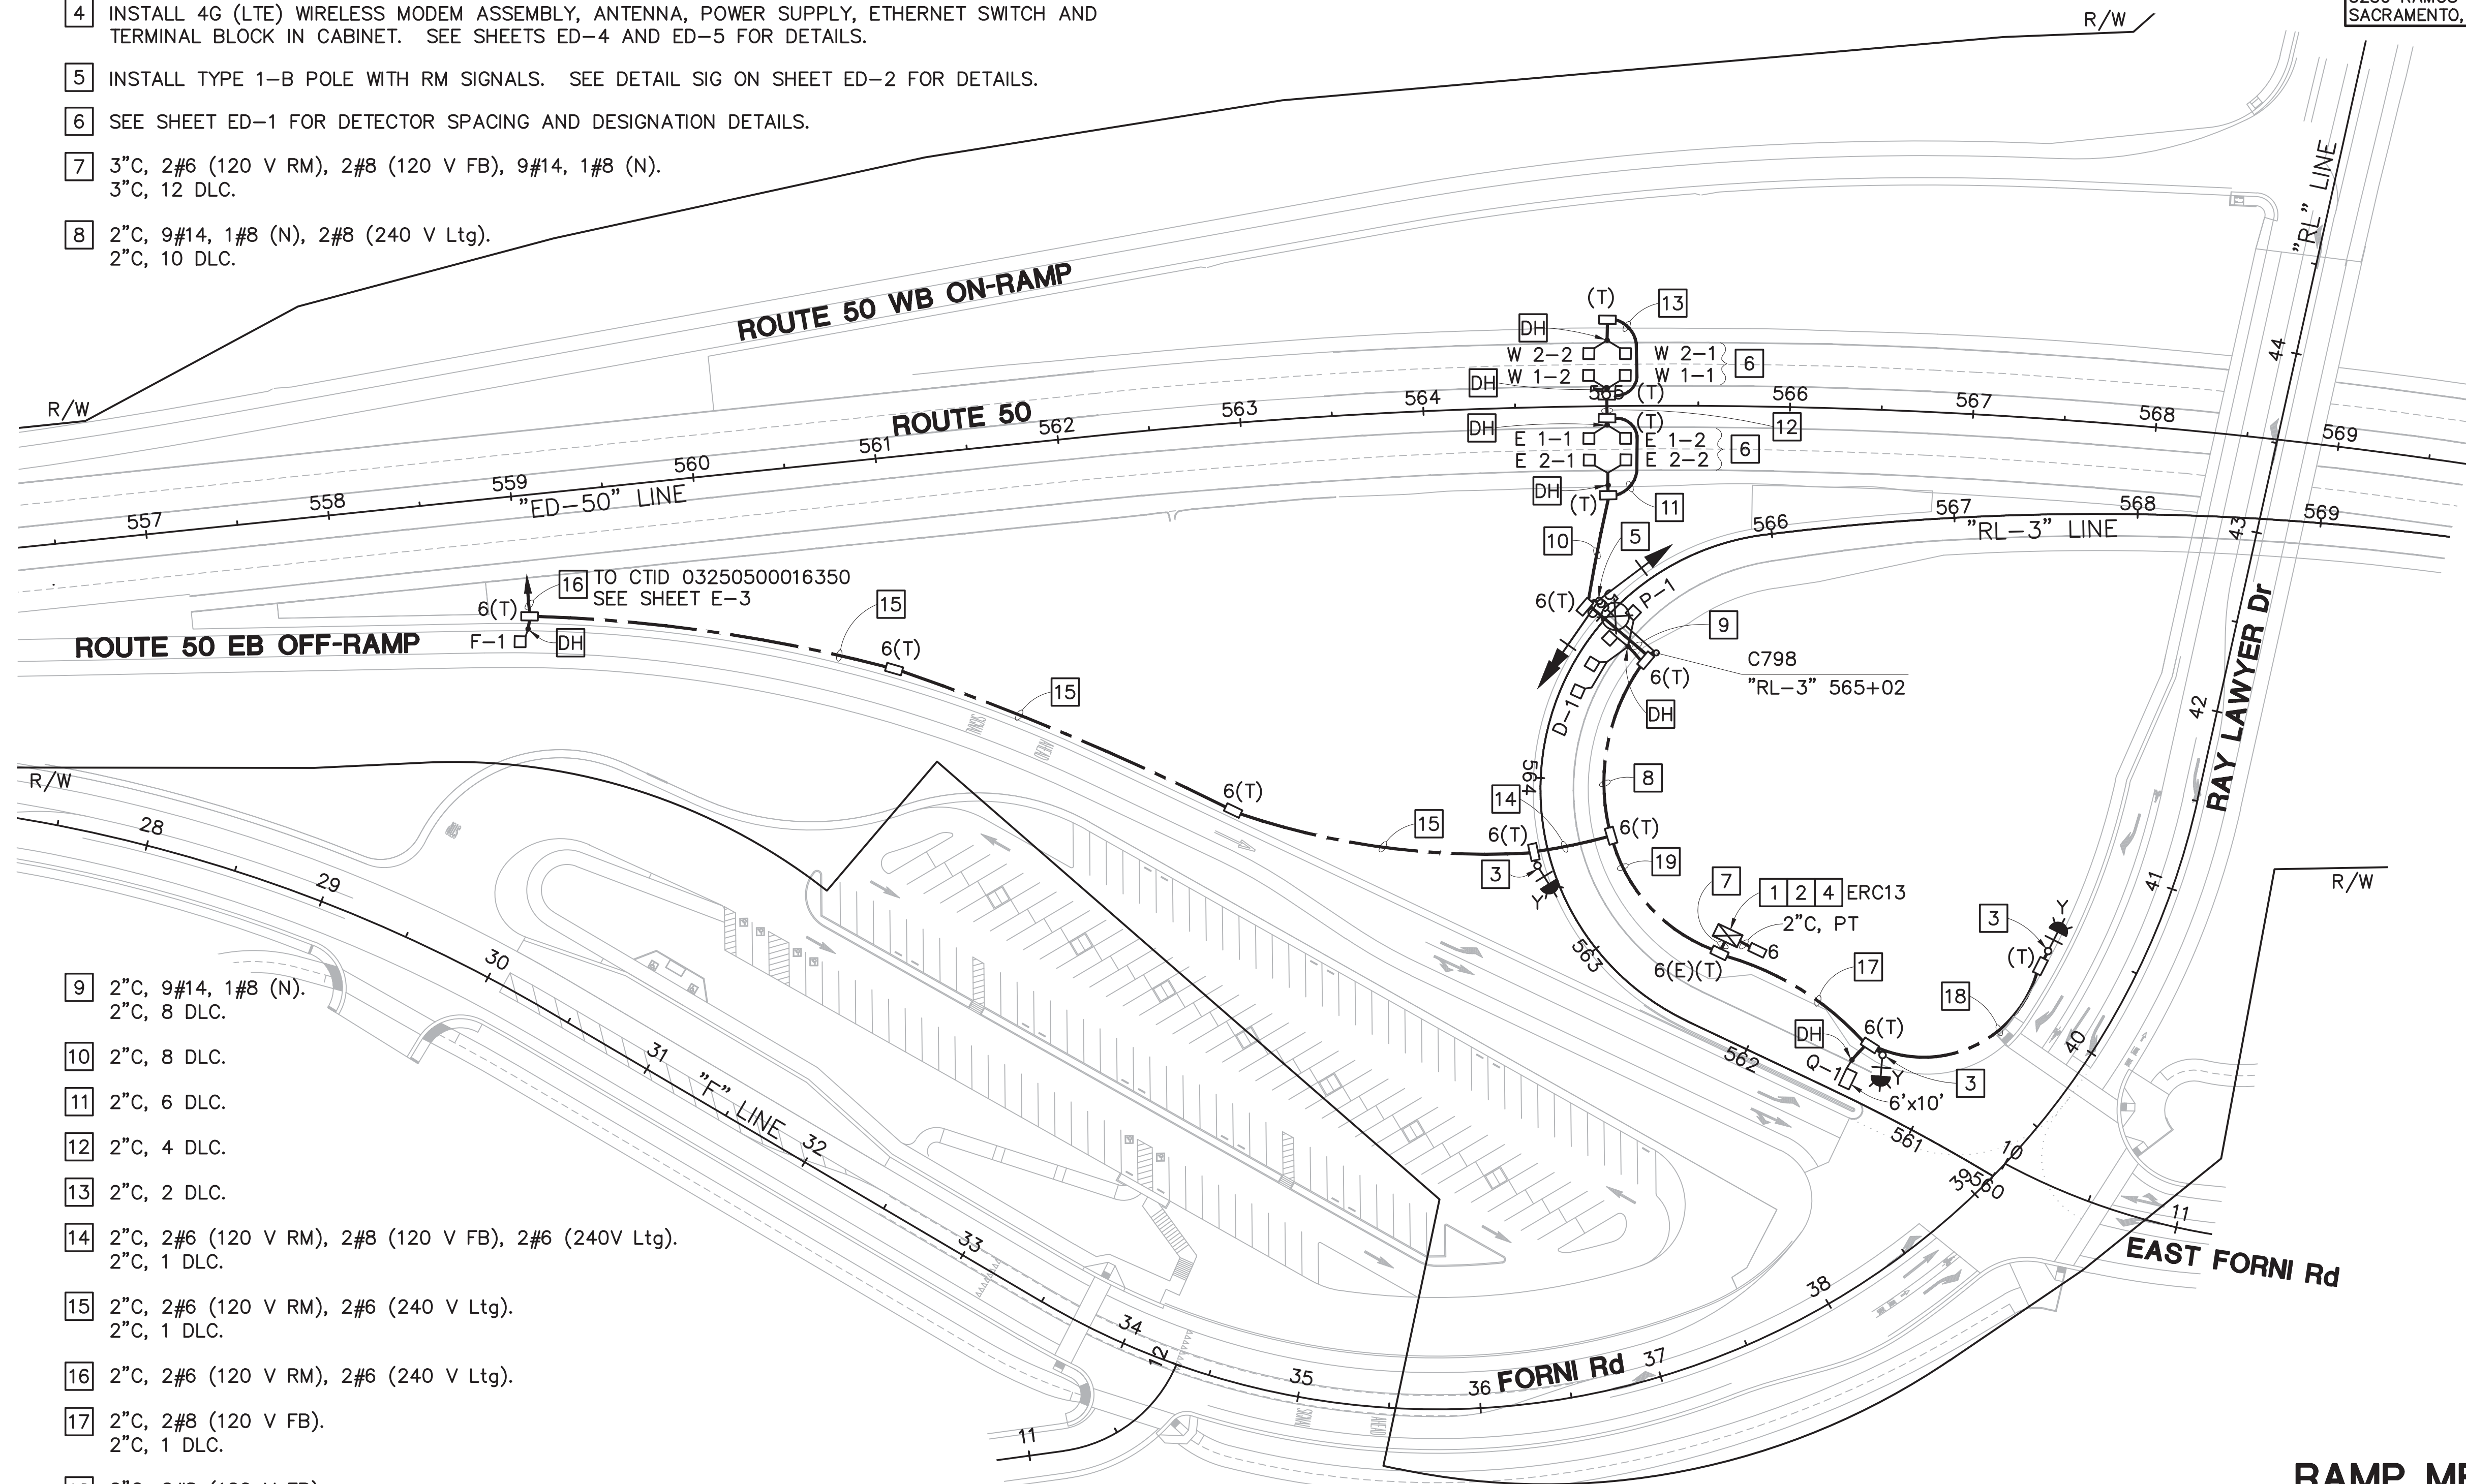

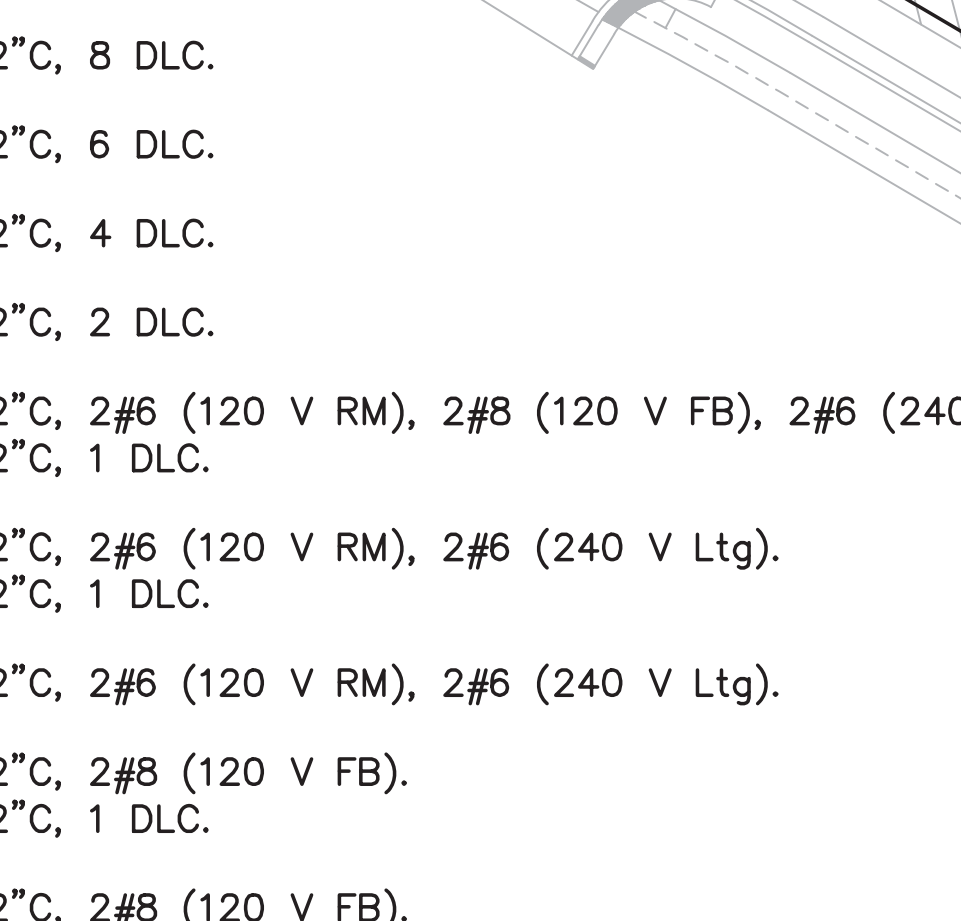

9 2°C, 9#14, 1#8 (N).
2°C, 8 DLC.

10 2°C, 8 DLC.

11 2°C, 6 DLC.

12 2°C, 4 DLC.

13 2°C, 2 DLC.

14 2°C, 2#6 (120 V RM), 2#8 (120 V FB), 2#6 (240V Ltg).
2°C, 1 DLC.

15 2°C, 2#6 (120 V RM), 2#6 (240 V Ltg).
2°C, 1 DLC.

16 2°C, 2#6 (120 V RM), 2#6 (240 V Ltg).

17 2°C, 2#8 (120 V FB).
2°C, 1 DLC.

18 2°C, 2#8 (120 V FB).

19 2°C, 2#6 (120 V RM), 9#14, 1#8 (N).
2°C, 11 DLC.

APPROVED FOR ELECTRICAL WORK ONLY

RAMP METERING SYSTEM

SCALE: 1" = 50'

E-2

STATE OF CALIFORNIA – DEPARTMENT OF TRANSPORTATION

CONSULTANT FUNCTIONAL SUPERVISOR

DANIEL K. YAU

CHECKED BY

DESIGNED BY

MENG YANG

KIN Y. CHAN

REVISED BY

DATE REVISED

NOTE:

FOR ACCURATE RIGHT OF WAY DATA, CONTACT RIGHT OF WAY ENGINEERING AT THE DISTRICT OFFICE.

LEGEND:

- 1 Exist DBC, 2#6 (240 V Ltg).
- 2 Exist DBC, 2#6 (240 V Ltg AND SIGN Ltg).
- 3 Exist DBC, 2#8 (240 V Ltg AND SIGN Ltg).
- 4 Exist 3"C, 2#6 (240 V Ltg AND SIGN Ltg).
- 5 Exist 2"C, 2#6 (240 V Ltg).

- 6 Exist 1½"C, 2#10 (120 V FB), 2#8 (SPARE). ADD 2#6 (240 V Ltg).
- 7 2"C, 2#6 (120 V RM), 2#6 (240 V Ltg).
- 8 Exist 3"C, 2#6 (240 V Ltg AND SIGN Ltg), 2#10 (120 V FB). ADD 2#6 (240 V Ltg), 2#6 (120 V RM).
- 9 Exist 3"C, 2#6 (240 V Ltg), 2#6 (240 V Ltg AND SIGN Ltg), 2#10 (120 V FB). ADD 2#6 (120 V RM).
- 10 Exist 3"C, 2#6 (240 V Ltg), 2#6 (240 V Ltg AND SIGN Ltg), 2#10 (120 V FB), 3#14 (PEU). ADD 2#6 (120 V RM).
- 11 Exist 2"C, 3#2 (SERVICE).
- 12 Exist 3"C, SERVICE CONDUCTORS TO REMAIN.
- 13 ADD ONE 30 A, 1P, 120 V CB FOR NEW RM TO Exist SERVICE EQUIPMENT ENCLOSURE. ADD NAMEPLATE "RM".

13 Exist TYPE III-AF METERED SERVICE EQUIPMENT ENCLOSURE
SEE WIRING DIAGRAM ON SHEET E-4
CTID No. 03250500016350

PG&E SERVICE POINT (120/240 V)

Exist LOAD: 4-165 W LED Lum (METERED)
12-235 W LED Lum (METERED)
2-85 W ISL SIGN Ltg (METERED)
1-100 W LED FB (METERED)
16-150 W LED Lum (CITY) (METERED)
±200 W Irr (CITY) (METERED)

Mod LOAD: 4-165 W LED Lum (METERED)
14-235 W LED Lum (METERED)
2-85 W ISL SIGN Ltg (METERED)
1-100 W LED FB (METERED)
16-150 W LED Lum (CITY) (METERED)
±200 W Irr (CITY) (METERED)
1-500 W RM (METERED)

MODIFYING LIGHTING SYSTEMS
SCALE: 1" = 50'

APPROVED FOR ELECTRICAL WORK ONLY

BORDER LAST REVISED 7/2/2010

USERNAME => \$USER
DGN FILE => \$REQUEST

RELATIVE BORDER SCALE
IS IN INCHES



UNIT XXXX

PROJECT NUMBER & PHASE

03190001521

Dist	COUNTY	ROUTE	POST MILES TOTAL PROJECT	SHEET No.	TOTAL SHEETS
03	ED	50	16.0/16.6	36	45

REGISTERED CIVIL ENGINEER
7-30-20
DATE
AUGUST 31, 2020
PLANS APPROVAL DATE

Y&C TRANSPORTATION
CONSULTANTS, INC.
3250 RAMOS CIRCLE
SACRAMENTO, CA 95827

CITY OF PLACERVILLE
PUBLIC WORKS
3101 CENTER STREET
PLACERVILLE, CA 95667

LAST REVISION
07-30-20
DATE PLOTTED => \$DATE
TIME PLOTTED => \$TIME




STATE OF CALIFORNIA - DEPARTMENT OF TRANSPORTATION	CONSULTANT FUNCTIONAL SUPERVISOR	CALCULATED-DESIGNED BY	CHECKED BY	MENG YANG	KIN Y. CHAN	REVISED BY	DATE REVISED
DATE PLOTTED => \$DATE	TIME PLOTTED => \$TIME	LAST REVISION	07-30-20	E-4	PROJECT NUMBER & PHASE	03190001521	UNIT XXXX

NOTE:

FOR ACCURATE RIGHT OF WAY DATA, CONTACT RIGHT OF WAY ENGINEERING AT THE DISTRICT OFFICE.

LEGEND:

- 1 Exist 1½"C, 2#10 (120 V FB), 2#8 (SPARE). ADD 2#6 (240 V Ltg).
- 2 2"C, 2#6 (240 V Ltg).
- 3 Exist DBC, 2#8 (240 V Ltg AND SIGN Ltg).
- 4 Exist 1"C TYPE 1, 2#8 (240 V SIGN Ltg).

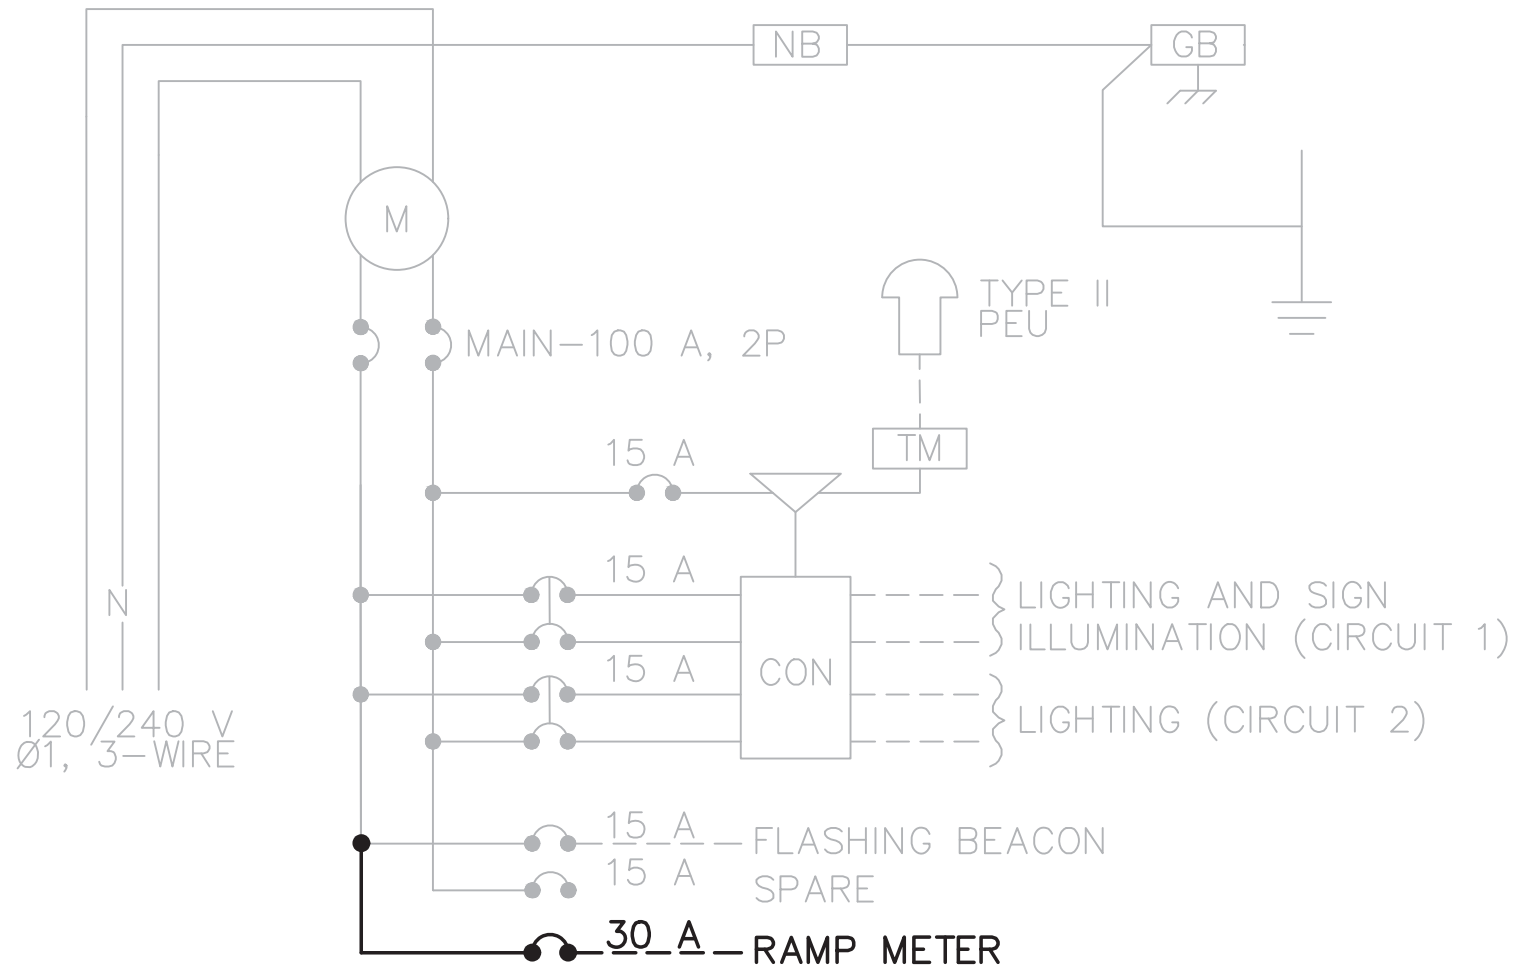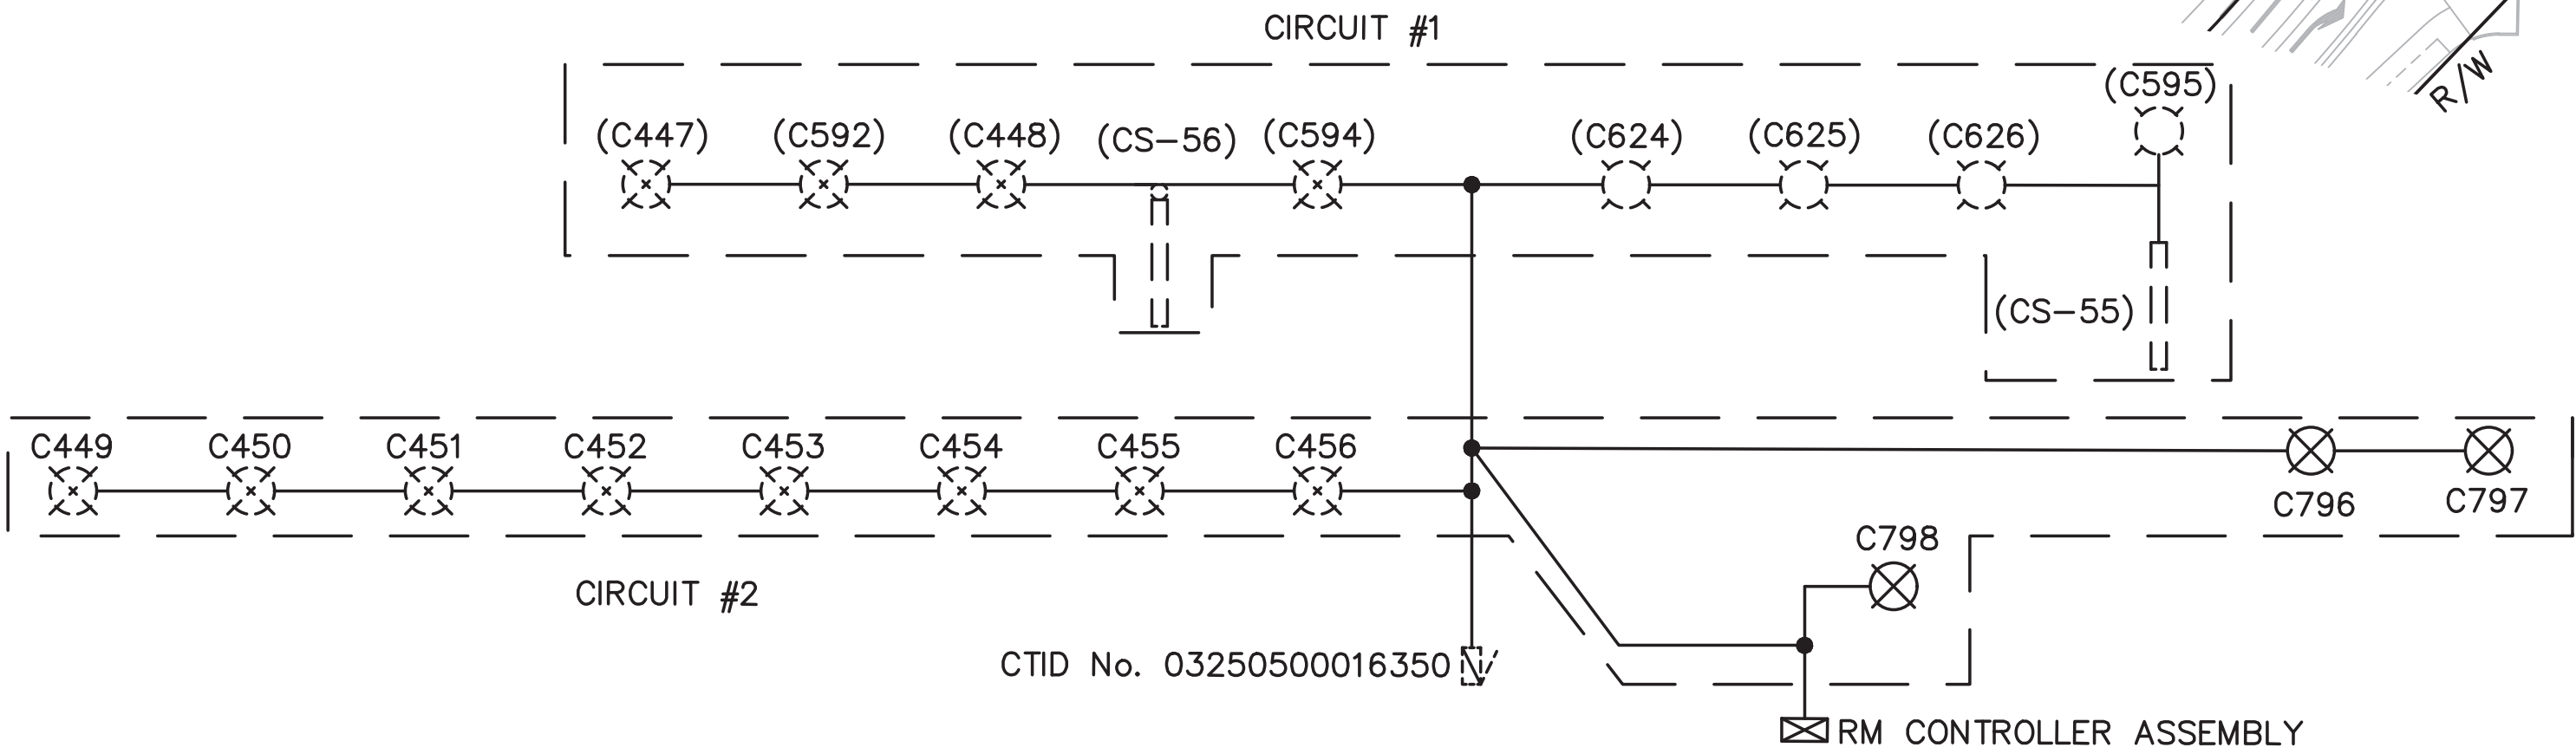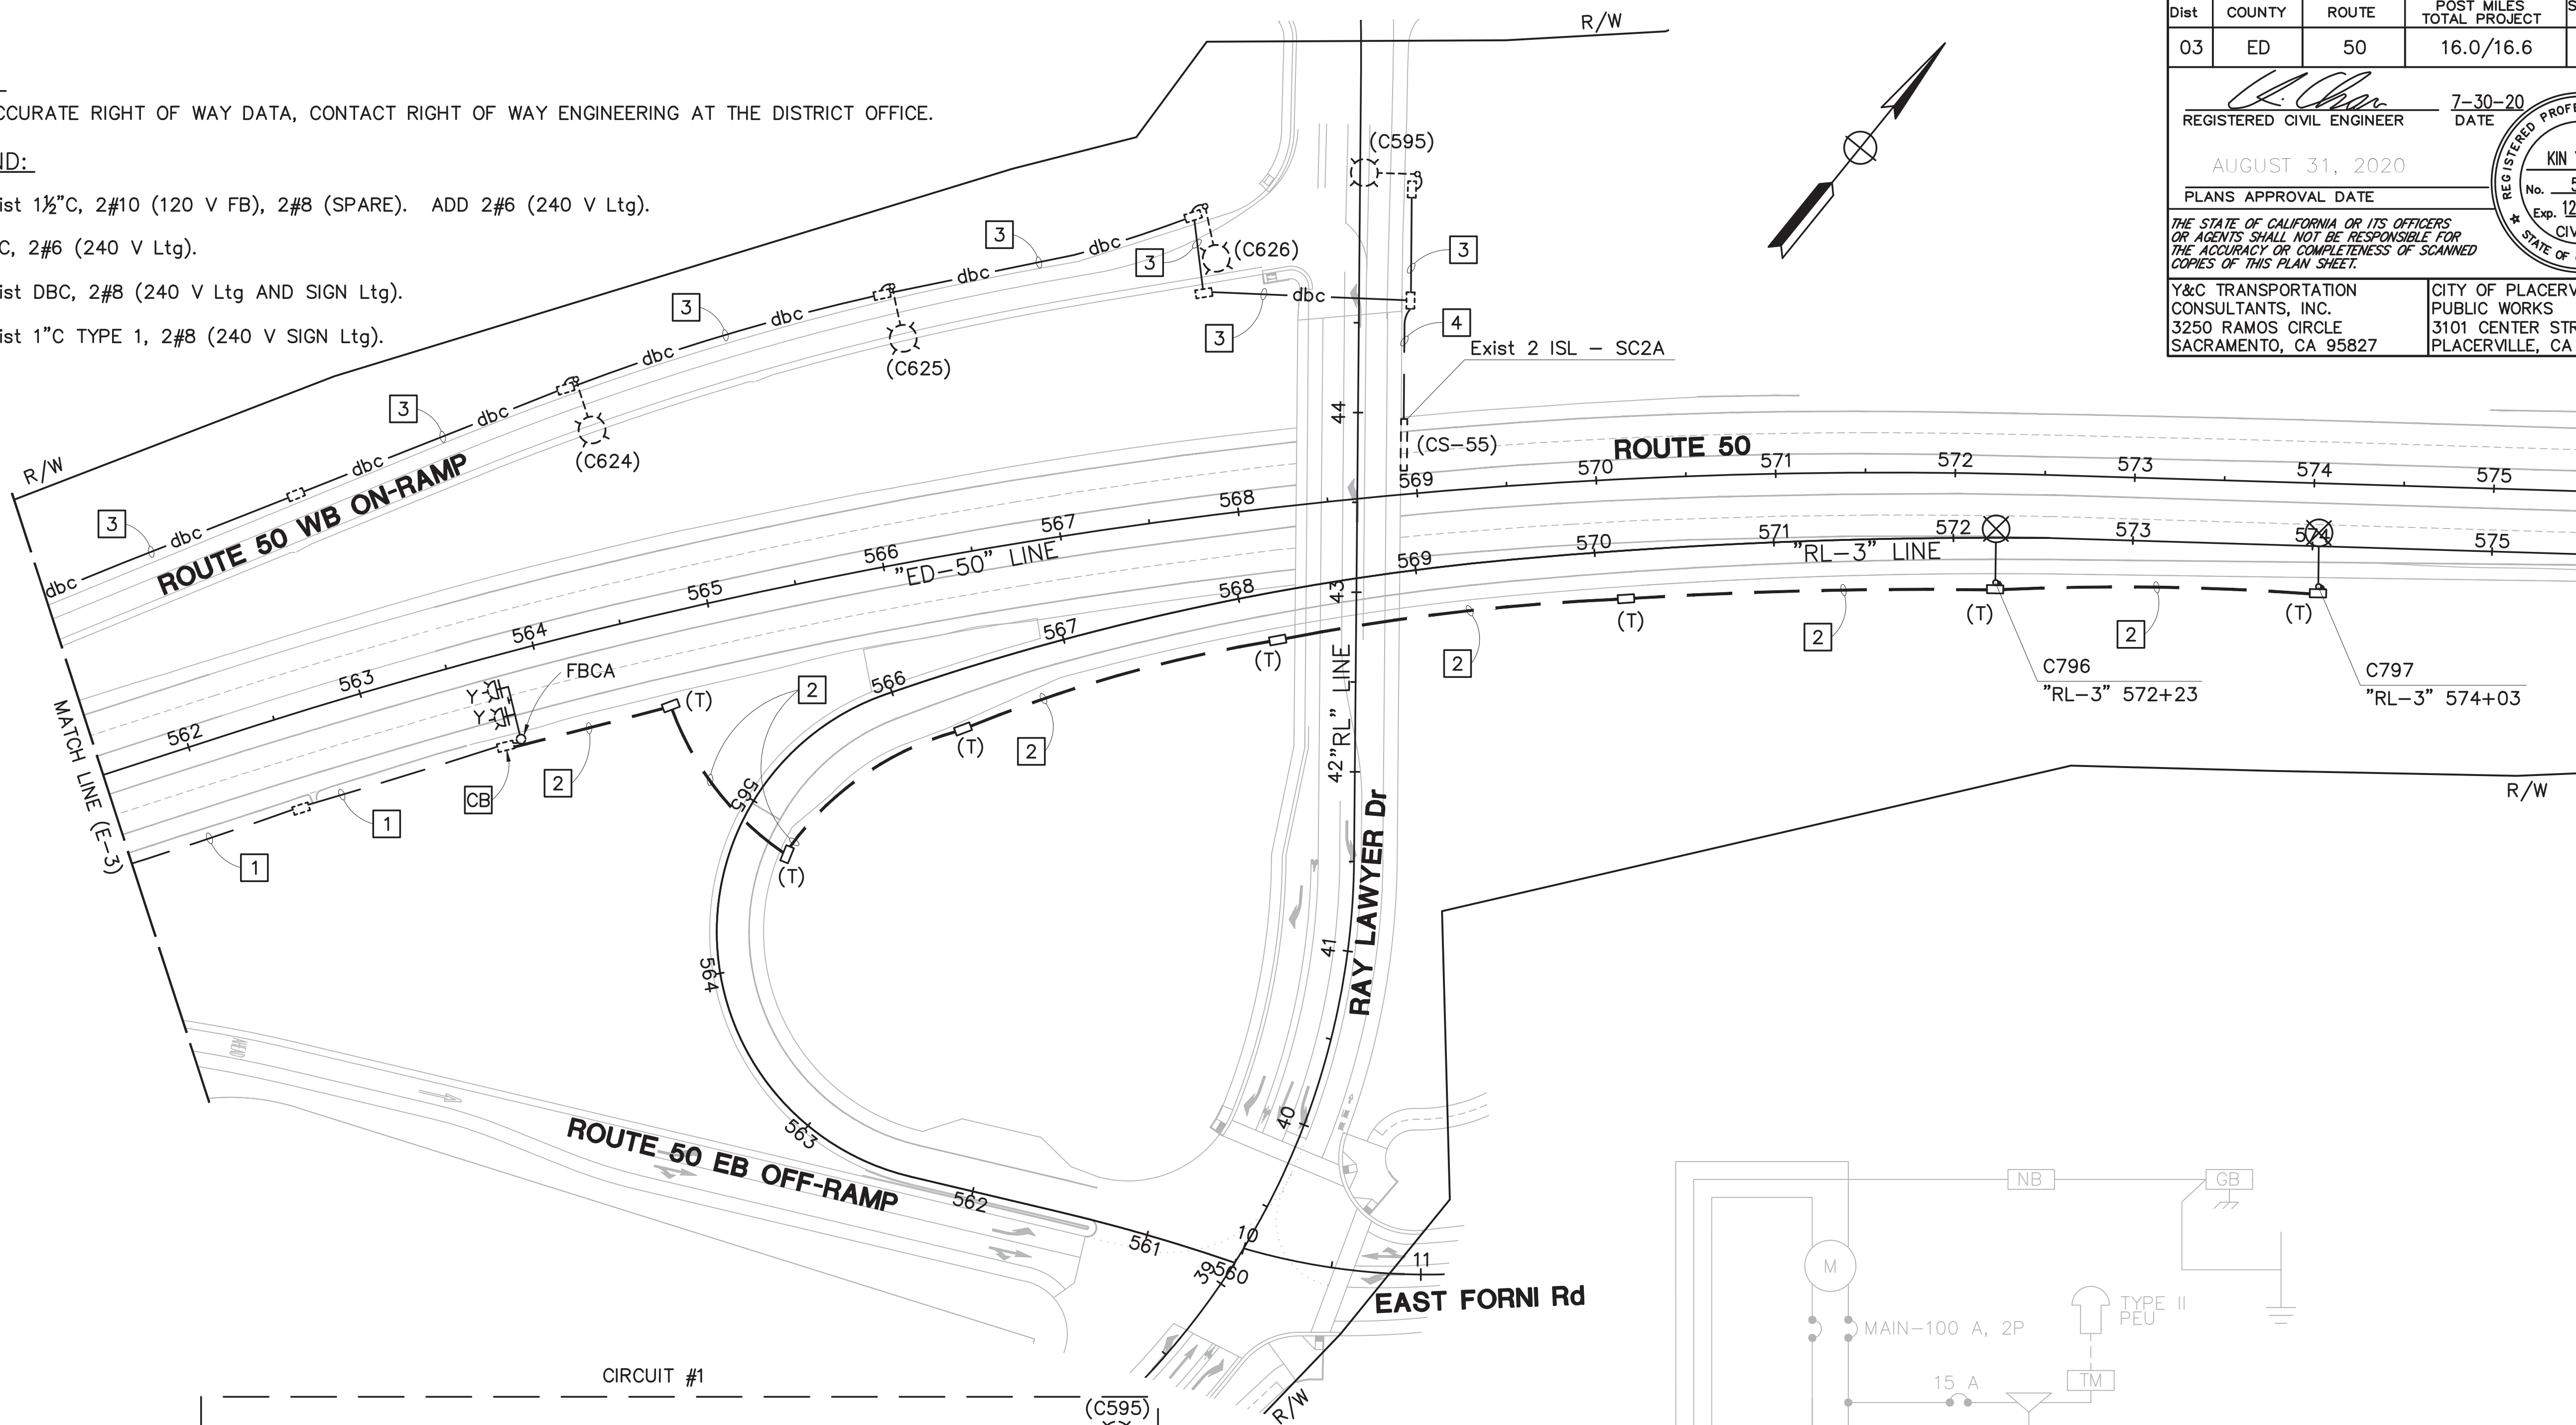

MODIFIED SERVICE WIRING DIAGRAM
CTID No. 03250500016350
NO SCALE

MODIFYING LIGHTING SYSTEMS
SCALE: 1" = 50'

APPROVED FOR ELECTRICAL WORK ONLY


NOTES:

1. FOR ACCURATE RIGHT OF WAY DATA, CONTACT RIGHT OF WAY ENGINEERING AT THE DISTRICT OFFICE.
2. SEE SHEET E-6 FOR SCHEDULES.

LEGEND:

- 1 INSTALL VEHICLE SIGNAL HEAD ON Exist TENON.
- 2 INSTALL VEHICLE SIGNAL HEAD ON Exist SIGNAL STANDARD.
- 3 EXISTING SIGN. R61-5.1 (CA).
- 4 Exist MODEL 2070 CONTROLLER ASSEMBLY WITH MODEL 342LX CABINET WITH BBS COMPONENT. RECONFIGURE CONTROLLER FOR PROPOSED TRAFFIC PHASE DIAGRAM.
- 5 CONNECT AND ACTIVATE Exist DLC WITH LOOP WIRES FOR 6J4L.
- 6 CONNECT AND ACTIVATE Exist DLC WITH LOOP WIRES FOR 5J1U.
- 7 Exist TYPE B TDC. COORDINATE WITH AT&T FOR SERVICE CONNECTION FOR NEW RM.
- 8 Exist 2"C, 1 TC.
- 9 INSTALL 4G (LTE) WIRELESS MODEM ASSEMBLY, ANTENNA, POWER SUPPLY, ETHERNET SWITCH AND TERMINAL BLOCK IN CABINET. SEE SHEETS ED-4 AND ED-5 FOR DETAILS.
- 10 Exist 2"C, 2#10 (120 V TDC).
- 11 Exist 2"C, TELEPHONE SERVICE CONDUCTORS TO REMAIN.
- 12 Exist 2"C, 1 DLC.
- 13 Exist 2"C, 3 DLC.

- 14 Exist 2"C, 4 DLC.
- 15 Exist 2"C, 5 DLC.
- 16 Exist 2"C, 2#6 (120 V Sig), 2#8 (240 V Ltg), 2#10 (120 V TDC), 3#14 (PEU).
- 17 Exist 2"C, 3#2 (SERVICE).
- 18 Exist SIGN. R73-3 (CA).
- AT&T UNDERGROUND SERVICE (TC No. 600)

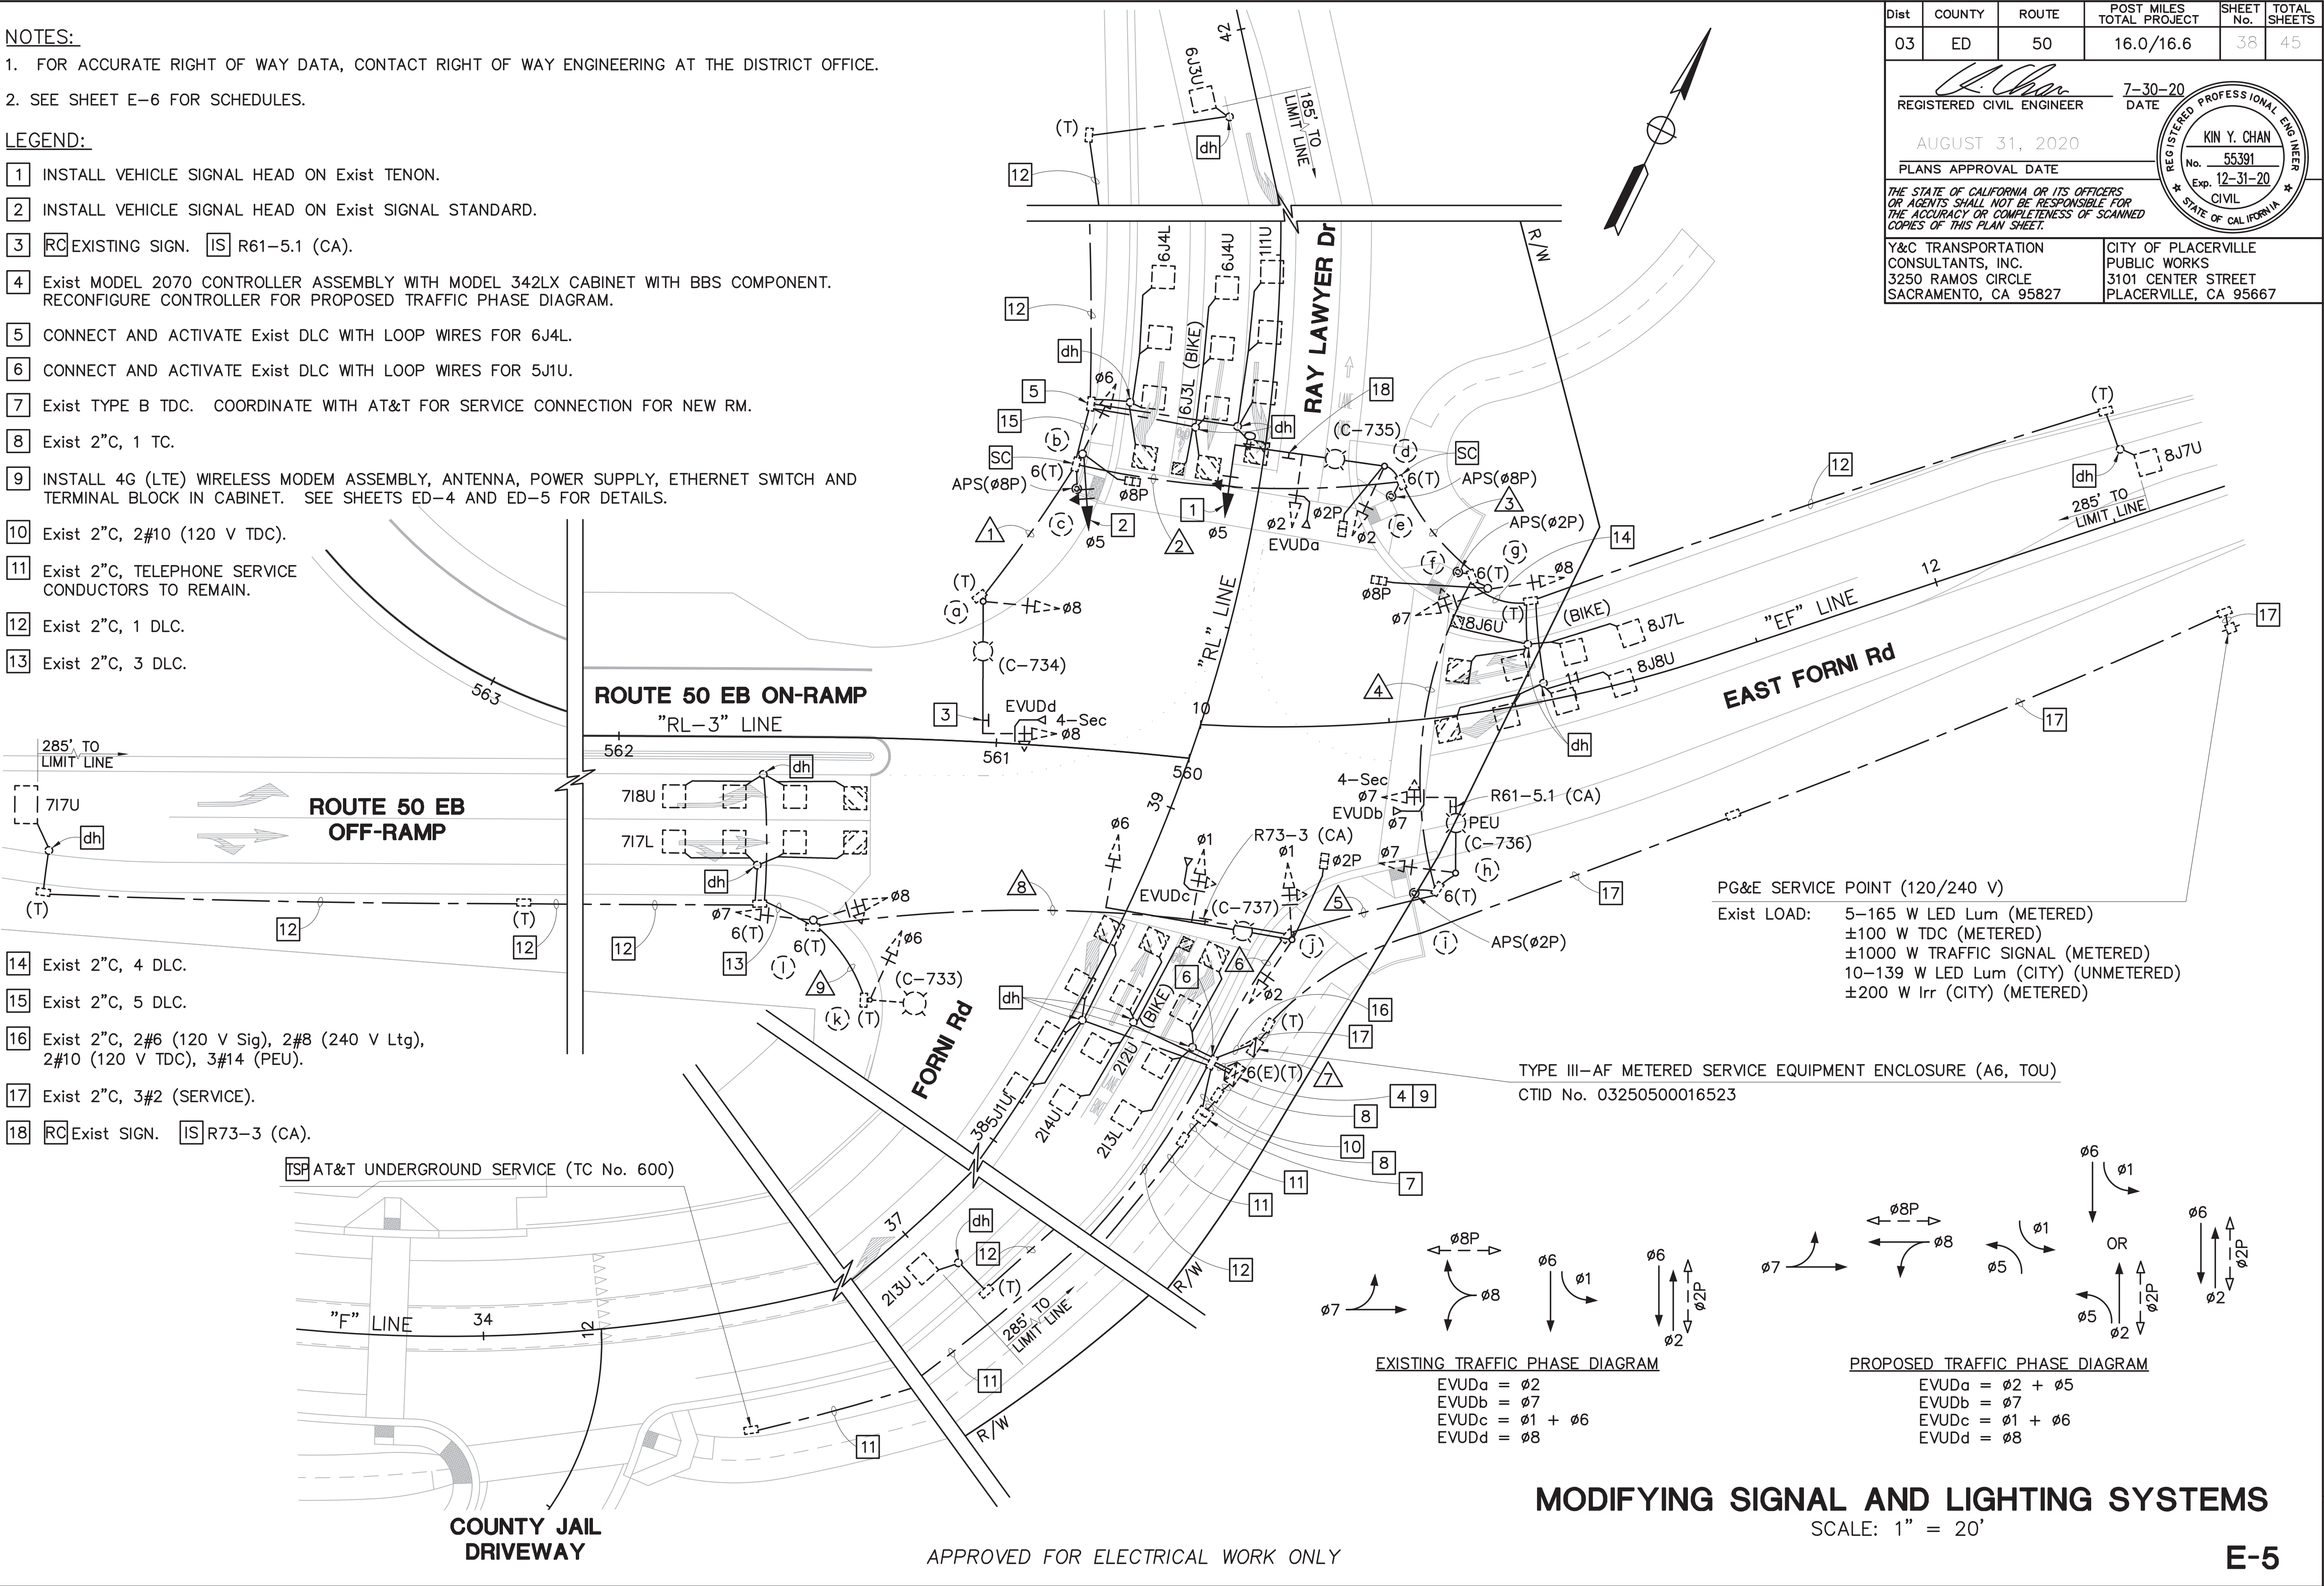

PG&E SERVICE POINT (120/240 V)
Exist LOAD: 5-165 W LED Lum (METERED)
±100 W TDC (METERED)
±1000 W TRAFFIC SIGNAL (METERED)
10-139 W LED Lum (CITY) (UNMETERED)
±200 W Irr (CITY) (METERED)

TYPE III-AF METERED SERVICE EQUIPMENT ENCLOSURE (A6, TOU)
CTID No. 03250500016523

EXISTING TRAFFIC PHASE DIAGRAM

EVUDa = Ø2
EVUDb = Ø7
EVUDc = Ø1 + Ø6
EVUDd = Ø8

PROPOSED TRAFFIC PHASE DIAGRAM

EVUDa = Ø2 + Ø5
EVUDb = Ø7
EVUDc = Ø1 + Ø6
EVUDd = Ø8

MODIFYING SIGNAL AND LIGHTING SYSTEMS

SCALE: 1" = 20'

NOTE:
FOR ACCURATE RIGHT OF WAY DATA, CONTACT RIGHT OF WAY ENGINEERING AT THE DISTRICT OFFICE.

Dist	COUNTY	ROUTE	POST MILES TOTAL PROJECT	SHEET No.	TOTAL SHEETS
03	ED	50	16.0/16.6	39	45



REGISTERED CIVIL ENGINEER

7-30-20
DATE

AUGUST 31, 2020

PLANS APPROVAL DATE

THE STATE OF CALIFORNIA OR ITS OFFICERS
OR AGENTS SHALL NOT BE RESPONSIBLE FOR
THE ACCURACY OR COMPLETENESS OF SCANNED
COPIES OF THIS PLAN SHEET.

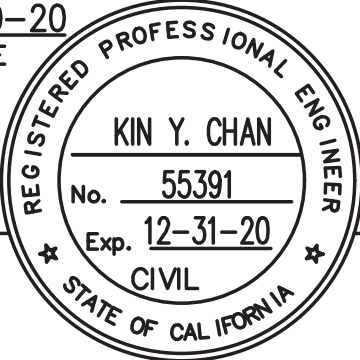

Y&C TRANSPORTATION
CONSULTANTS, INC.
3250 RAMOS CIRCLE
SACRAMENTO, CA 95827

CITY OF PLACERVILLE
PUBLIC WORKS
3101 CENTER STREET
PLACERVILLE, CA 95667

Exist CONDUCTOR AND CONDUIT SCHEDULE											
CONDUCTOR DESIGNATION			RUN NUMBER								
CABLE TYPE	Std (X)	PHASE	NUMBER OF CONDUCTORS								
			1	2	3	4	5	6	7	8	9
Veh–Ped 12CSC	(a)	8	1	1	1	1	1	1	1		
	(b)	5,6,8P		1	1	1	1	1	1		
	(c)		8		1	1	1	1	1	1	
	(d)	2,5,2P			1	1	1	1	1		
	(e)		8			1	1	1	1	1	
	(f)		2			1	1	1	1	1	
	(g)	7,8,8P				1	1	1	1		
	(h)	7					1	1	1		
	(i)		2					1	1	1	
	(j)	1,2,6,2P						2	2		
APS 3CSC	(k)	6					1	1	1	1	
	(l)	7,8					1	1	1	1	
TOTAL CABLES 12/3 CONDUCTORS			1	2	3	4	5	9	9	2	1
AWG			CIRCUIT								
#8		LIGHTING (240 V)	2	2	2	2	2	2		2	2
#6		SIGNAL (120 V)							2		
EVUC			1	1	2	2	3	4	4		
APS MANUFACTURER'S CABLE					2		1				
TYPE B DLC	PHASE										
	ø1			1	1	1	1	1	1		
	ø2								3		
	ø2 ADV/INT								1		
	ø5								1		
	ø6			3	3	3	3	3	3		
	ø6 ADV/INT			1	1	1	1	1	1		
	ø7						2	2		2	
	ø7 ADV/INT						1	1	1		
	ø8					3	3	3	3		
ø8 ADV/INT					1	1	1	1			
TOTAL DLCs PER RUN				5	5	9	9	12	17	3	
CONDUIT SIZE			3"	4"	4"	2–4"	2–4"	2–4"	3–4"	4"	3"
% FILL			9	13	20	13	18	25	17	11	8


STANDARD				Veh Sig Mtg				Ped Sig		APS		LED Lum	SPECIAL REQUIREMENTS
(X)	TYPE	SMA	LMA	ø	MAST ARM	ø	POLE	ø	Mtg	ø	ARROW		
(a)	Exist 24-4-100	35'	15'	8	MAS-4B	8	SV-1-T					Rdwy 1	SEE NOTE 3 ON SHEET E-5.
(b)	Exist 1-B					⁺ 5 6	TV-2-T	8	SP-1-T				SEE NOTE 2 ON SHEET E-5.
(c)	Exist PBA POST									8	→		ALL EXISTING EQUIPMENT TO REMAIN.
(d)	Exist 26-4-100	40'	15'	⁺ 5 2	MAS ⁺ MAS	2	SV-1-T	2	SP-1-T			Rdwy 1	SEE NOTES 1 AND 18 ON SHEET E-5.
(e)	Exist PBA POST									8	←		ALL EXISTING EQUIPMENT TO REMAIN.
(f)	Exist PBA POST									2	→		ALL EXISTING EQUIPMENT TO REMAIN.
(g)	Exist 1-B					⁺ 7 8	TV-2-T	8	SP-1-T				ALL EXISTING EQUIPMENT TO REMAIN.
(h)	Exist 17-3-70	20'	15'	7	MAS-4B	7	SV-1-T					Rdwy 1	ALL EXISTING EQUIPMENT TO REMAIN.
(i)	Exist PBA POST									2	←		ALL EXISTING EQUIPMENT TO REMAIN.
(j)	Exist 29-5-100	50'	15'	⁺ 1 6	MAS ⁺ MAS	⁺ 1 2	SV-2-TB	2	SP-1-T			Rdwy 1	ALL EXISTING EQUIPMENT TO REMAIN.
(k)	Exist 15TS		15'			6	SV-1-T					Rdwy 1	ALL EXISTING EQUIPMENT TO REMAIN.
(l)	Exist 1-B					⁺ 1 2	SV-2-TB						ALL EXISTING EQUIPMENT TO REMAIN.

+ = INSTALL NEW EQUIPMENT ON EXISTING MAST ARM OR POLE.

MODIFYING SIGNAL AND LIGHTING SYSTEMS
NO SCALE


APPROVED FOR ELECTRICAL WORK ONLY

STATE OF CALIFORNIA – DEPARTMENT OF TRANSPORTATION	CONSULTANT FUNCTIONAL SUPERVISOR	DANIEL K. YAU	CALCULATED-DESIGNED BY	CHECKED BY	MENG YANG	KIN Y. CHAN	REVISED BY	DATE REVISED		

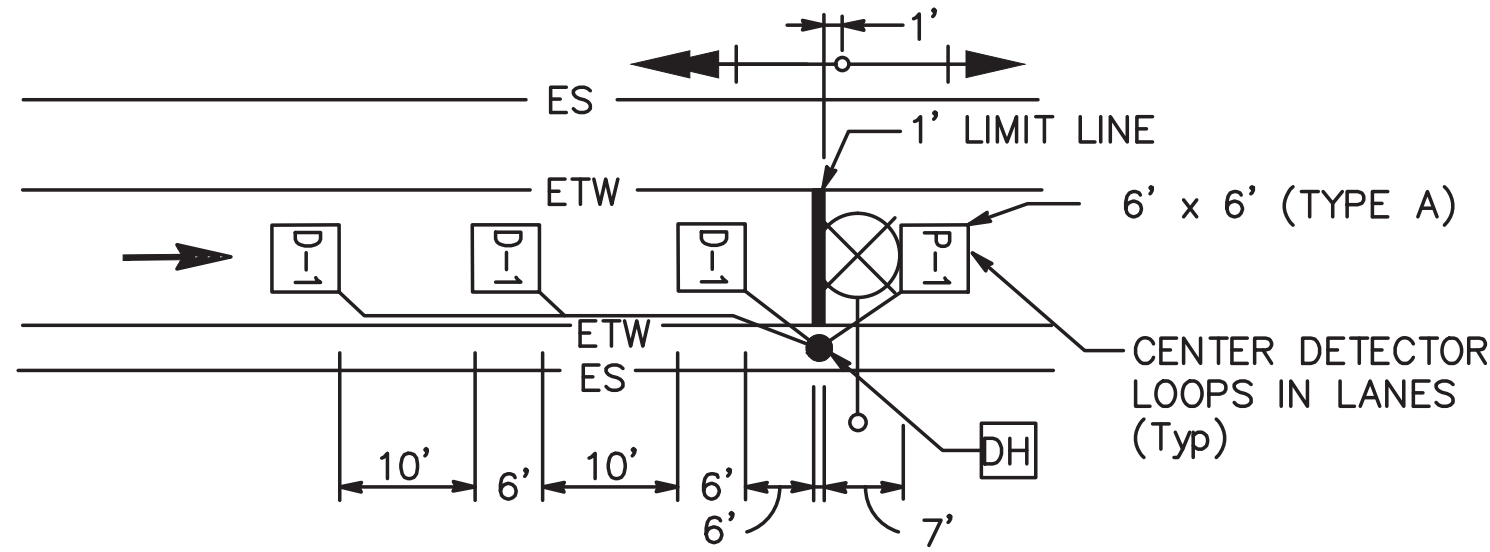

ONE LANE

**DETAIL RM
RAMP METERING**

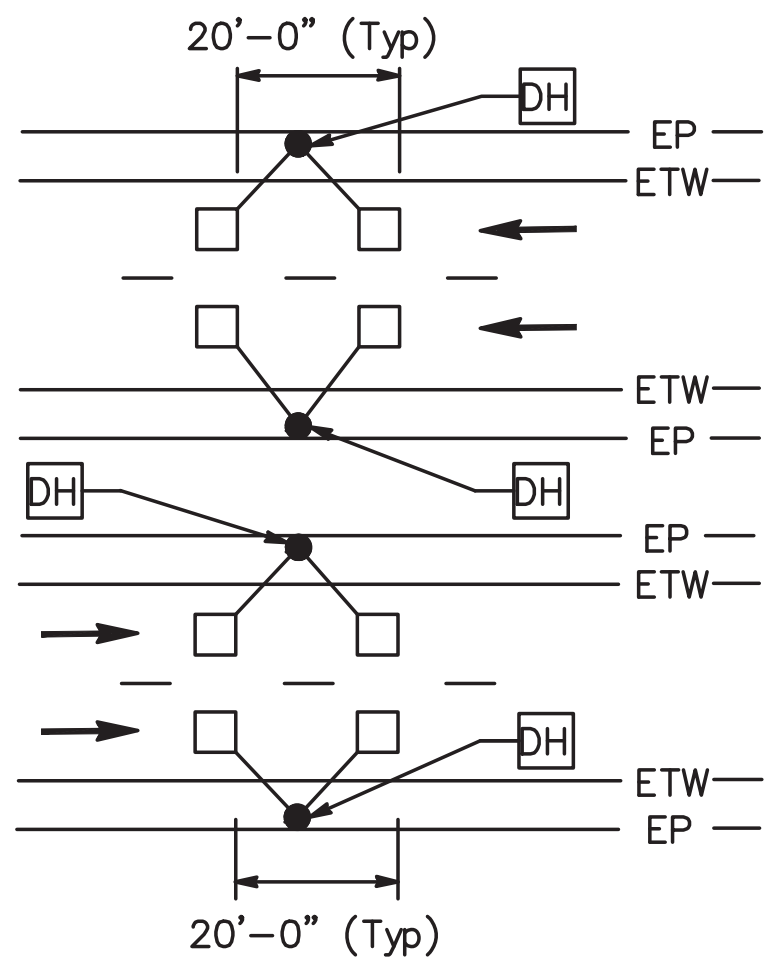

**DETAIL TM
TRAFFIC MONITORING STATION**

FREEWAY MAINLINE DETECTOR DESIGNATION:

N=NORTHBOUND LANES (NB)
S=SOUTHBOUND LANES (SB)
E=EASTBOUND LANES (EB)
W=WESTBOUND LANES (WB)


NUMBER OF LANES FROM LEFT WITH RESPECT TO DIRECTION OF TRAFFIC:

1=FIRST LANE FROM LEFT
2=SECOND LANE FROM LEFT
3=THIRD LANE FROM LEFT
4=FOURTH LANE FROM LEFT

NUMBER OF DETECTOR IN THE SAME LANE:

1=ENTERING DETECTOR
2=LEAVING DETECTOR

TRAFFIC MONITORING STATION NOTES

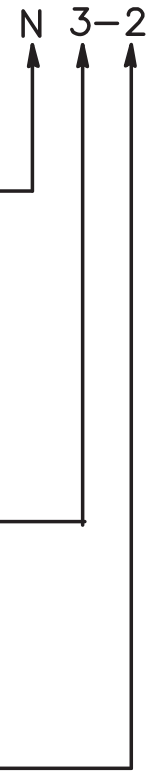

D=DEMAND DETECTOR
P=PASSAGE DETECTOR
Q=QUEUE DETECTOR
F=OFF-RAMP DETECTOR

1=FIRST LANE FROM LEFT
2=SECOND LANE FROM LEFT

RAMP DETECTOR DESIGNATION



LOOP DETECTOR DESIGNATION

ELECTRICAL SYSTEMS DETAILS
NO SCALE

ED-1

Dist	COUNTY	ROUTE	POST MILES TOTAL PROJECT	SHEET No.	TOTAL SHEETS
03	ED	50	16.0/16.6	40	45
REGISTERED CIVIL ENGINEER			7-30-20 DATE		
AUGUST 31, 2020			PLANS APPROVAL DATE		
Y&C TRANSPORTATION CONSULTANTS, INC. 3250 RAMOS CIRCLE SACRAMENTO, CA 95827			CITY OF PLACERVILLE PUBLIC WORKS 3101 CENTER STREET PLACERVILLE, CA 95667		


KIN Y. CHAN
No. 55391
Exp. 12-31-20
CIVIL
STATE OF CALIFORNIA

THE STATE OF CALIFORNIA OR ITS OFFICERS
OR AGENTS SHALL NOT BE RESPONSIBLE FOR
THE ACCURACY OR COMPLETENESS OF SCANNED
COPIES OF THIS PLAN SHEET.

STATE OF CALIFORNIA - DEPARTMENT OF TRANSPORTATION 	CONSULTANT FUNCTIONAL SUPERVISOR		CHECKED BY	MENG YANG	REVISD BY
	DANIEL K. YAU		KIN Y. CHAN	DATE REVISED	


NOTE:

THE CONTRACTOR MUST VERIFY ALL CONTROLLING FIELD DIMENSIONS BEFORE ORDERING OR FABRICATING ANY MATERIAL.

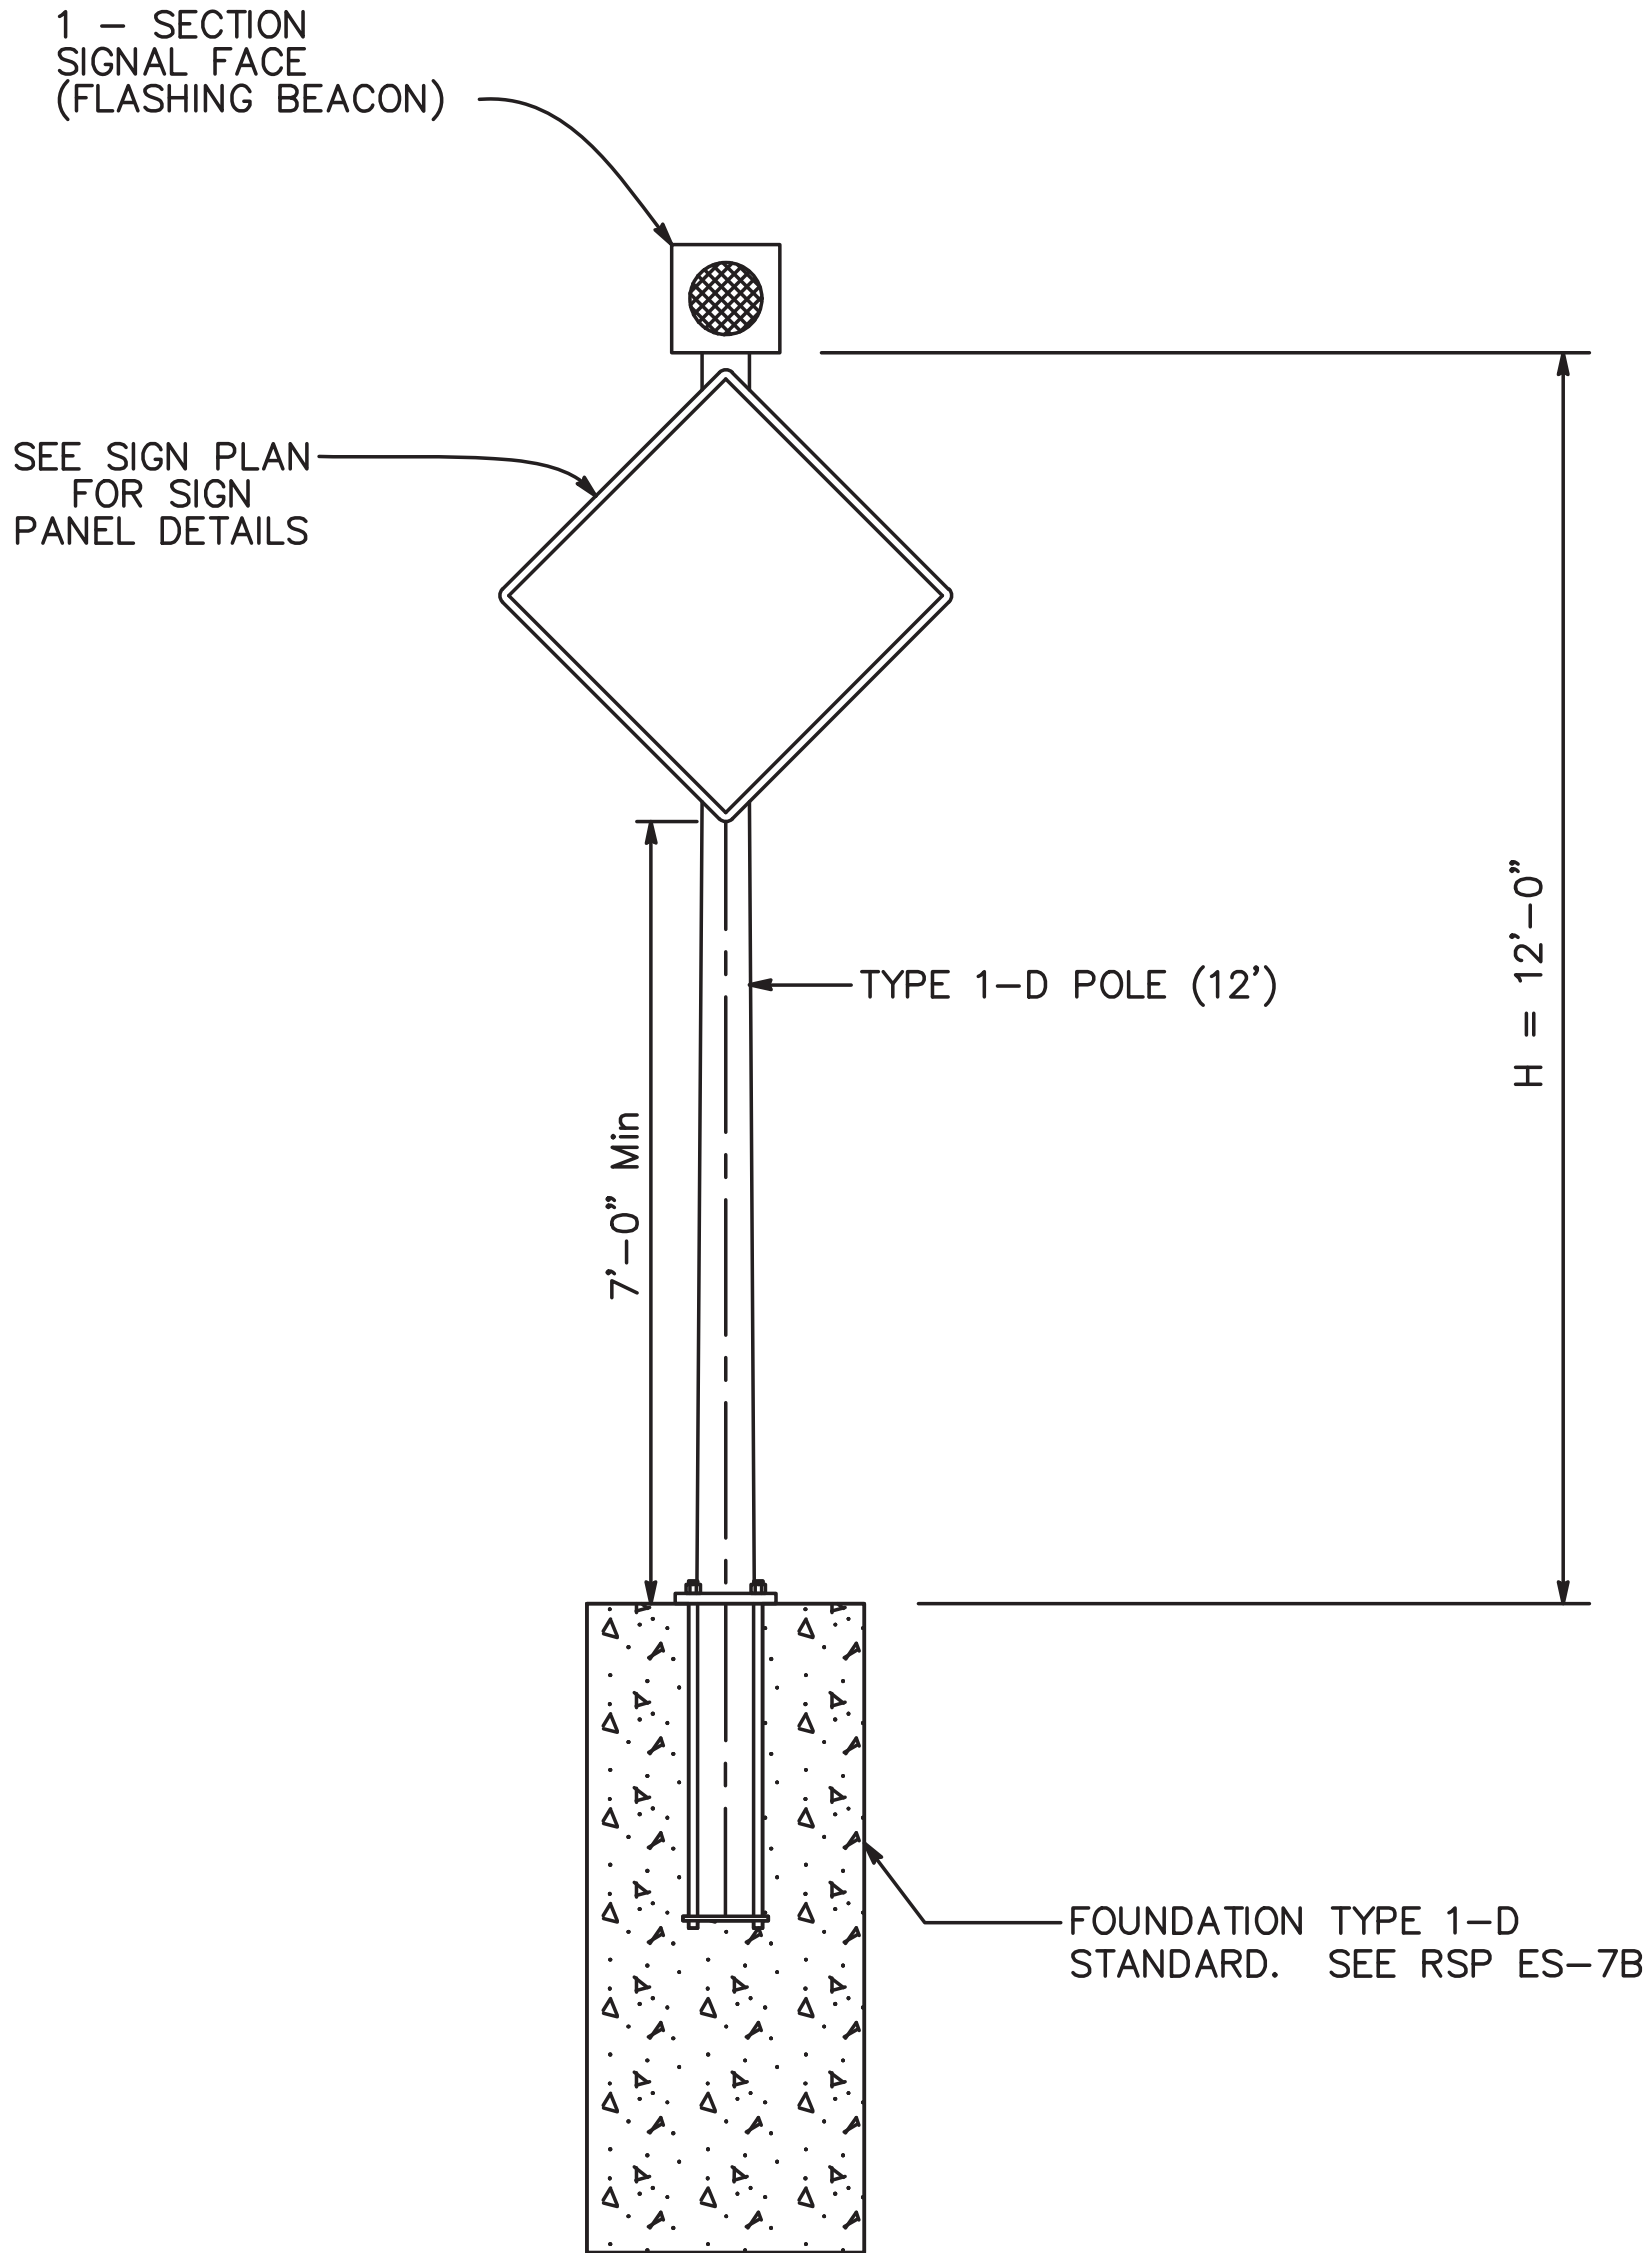


DETAIL A
TYPE 1-D STANDARD

NOTE: SEE CALTRANS RSP ES-7B FOR DETAILS.

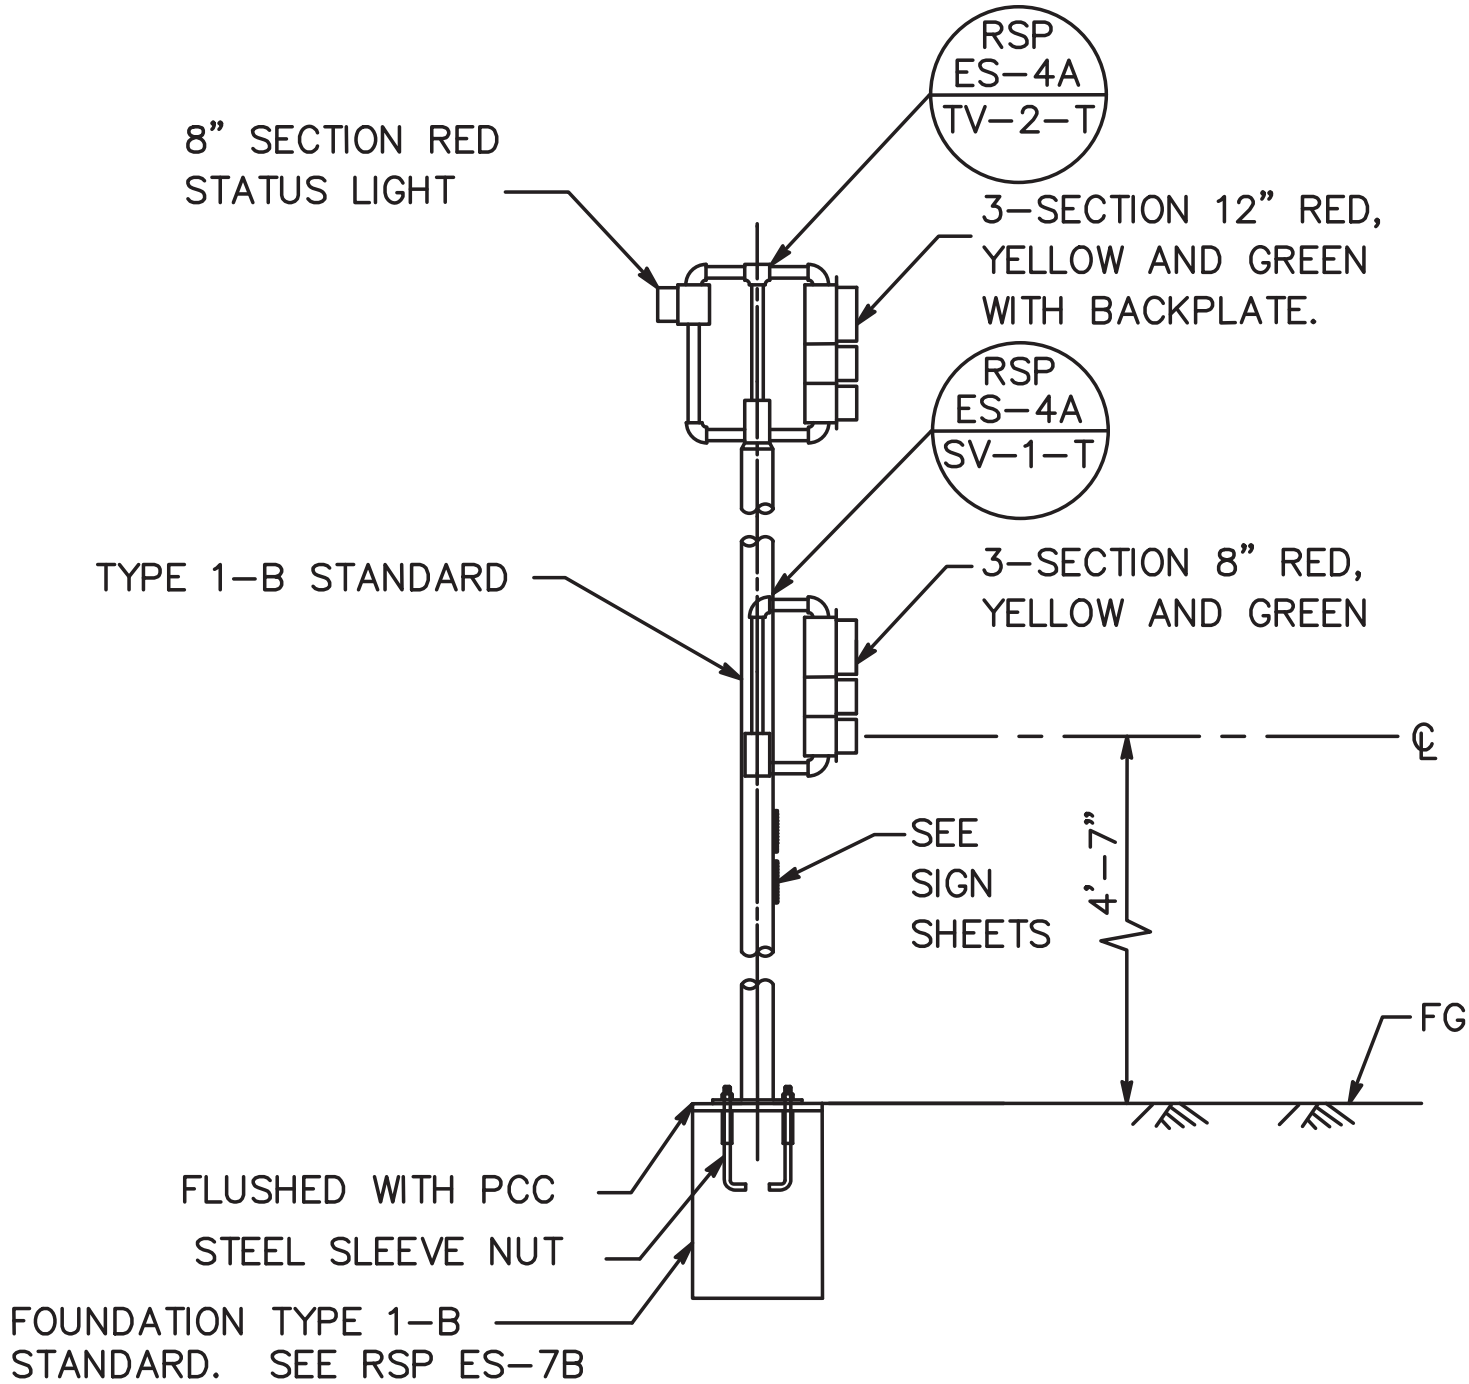

DETAIL SIG
RAMP METER SIGNAL, POLE MOUNTED

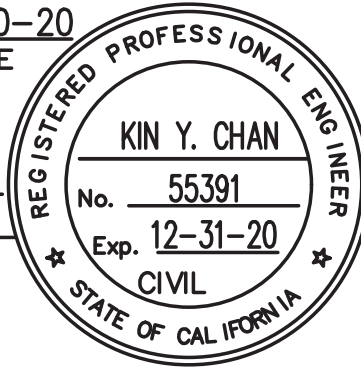Dist	COUNTY	ROUTE	POST MILES TOTAL PROJECT	SHEET No.	TOTAL SHEETS
03	ED	50	16.0/16.6	41	45
 REGISTERED CIVIL ENGINEER			7-30-20 DATE		
AUGUST 31, 2020					
PLANS APPROVAL DATE					
THE STATE OF CALIFORNIA OR ITS OFFICERS OR AGENTS SHALL NOT BE RESPONSIBLE FOR THE ACCURACY OR COMPLETENESS OF SCANNED COPIES OF THIS PLAN SHEET.					
Y&C TRANSPORTATION CONSULTANTS, INC. 3250 RAMOS CIRCLE SACRAMENTO, CA 95827			CITY OF PLACERVILLE PUBLIC WORKS 3101 CENTER STREET PLACERVILLE, CA 95667		


ELECTRICAL SYSTEMS DETAILS
NO SCALE

ED-2

STATE OF CALIFORNIA – DEPARTMENT OF TRANSPORTATION 	CONSULTANT FUNCTIONAL SUPERVISOR DANIEL K. YAU	CALCULATED— DESIGNED BY CHECKED BY	MENG YANG KIN Y. CHAN	REVISED BY DATE REVISED		


NOTES ON PULL BOXES:

1. FOR ADDITIONAL DETAILS, SEE REVISED STANDARD PLAN ES-8B.
2. WELDING SHALL COMPLY WITH REQUIREMENTS IN STANDARD SPECIFICATION SECTION 75.
3. A PULL BOX FOR A POST OR A POLE STANDARD MUST BE LOCATED WITHIN 5 FEET OF THE STANDARD.

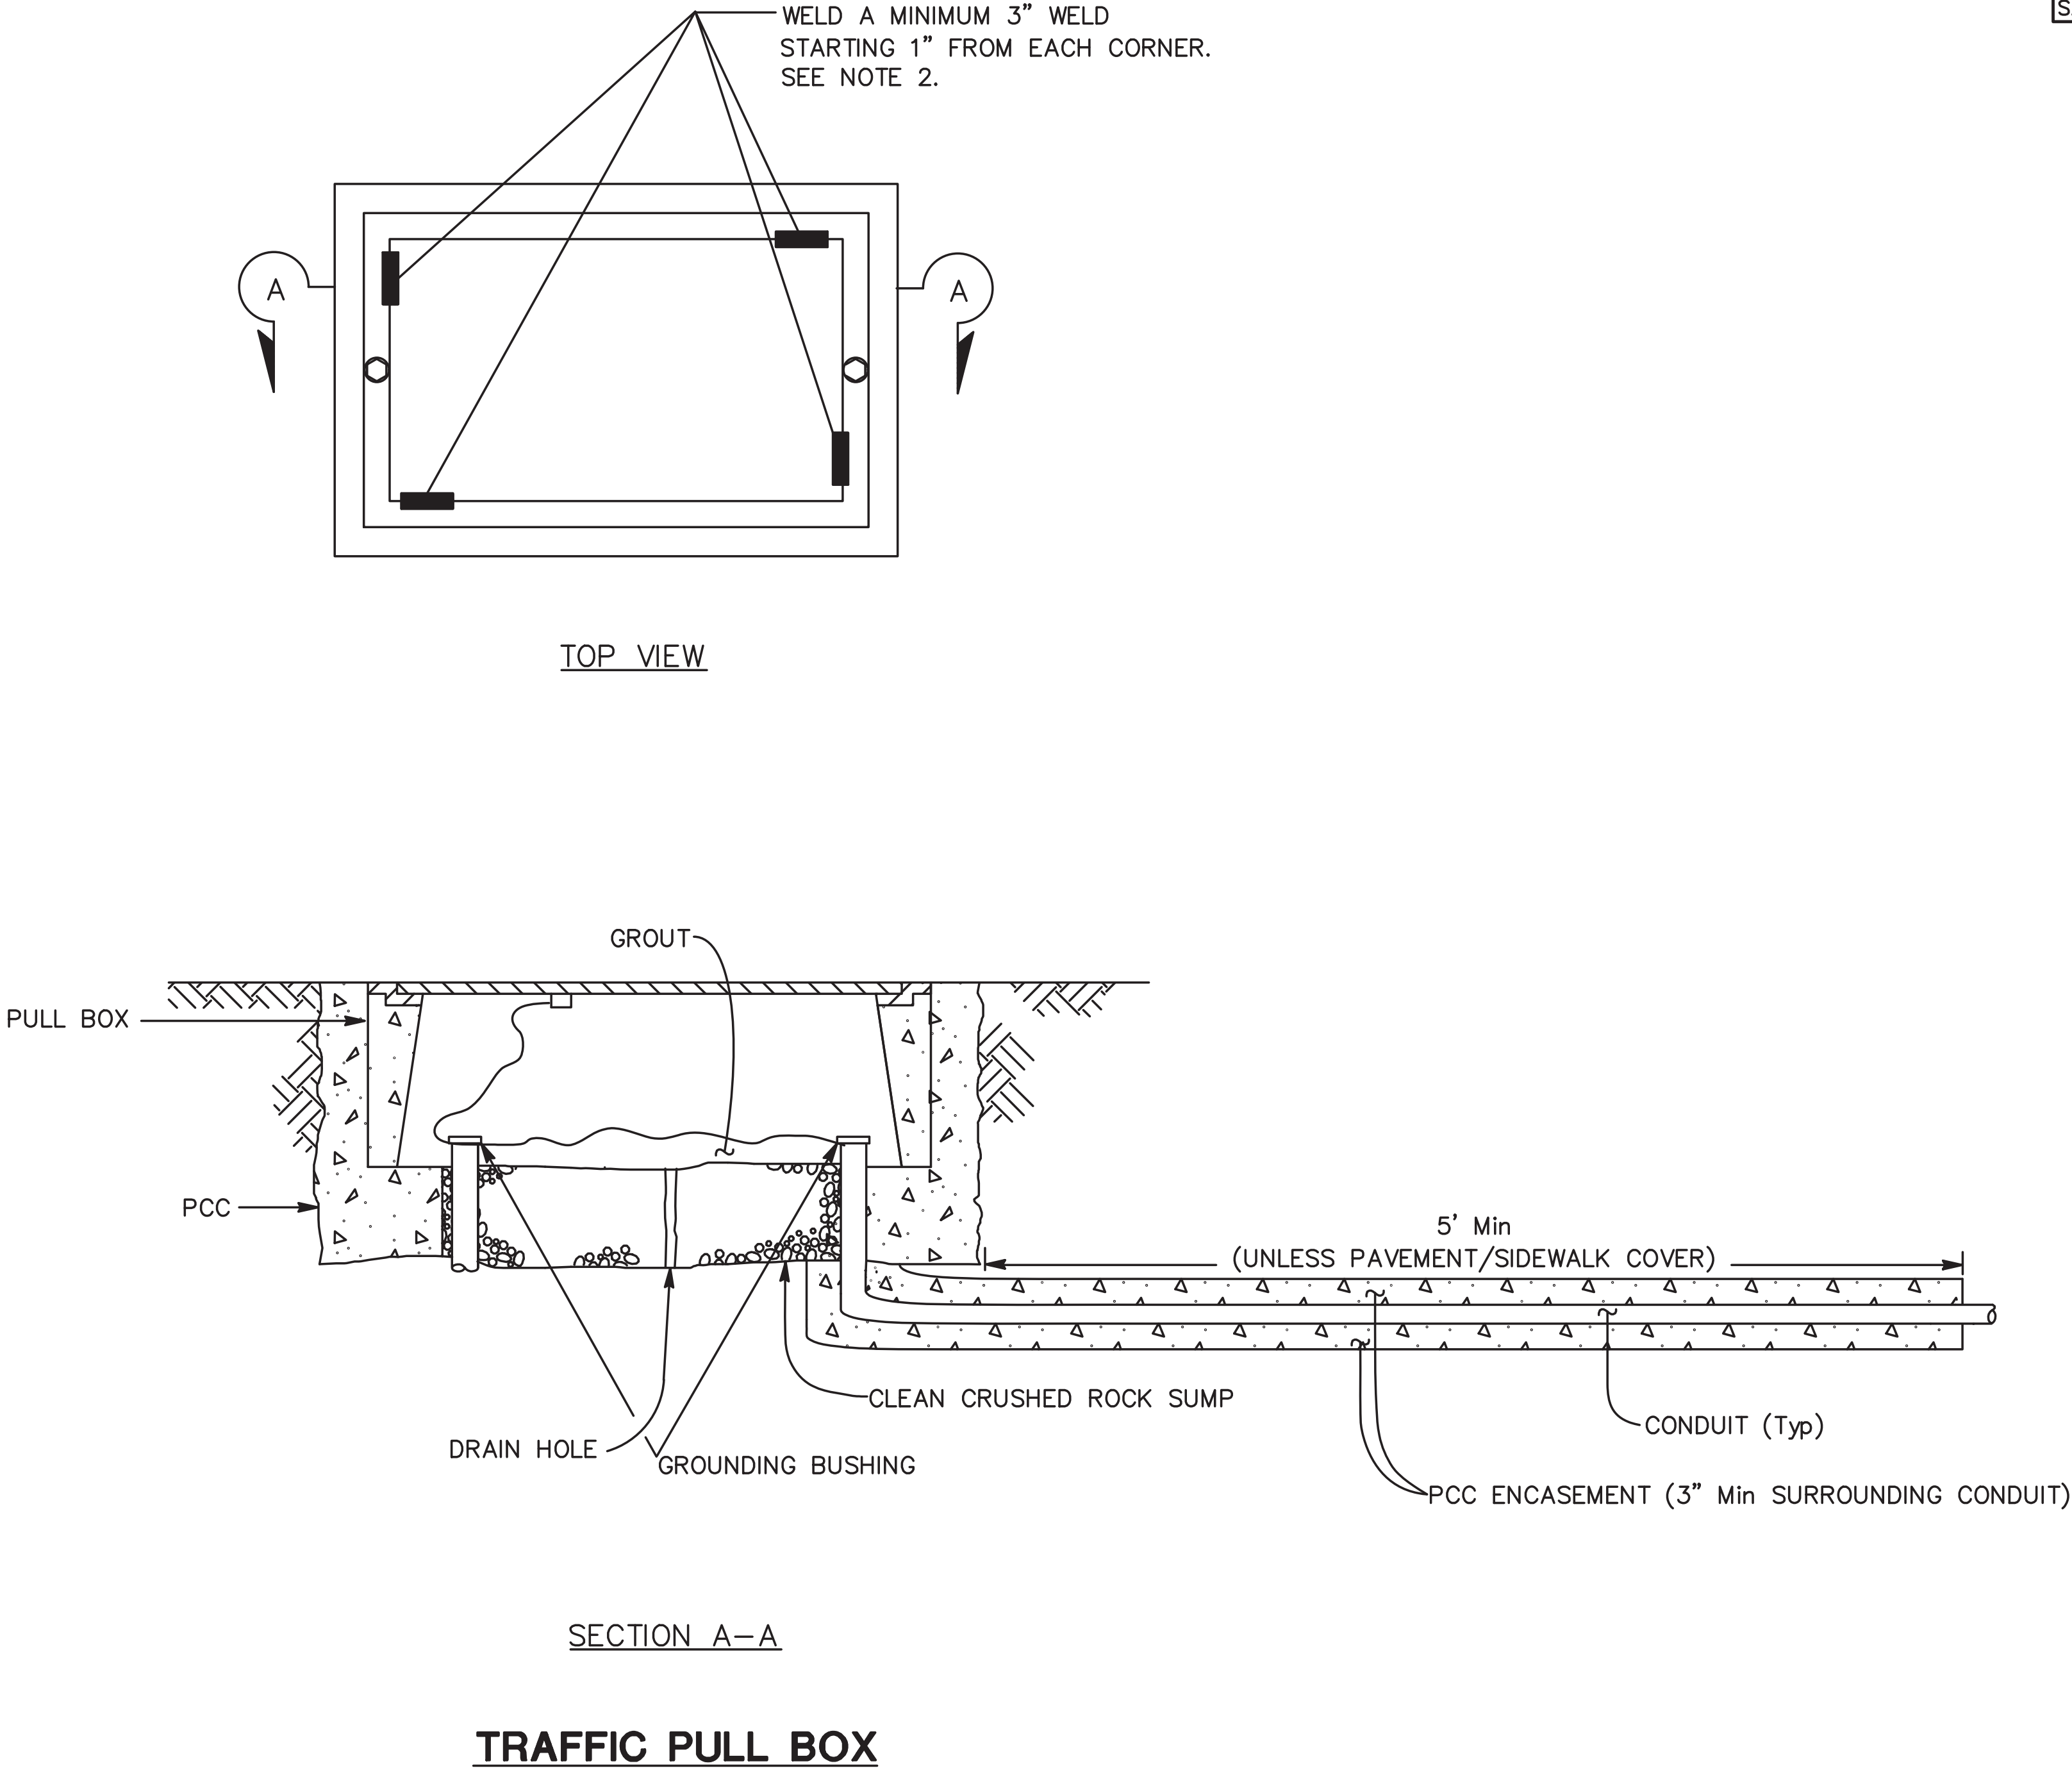

ELECTRICAL SYSTEMS DETAILS
NO SCALE

ED-3

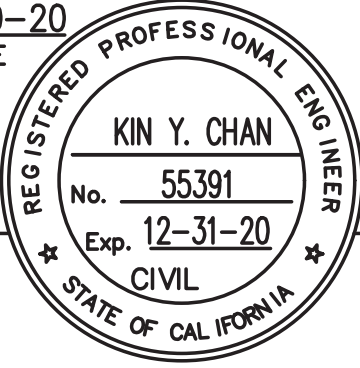Dist	COUNTY	ROUTE	POST MILES TOTAL PROJECT	SHEET No.	TOTAL SHEETS
03	ED	50	16.0/16.6	42	45
REGISTERED CIVIL ENGINEER 			7-30-20 DATE		
AUGUST 31, 2020			PLANS APPROVAL DATE		
THE STATE OF CALIFORNIA OR ITS OFFICERS OR AGENTS SHALL NOT BE RESPONSIBLE FOR THE ACCURACY OR COMPLETENESS OF SCANNED COPIES OF THIS PLAN SHEET.					
Y&C TRANSPORTATION CONSULTANTS, INC. 3250 RAMOS CIRCLE SACRAMENTO, CA 95827			CITY OF PLACERVILLE PUBLIC WORKS 3101 CENTER STREET PLACERVILLE, CA 95667		


STATE OF CALIFORNIA - DEPARTMENT OF TRANSPORTATION	CONSULTANT FUNCTIONAL SUPERVISOR				
	DANIEL K. YAU	CALCULATED- DESIGNED BY	MENG YANG	REVISED BY	
		CHECKED BY	KIN Y. CHAN	DATE REVISED	

NOTE (THIS SHEET ONLY):


1. PROVIDE 6-5' LONG CAT 6 CABLES, AND 2-3' LONG RJ-11 TELEPHONE.
2. USE 2 PAIR, 22 AWG, STRANDED AND TINNED COPPER WIRES WITH PVC JACKET TYPE INSULATION AS SPECIFIED IN THE SPECIAL PROVISIONS FOR COMPONENT POWER WIRING.
3. TERMINATE TELEPHONE CABLE PER ENGINEER'S INSTRUCTION IN THE FIELD.

LEGEND (THIS SHEET ONLY):

- 1 INSTALL 4G (LTE) WIRELESS MODEM ASSEMBLY AND ETHERNET EXTENDER SWITCH COMBINATION UNIT ON DIN RAIL AS SHOWN IN DETAILS I AND H.
- 2 REMOVE BLANK PLATE.
- 3 INSTALL STANDARD HALF SHELF AS SHOWN.
- 4 INSTALL 24 VDC POWER SUPPLY ON DIN RAIL.
- 5 REMOVE EXISTING TERMINAL BLOCK TBO AND INSTALL TWO 8P8C (EIA568B, RJ-45) AND TWO 6P2C (RJ-11) MODULAR CONNECTORS ON DIN RAIL.
- 6 INSTALL REMOTE ETHERNET POWER CONTROLLER SWITCH.
- 7 INSTALL MULTIPLE AC OUTLET STRIP.
- 8 INSTALL DATA SURGE SUPPRESSOR AS SHOWN. THE CONTRACTOR HAS THE OPTION TO INSTALL TWO TWO-LINE SURGE PROTECTORS, ONE FOR RJ-45 AND ONE FOR RJ-11.

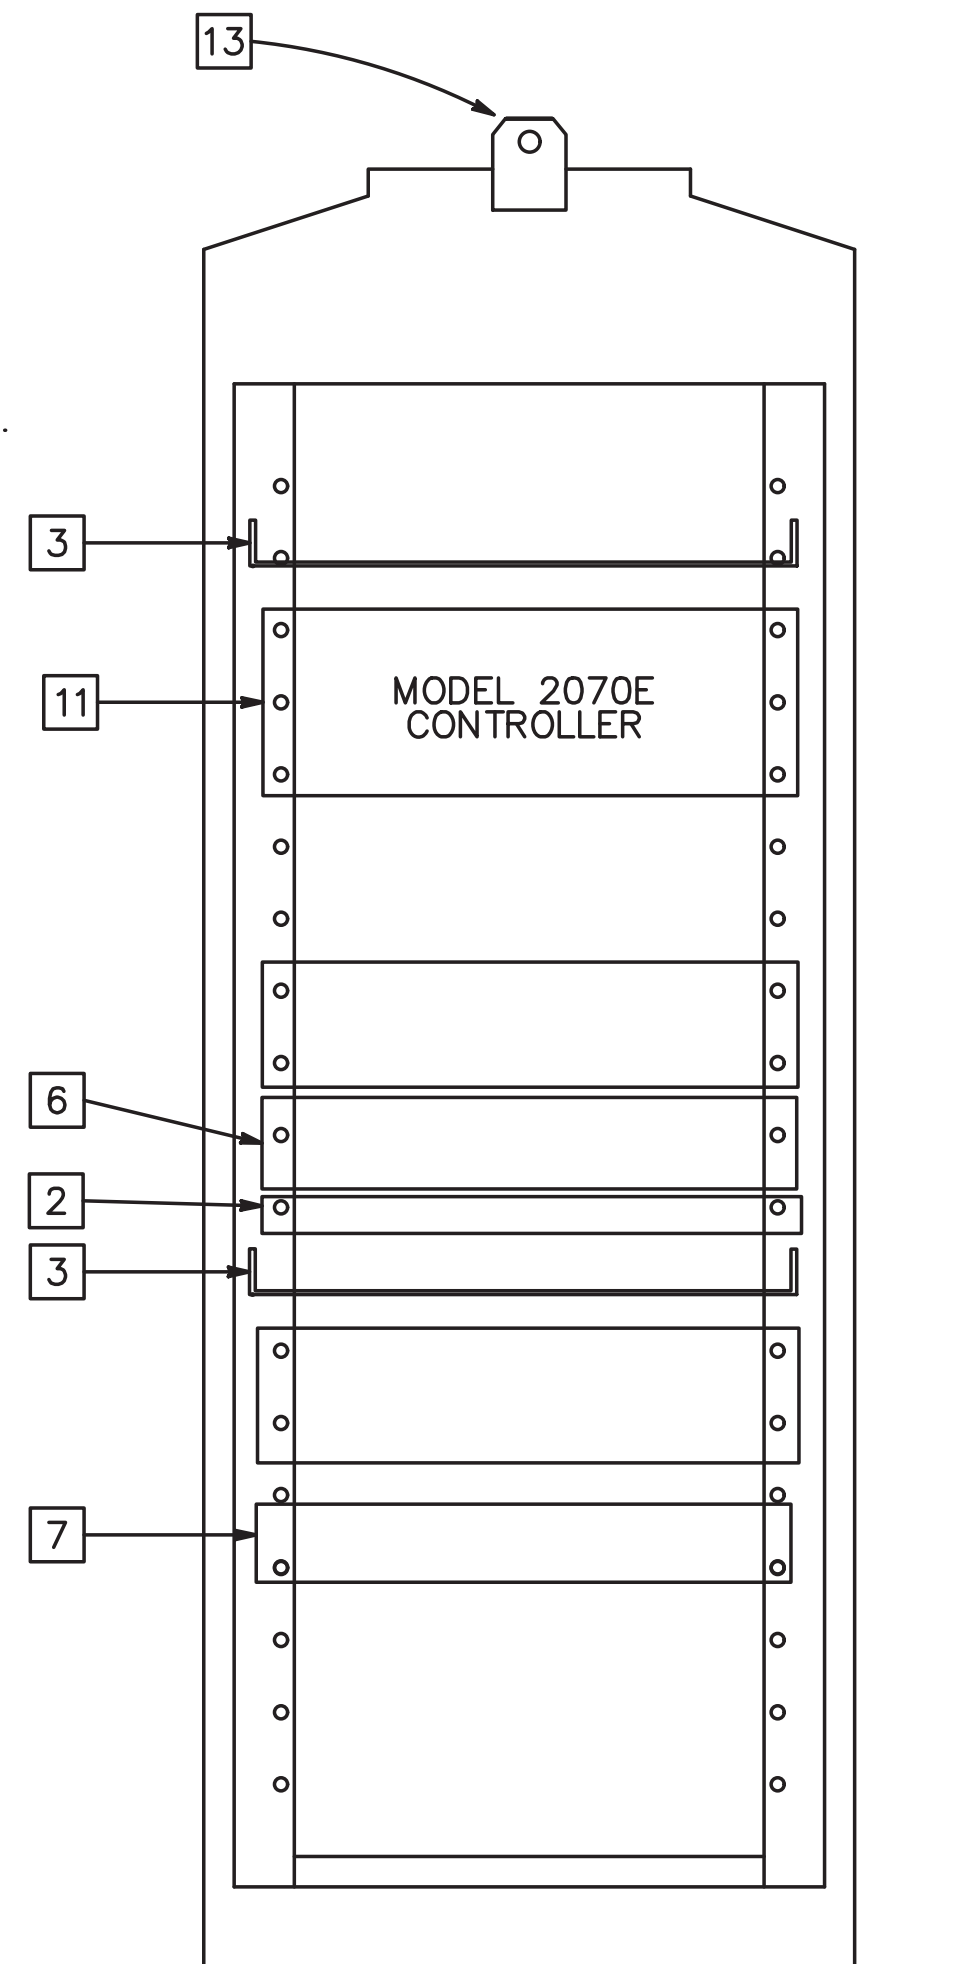


CABINET ASSEMBLY LAYOUT (TYPICAL)
(FRONT VIEW)
334L CONTROLLER CABINET

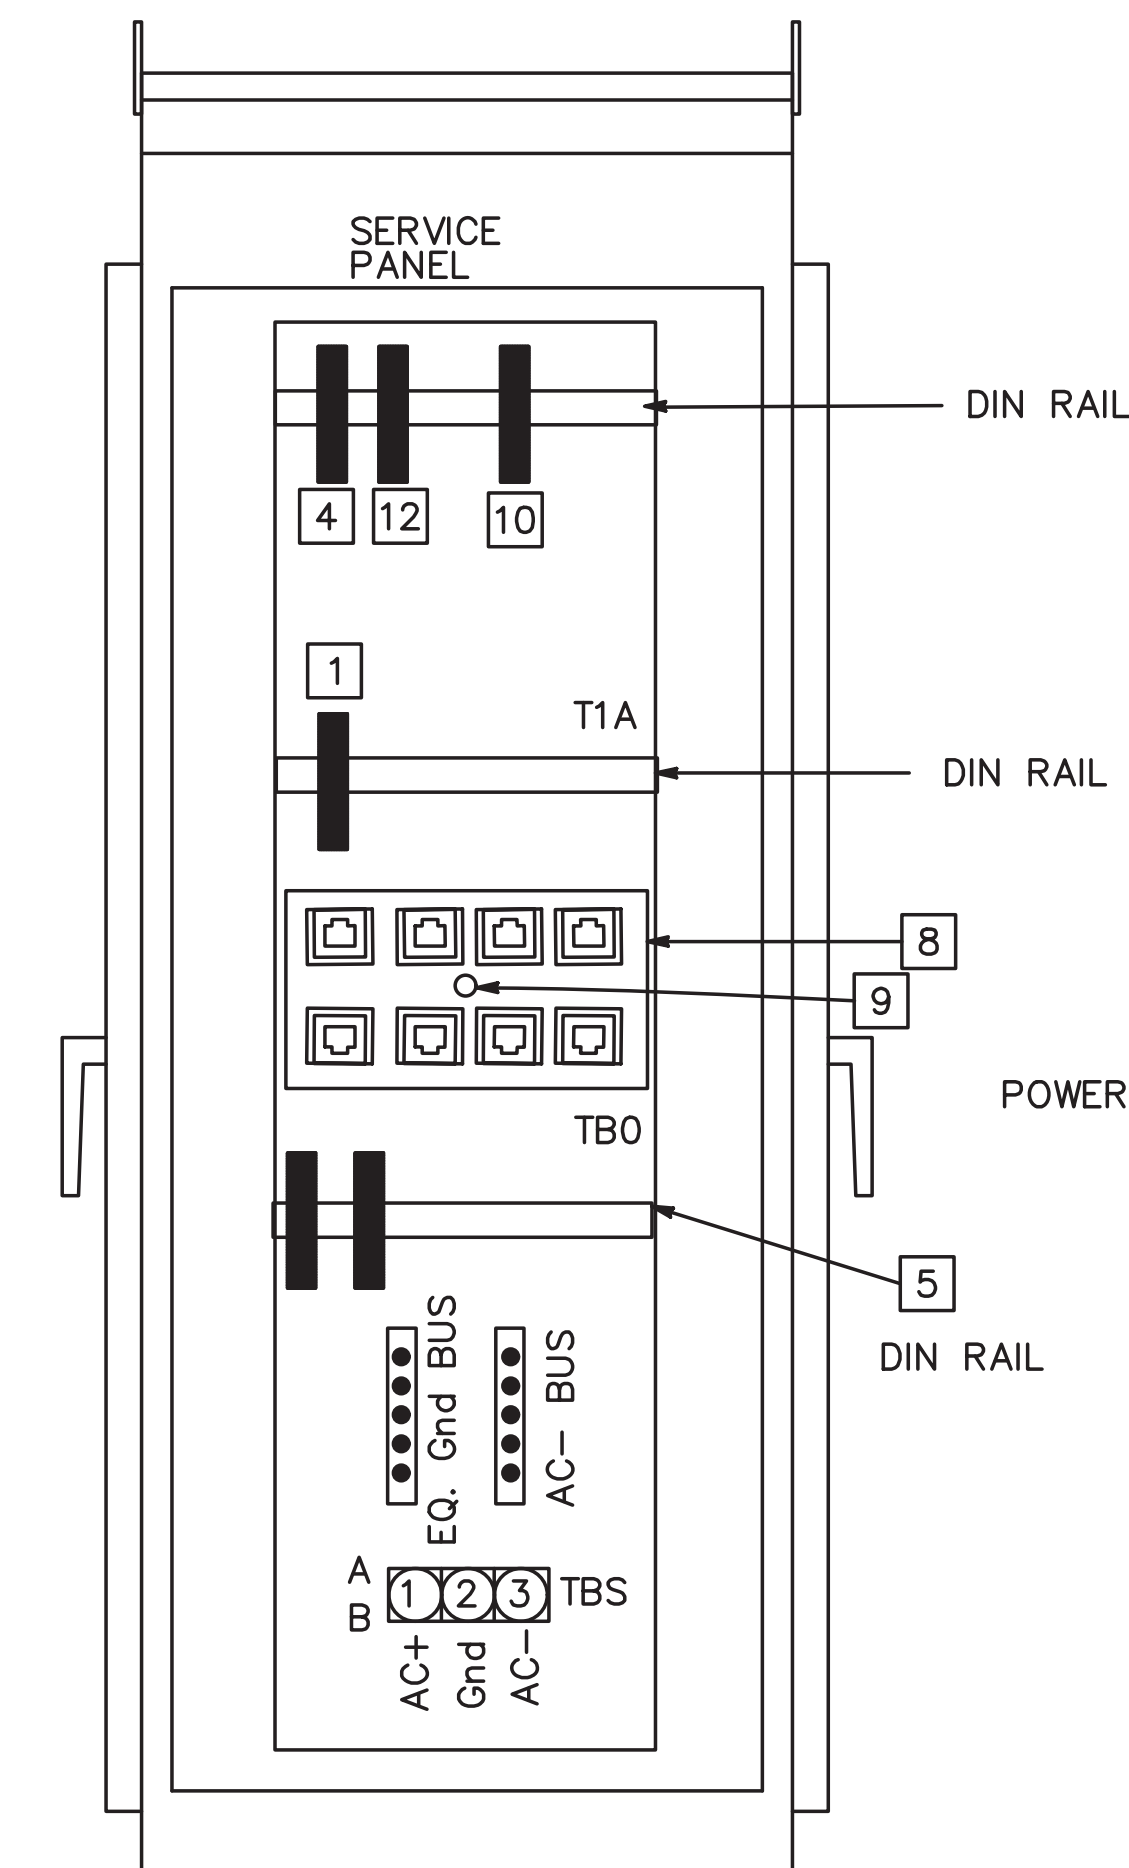


CABINET ASSEMBLY LAYOUT (TYPICAL)
(SIDE VIEW)
334L CONTROLLER CABINET

9. CONNECT SOLID #10 GROUND WIRE TO EQUIPMENT GROUND.
10. INSTALL ETHERNET EXTENDER—SWITCH COMBINATION UNIT ON DIN RAIL AS SHOWN IN DETAILS I AND H. IF UNITS HAVE SFP PORTS, SFP TRANSCEIVERS RECOMMENDED BY THE MANUFACTURER MUST BE INSTALLED IN ALL SFP PORTS.
11. INSTALL DEPARTMENT—FURNISHED MODEL 2070 CONTROLLER FOR RAMP METERING AND TRAFFIC MONITORING SYSTEMS.
12. INSTALL DC TERMINAL BLOCK ON DIN RAIL.
13. INSTALL 4G (LTE) ANTENNA AND RUN ANTENNA CABLE PER MANUFACTURER RECOMMENDATION AS SHOWN IN DETAIL K SHEET ED-9.

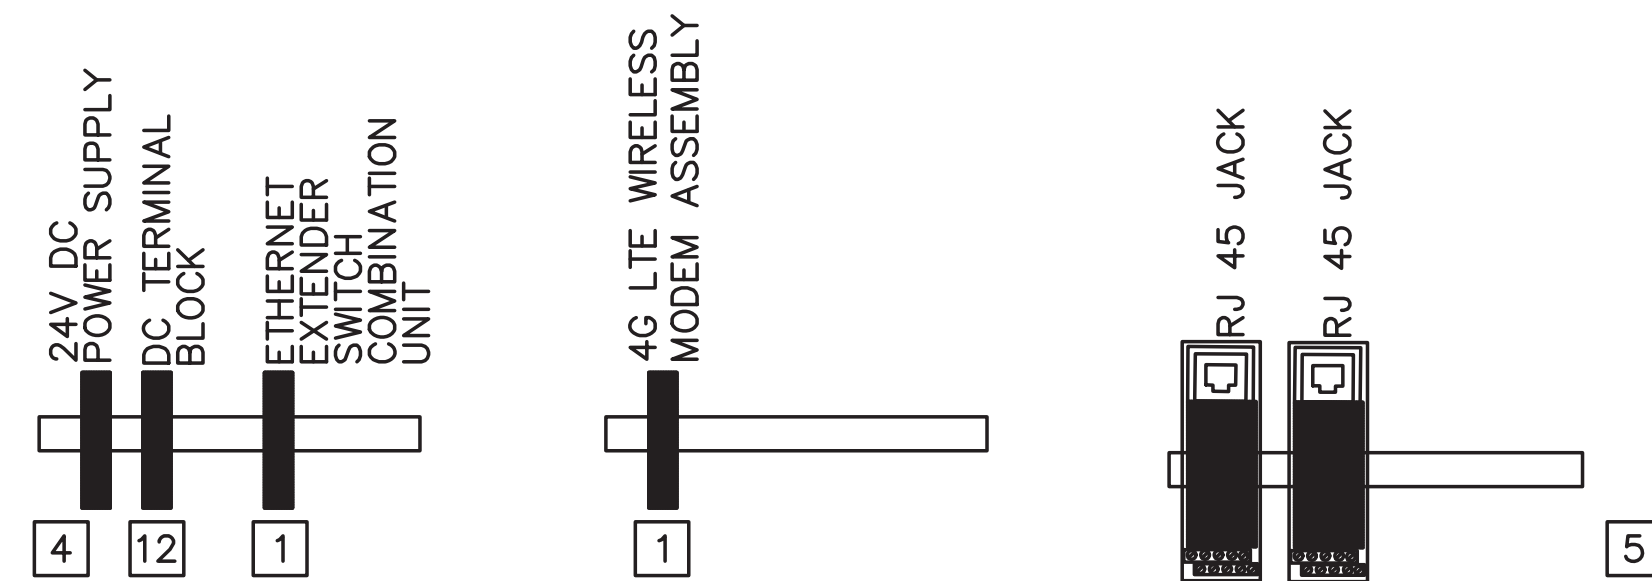

EQUIPMENT INSTALLATION ON DIN RAIL (TYPICAL)

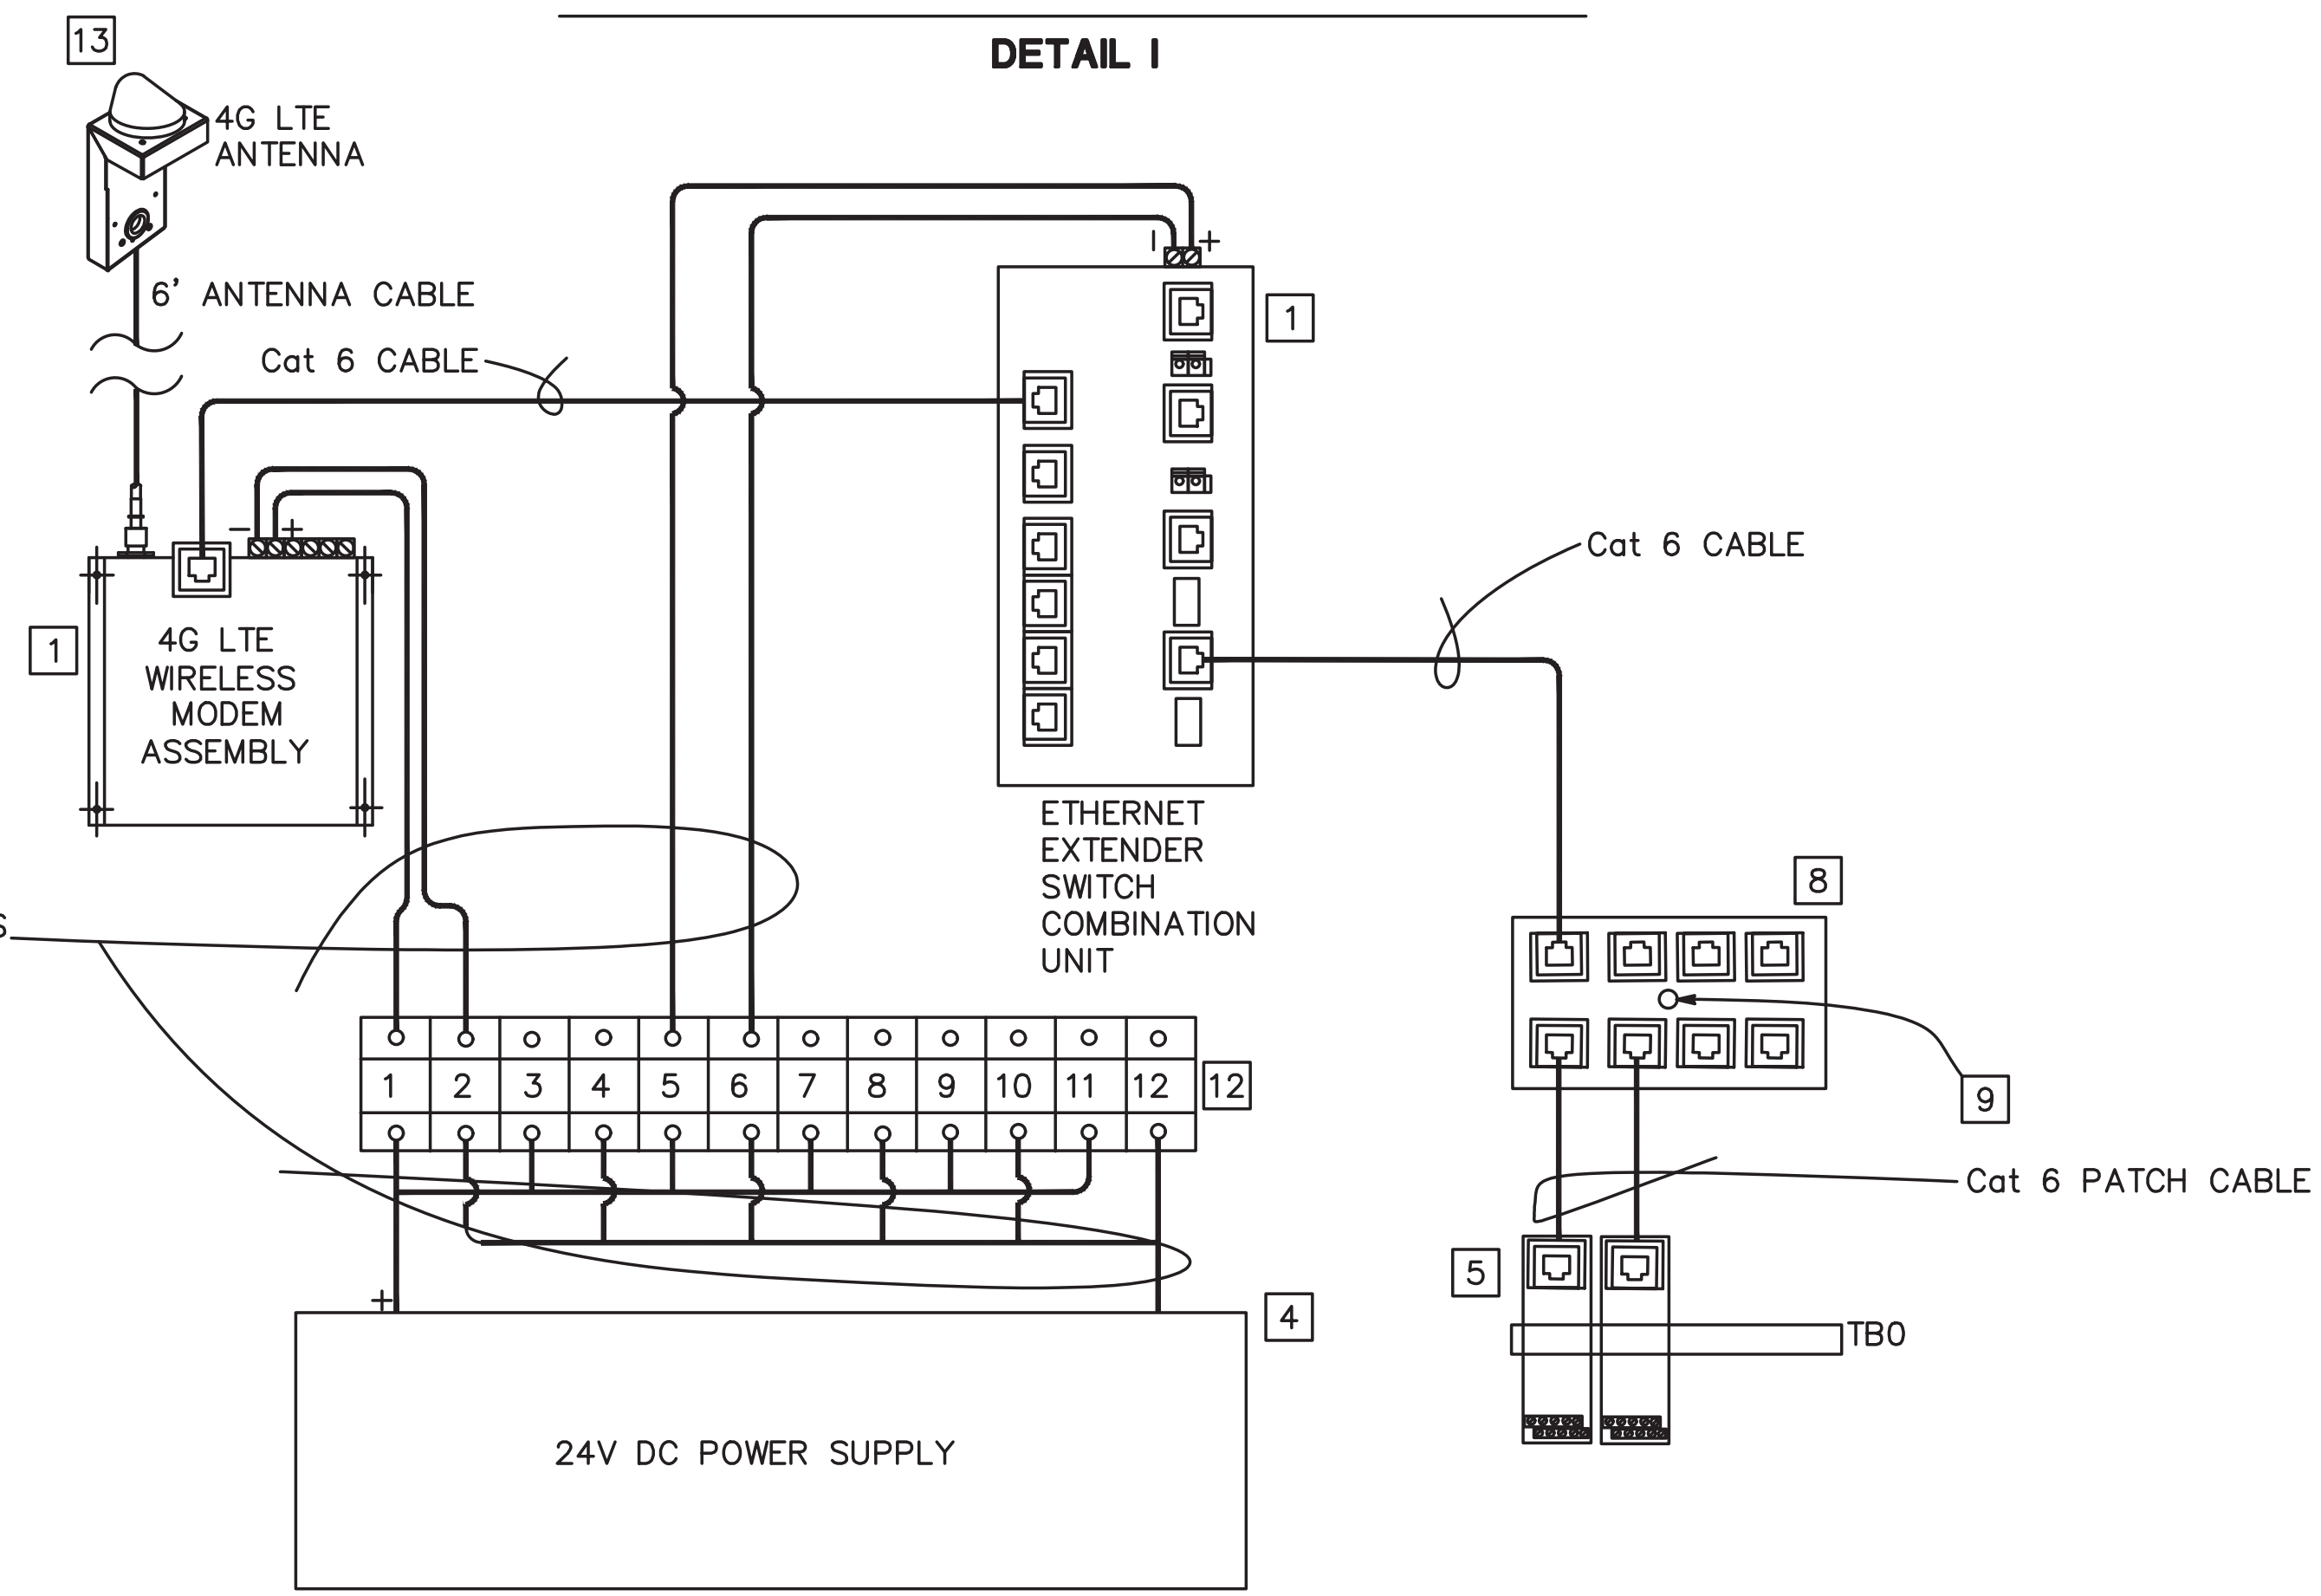

EQUIPMENT INTERCONNECTION (TYPICAL)

DETAIL H

ELECTRICAL SYSTEMS DETAILS

NO SCALE

ED-4

Dist	COUNTY	ROUTE	POST MILES TOTAL PROJECT	SHEET No.	TOTAL SHEETS
03	ED	50	16.0/16.6	43	45



REGISTERED CIVIL ENGINEER

7-30-20
DATE

AUGUST 31, 2020


PLANS APPROVAL DATE

*THE STATE OF CALIFORNIA OR ITS OFFICERS
OR AGENTS SHALL NOT BE RESPONSIBLE FOR
THE ACCURACY OR COMPLETENESS OF SCANNED
COPIES OF THIS PLAN SHEET.*




Y&C TRANSPORTATION CONSULTANTS, INC. 3250 RAMOS CIRCLE SACRAMENTO, CA 95827	CITY OF PLACERVILLE PUBLIC WORKS 3101 CENTER STREET PLACERVILLE, CA 95667
--	--

DIST	COUNTY	ROUTE	POST MILES TOTAL PROJECT	SHEET No.	TOTAL SHEETS
03	ED	50	16.0/16.6	44	45
 REGISTERED CIVIL ENGINEER			7-30-20		
AUGUST 31, 2020 PLANS APPROVAL DATE			DATE		
THE STATE OF CALIFORNIA OR ITS OFFICERS OR AGENTS SHALL NOT BE RESPONSIBLE FOR THE ACCURACY OR COMPLETENESS OF SCANNED COPIES OF THIS PLAN SHEET.					
Y&C TRANSPORTATION CONSULTANTS, INC. 3250 RAMOS CIRCLE SACRAMENTO, CA 95827			CITY OF PLACERVILLE PUBLIC WORKS 3101 CENTER STREET PLACERVILLE, CA 95667		

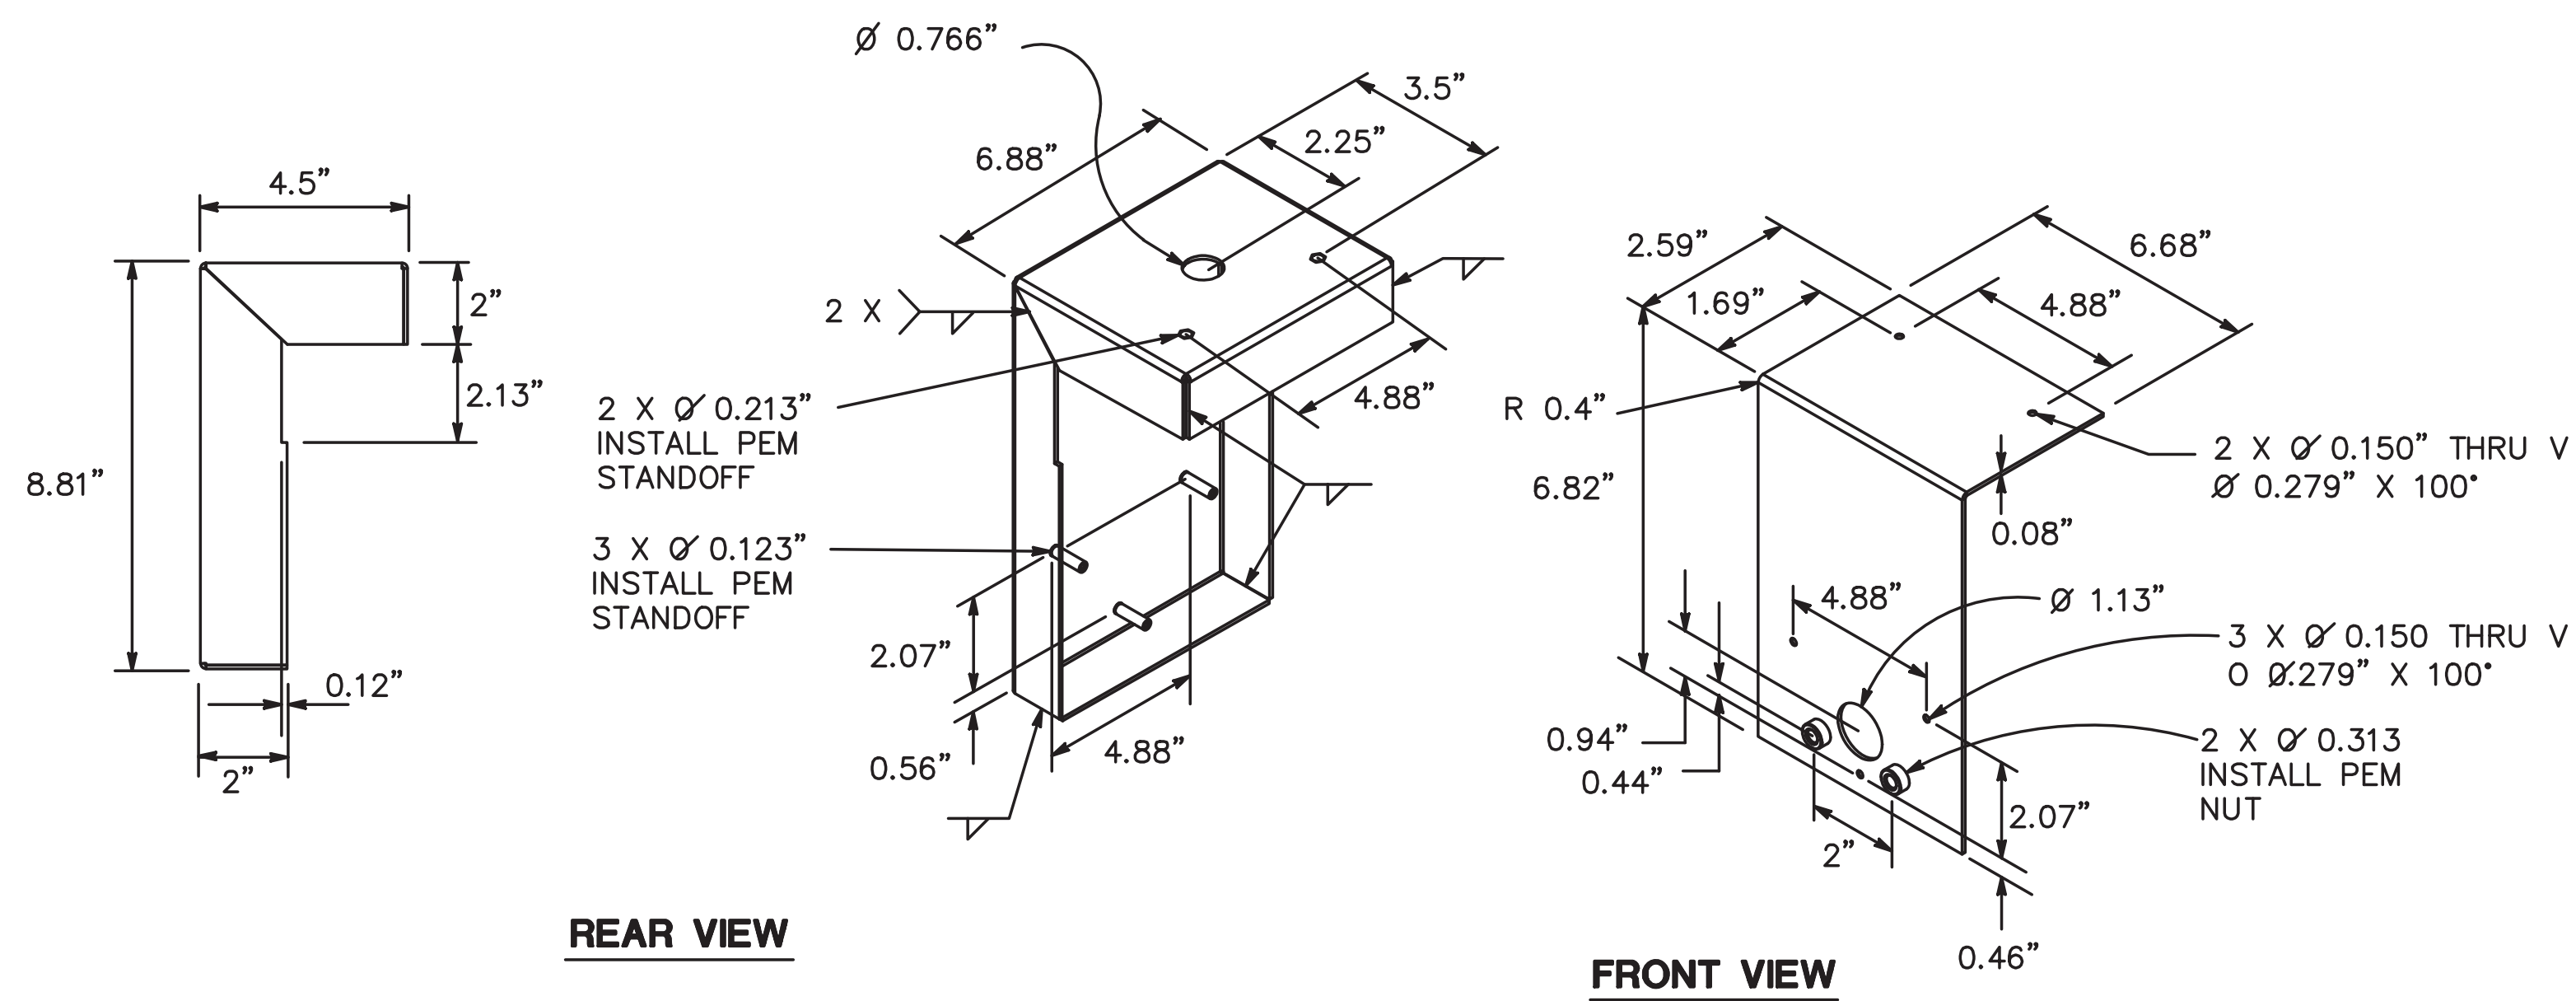

BRACKET

* THE CONTRACTOR SHALL SUBMIT A PROTOTYPE OF
BRACKET TO THE ENGINEER FOR APPROVAL.

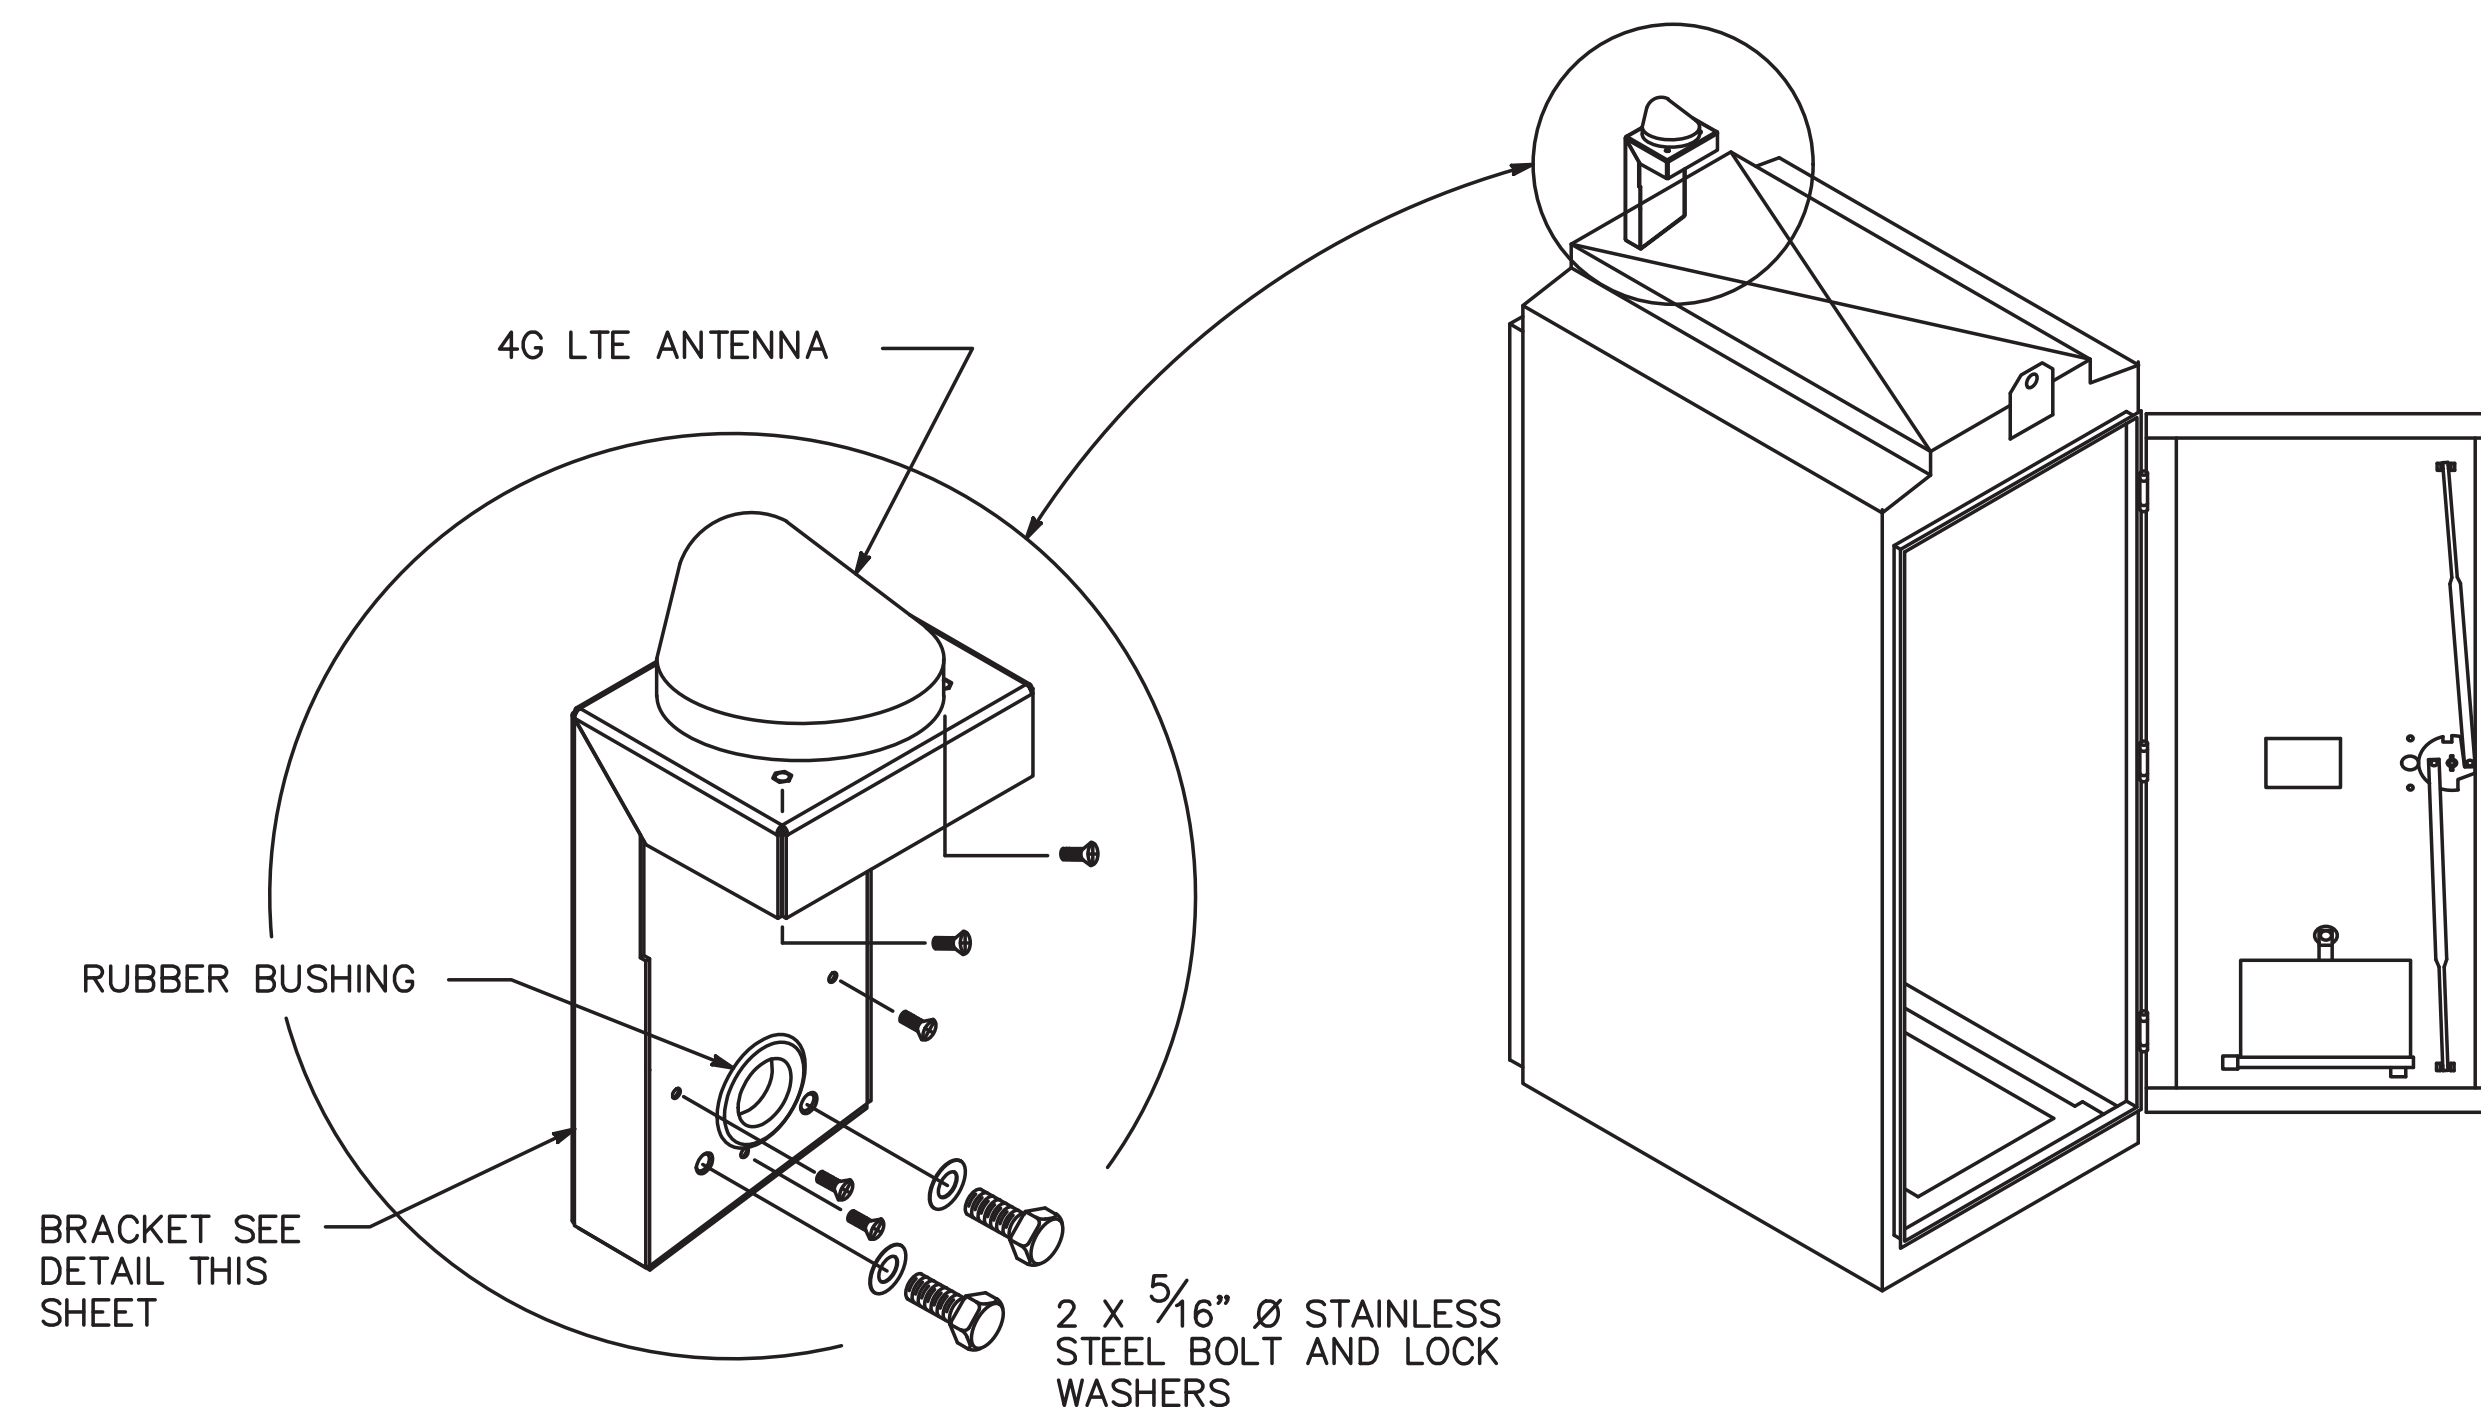

4G LTE WIRELESS ANTENNA INSTALLATION ON CABINET

DETAIL K

ELECTRICAL SYSTEMS DETAILS

NO SCALE

ED-5

STATE OF CALIFORNIA – DEPARTMENT OF TRANSPORTATION		CONSULTANT FUNCTIONAL SUPERVISOR				
		DANIEL K. YAU		CALCULATED— DESIGNED BY	MENG YANG	REVISED BY
				CHECKED BY	KIN Y. CHAN	DATE REVISED

BORDER LAST REVISED 7/2/2010	USERNAME => \$USER DGN FILE => \$REQUEST	RELATIVE BORDER SCALE IS IN INCHES		UNIT XXXX	PROJECT NUMBER & PHASE	03190001521
------------------------------	---	---------------------------------------	--	-----------	------------------------	-------------

NOTE:

ELECTRICAL SYSTEMS QUANTITY TABLES SUMMARIZE SIGNIFICANT COMPONENTS.
SEE ELECTRICAL SYSTEMS PLANS AND SPECIFICATIONS TO DETERMINE ALL MATERIALS NEEDED FOR EACH SYSTEM.

SHEET No.		(N)																																																																																																																																																																																																																																																																																																																																																																																																																																																																																																																																																																																																																																																																																																																																																																																																																																																																																																																																																																																																																																																																																																																																																																																																																																																																																		
E-2		EA	No. 5(T) PB	EA	No. 6 PB	EA	No. 6(T) PB	EA	No. 6(E)(T) PB	EA	LOOP DETECTOR, TYPE A (6'x6')	EA	LOOP DETECTOR, TYPE A (6'x10')	EA	TYPE 30 LIGHTING Std	EA	TYPE 30 LIGHTING Std Fdn	EA	235 W LED Lum	EA	TYPE 1-D Std WITH FB	EA	TYPE 1-B Std	EA	TYPE 1-D Fdn	EA	TYPE 1-B Fdn	EA	SIGNAL MOUNT TV-2-T	EA	SIGNAL MOUNT SV-1-T	EA	SIGNAL 3-12" (HOUSING, BACKPLATE, LED)	EA	SIGNAL 1-8" (HOUSING, BACKPLATE, LED)	EA	MODEL 334L CABINET Fdn WITH ANCHOR BOLTS	EA	4G LTE WIRELESS MODEM ASSEMBLY	EA	4G LTE ANTENNA	EA	ETHERNET EXTENDER SWITCH COMBINATION UNIT	EA	REMOTE ETHERNET POWER CONTROLLER SWITCH	EA	24 VDC POWER SUPPLY	EA	DATA SURGE SUPPRESSOR	EA	DC TERMINAL BLOCK	LF	2" CONDUIT (TYPE 3)	LF	3" CONDUIT (TYPE 3)	LF	No. 6 CONDUCTOR	LF	No. 8 CONDUCTOR	LF	No. 8 BARE CONDUCTOR	LF	No. 14 CONDUCTOR	LF	DLC																																																																																																																																																																																																																																																																																																																																																																																																																																																																																																																																																																																																																																																																																																																																																																																																																																																																																																																																																																																																																																																																																																																																																																																																																			
	5																																																																																																																																																																																																																																																																																																																																																																																																																																																																																																																																																																																																																																																																																																																																																																																																																																																																																																																																																																																																																																																																																																																																																																																																																																																																																			

(N) – NOT A SEPARATE BID ITEM

SHEET No.	(N)							
	No. 5(T) PB	235 W Rdwy 2 LED Lum	TYPE 30 LIGHTING Std	TYPE 30 LIGHTING Std Fdn	30 A, 1P, 120 V, CB	2” CONDUIT (TYPE 3)	No. 6 CONDUCTOR	No. 8 BARE CONDUCTOR
E–3	EA	EA	EA	EA	EA	LF	LF	LF
					1		1640	2930
E–4	7	2	2	2		1030	2500	1030

(N) – NOT A SEPARATE BID ITEM

SHEET No.	(N)									
	SIGNAL MOUNT MAS	SIGNAL MOUNT TV–2–T	SIGNAL 3–12” (HOUSING, BACKPLATE, LED)	4G LTE WIRELESS MODEM ASSEMBLY	4G LTE ANTENNA	ETHERNET EXTENDER SWITCH COMBINATION UNIT	REMOTE ETHERNET POWER CONTROLLER SWITCH	24 VDC POWER SUPPLY	DATA SURGE SUPPRESSOR	DC TERMINAL BLOCK
E–5	EA	EA	EA	EA	EA	EA	EA	EA	EA	
	1	1	2	1	1	1	1	1	1	1

(N) – NOT A SEPARATE BID ITEM


Dist	COUNTY	ROUTE	POST MILES TOTAL PROJECT	SHEET No.	TOTAL SHEETS
03	ED	50	16.0/16.6	45	45


REGISTERED CIVIL ENGINEER

7-30-20
DATE

AUGUST 31, 2020

PLANS APPROVAL DATE

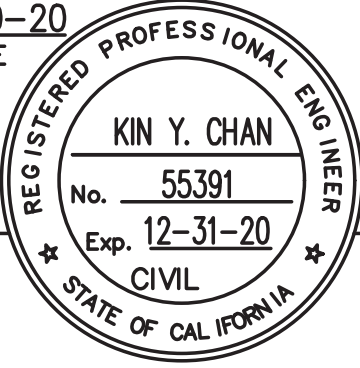

THE STATE OF CALIFORNIA OR ITS OFFICERS OR AGENTS SHALL NOT BE RESPONSIBLE FOR THE ACCURACY OR COMPLETENESS OF SCANNED COPIES OF THIS PLAN SHEET.

Y&C TRANSPORTATION CONSULTANTS, INC.
3250 RAMOS CIRCLE
SACRAMENTO, CA 95827

CITY OF PLACERVILLE PUBLIC WORKS
3101 CENTER STREET
PLACERVILLE, CA 95667

ELECTRICAL SYSTEMS QUANTITIES